


DRAWING NOTES:
 ① TYPICAL: PROVIDE NEW LIGHT FIXTURE, TYPE AS INDICATED. C/W ALL CONDUIT, WIRING AND SWITCHING.

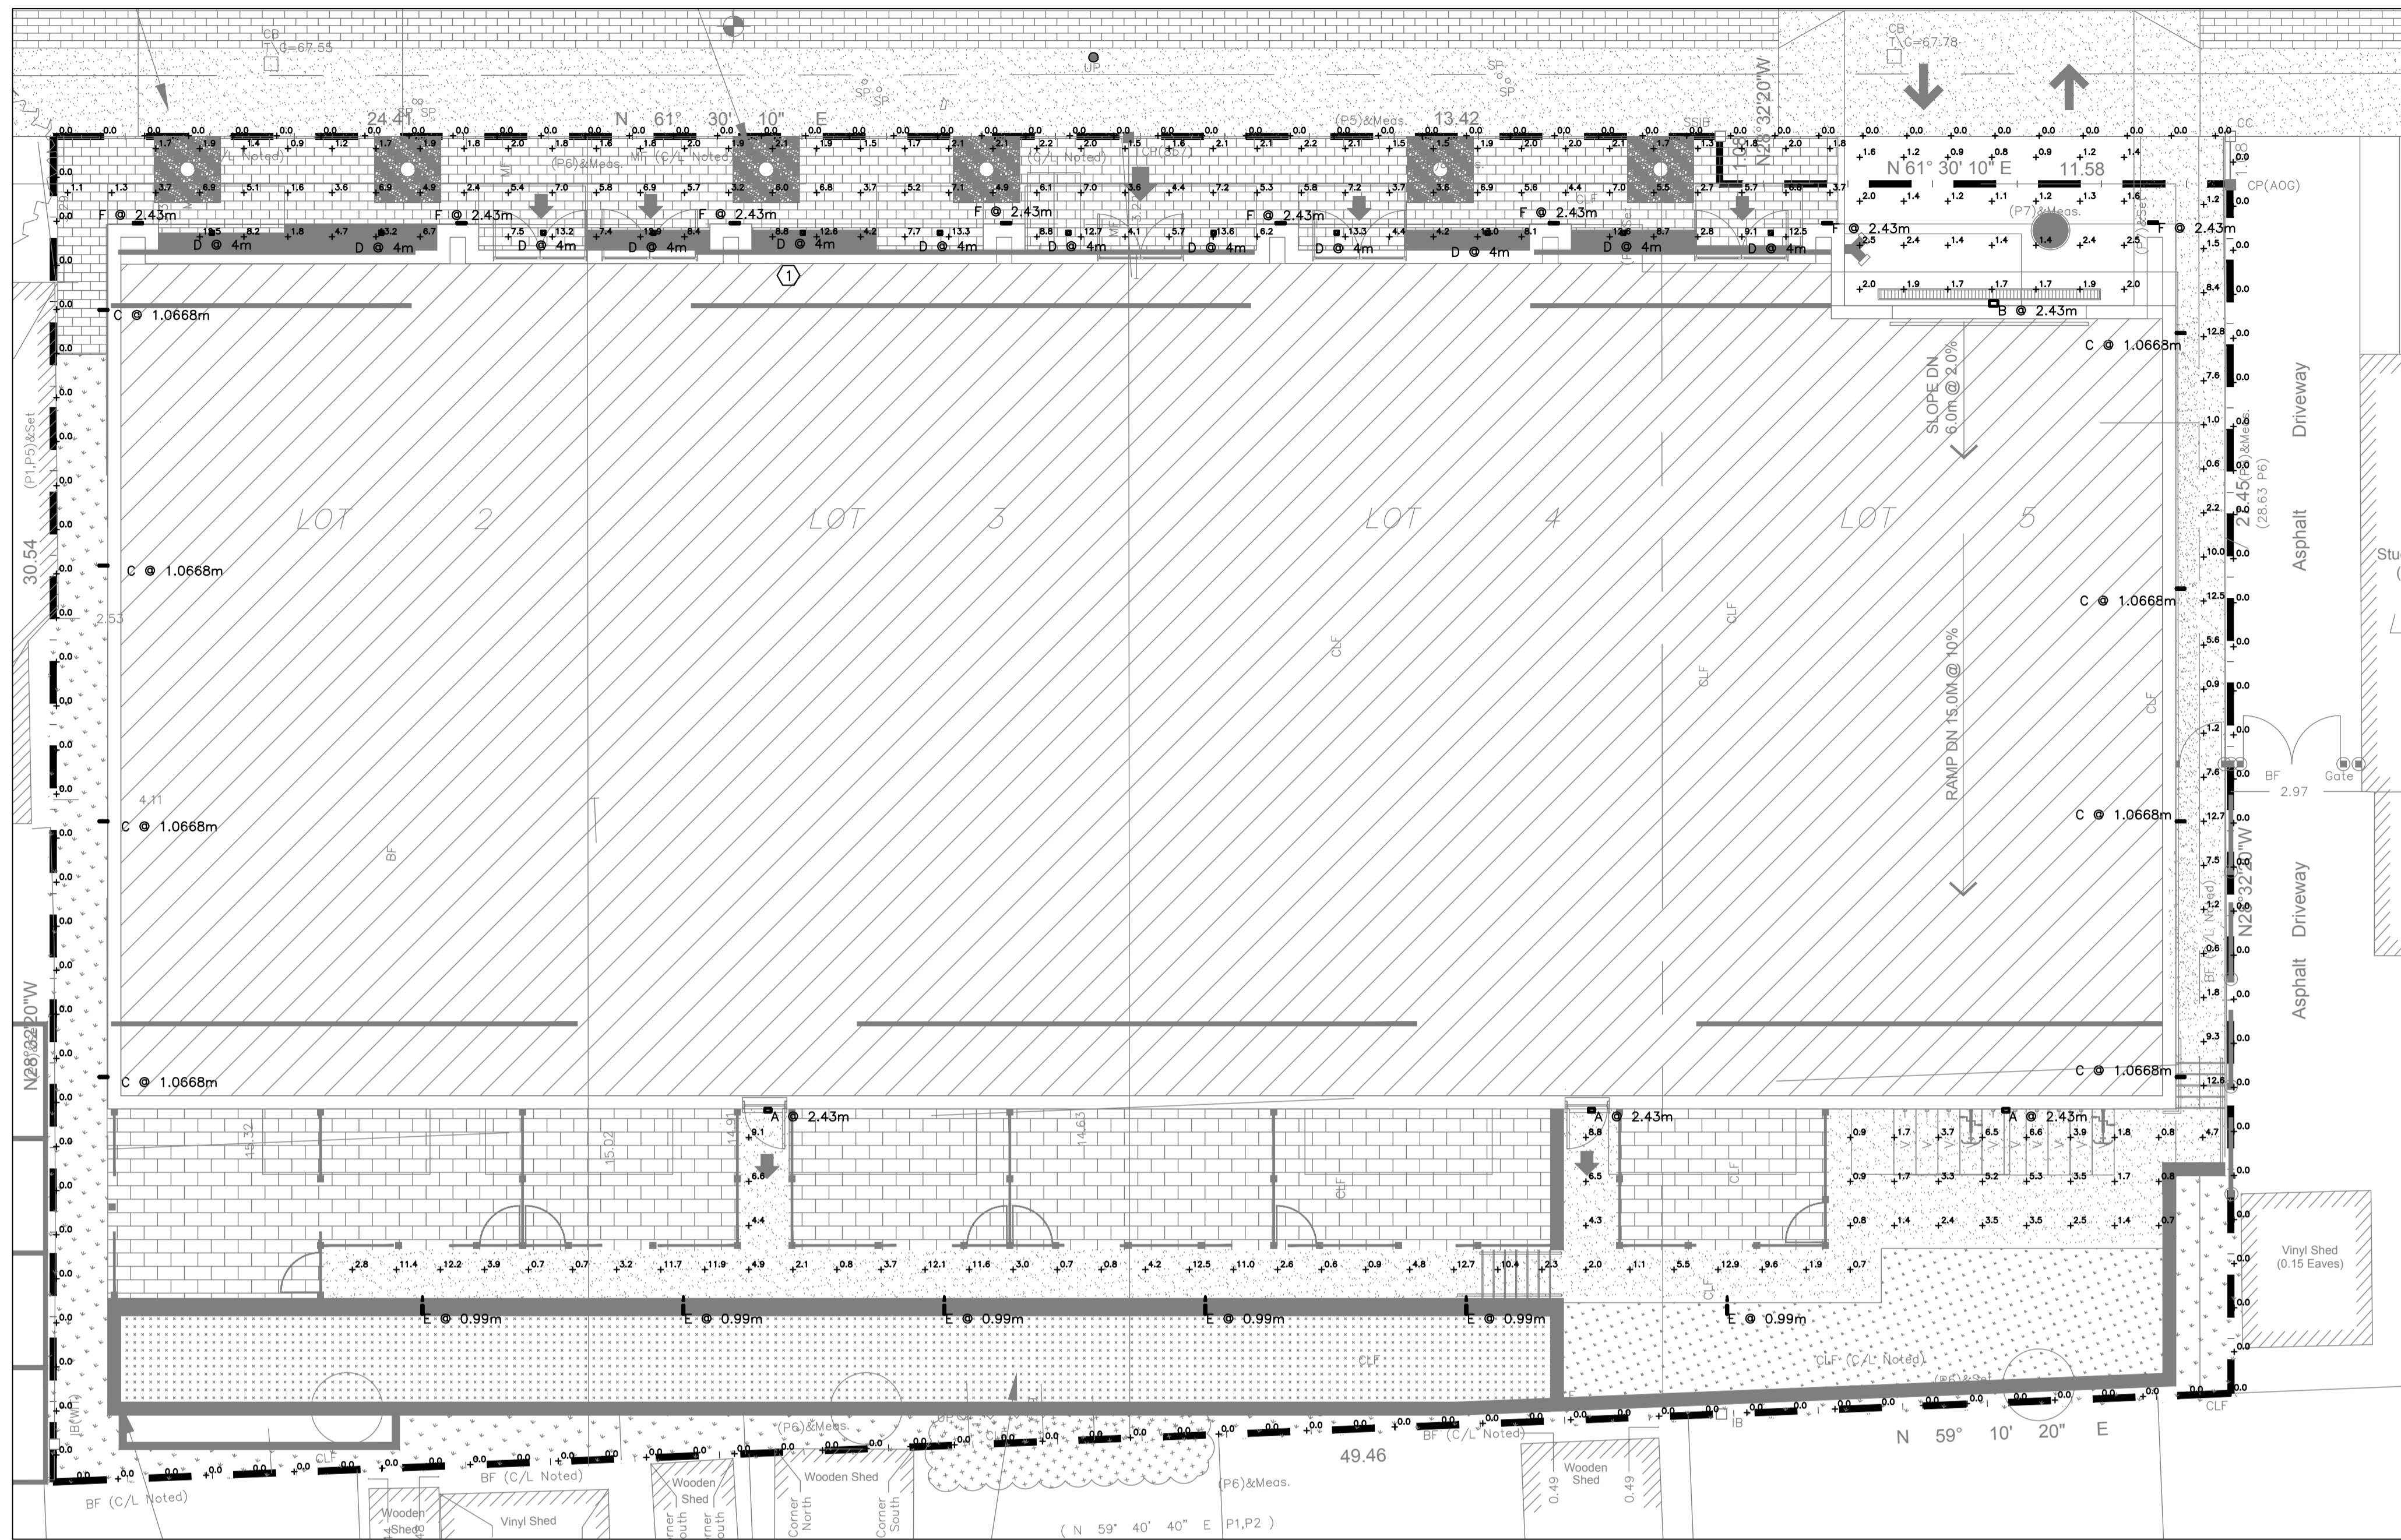

1 SITE LIGHTING PLAN
 E-1 1:100

LIGHTING FIXTURE SCHEDULE						
TYPE	MAKE/MODEL	VOLTAGE	MOUNT	LAMPS	LUMENS	NOTES
A	LITHONIA WDGE1 LED P1 30K 80CRI VF	120V	WALL MOUNT	LED	1161	
B	LITHONIA WDGE2 LED P0 30K 70CRI T1S	120V	WALL MOUNT	LED	733	
B2	LITHONIA WDGE2 LED P1 30K 70CRI T2M	120V	WALL MOUNT	LED	1325	
C	BEGA 22215K3	120V	WALL MOUNT	LED	173	
D	BEGA 24801	120V		LED	601	
E	Luminis Canada Inc. SN805B-L1L5	120V	POLE	LED	555	Scena - Ballard Round 8.5in

JRP ENGINEERING

Professional Engineers


110 Didsbury Rd – Unit M090, Kanata, ON, K2T 0C2
 Tel: 613-627-2462 Email: Admin@jrpeng.com

An exact copy of all working documents including, without limitations, the original of the present document or plan is kept on file by J.R.P. Engineering. Any modification carried out to this document or plan or to accompanying documents without written authorization by the engineer is prohibited.

Authorized modifications must be signed and sealed by an engineer and this engineer will be completely responsible for these modifications. J.R.P. Engineering is not and will not be responsible for the consequences of these modifications or for modifications carried out without its consent.

No	DESCRIPTION	DATE
2	RE-ISSUED FOR SITE PLAN APPLICATION	APRIL 17 2023
1	ISSUED FOR SITE PLAN APPLICATION	MAR 30 2023
0	ISSUED FOR REVIEW	NOV 25 2022

REVISIONS

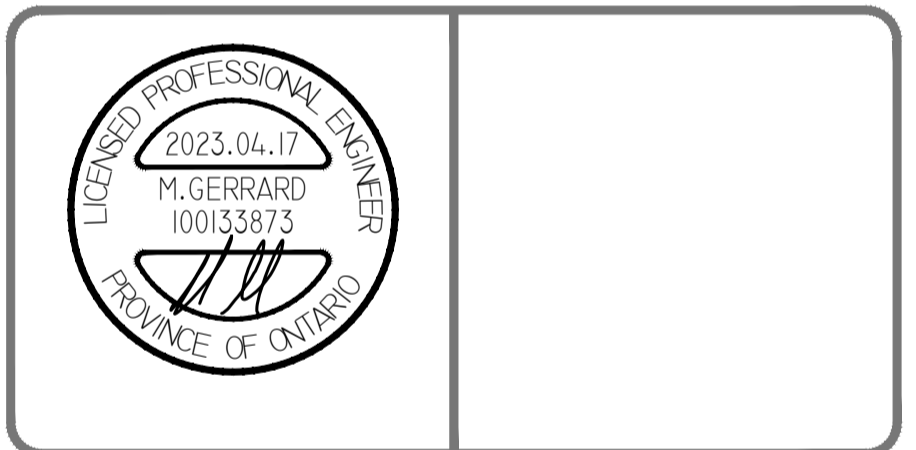

client:

project: 18 HAWTHORNE AVENUE
 OTTAWA, ONTARIO

drawing title: ELECTRICAL SITE LIGHTING PLAN

scale:	AS NOTED	drawn by:	C.M.
designed by:	C.M.	reviewed by:	M.G.
approved by:	M.G.	date:	JAN 2023

project no.: 145-2201
 drawing no.: SP-E1 of 1