



- NOTE:**
- ALL SERVICE CONNECTIONS AND CATCHBASIN CONNECTIONS TO BE MADE PER CITY OF OTTAWA DETAIL S11 AND S11.2
 - BACKWATER VALVES TO BE PROVIDED ON ALL STORM AND SANITARY LATERALS AS PER CITY OF OTTAWA DETAILS S14, S14.1, AND S14.2. DOWNSTREAM OF ANY GRAVITY OUTLET FROM THE BUILDING. REFER TO MECHANICAL PLANS FOR DETAILS
 - ALL FLOWS FROM THE UNDERGROUND PARKING GARAGE ARE TO BE CONVEYED TO THE SANITARY SERVICE. FLOWS ARE TO BE PUMPED TO THE PROPOSED SANITARY SERVICE (TYP)
 - PROPOSED SERVICES TO BE SLEEVED THROUGH FOUNDATION WALL WHERE INVERT IS ABOVE THE UNDERSIDE OF FOOTING. FOUNDATION DRAINS TO BE PUMPED TO STORM SERVICE WHEN GRAVITY FEED IS NOT FEASIBLE.
 - FLOWS FROM TRENCHDRAINS ARE TO BE CONVEYED DIRECTLY TO THE STORM SERVICE WHEN A CISTERN IS NOT PRESENT. IN BUILDINGS WHERE A CISTERN IS PROPOSED, TRENCH DRAIN FLOWS ARE TO BE CONVEYED TO THE CISTERN. REFER TO MECHANICAL PLANS FOR DETAILS.
 - REFER TO MECHANICAL DRAWINGS FOR FURTHER DETAILS ON INTERNAL PLUMBING (TYP).

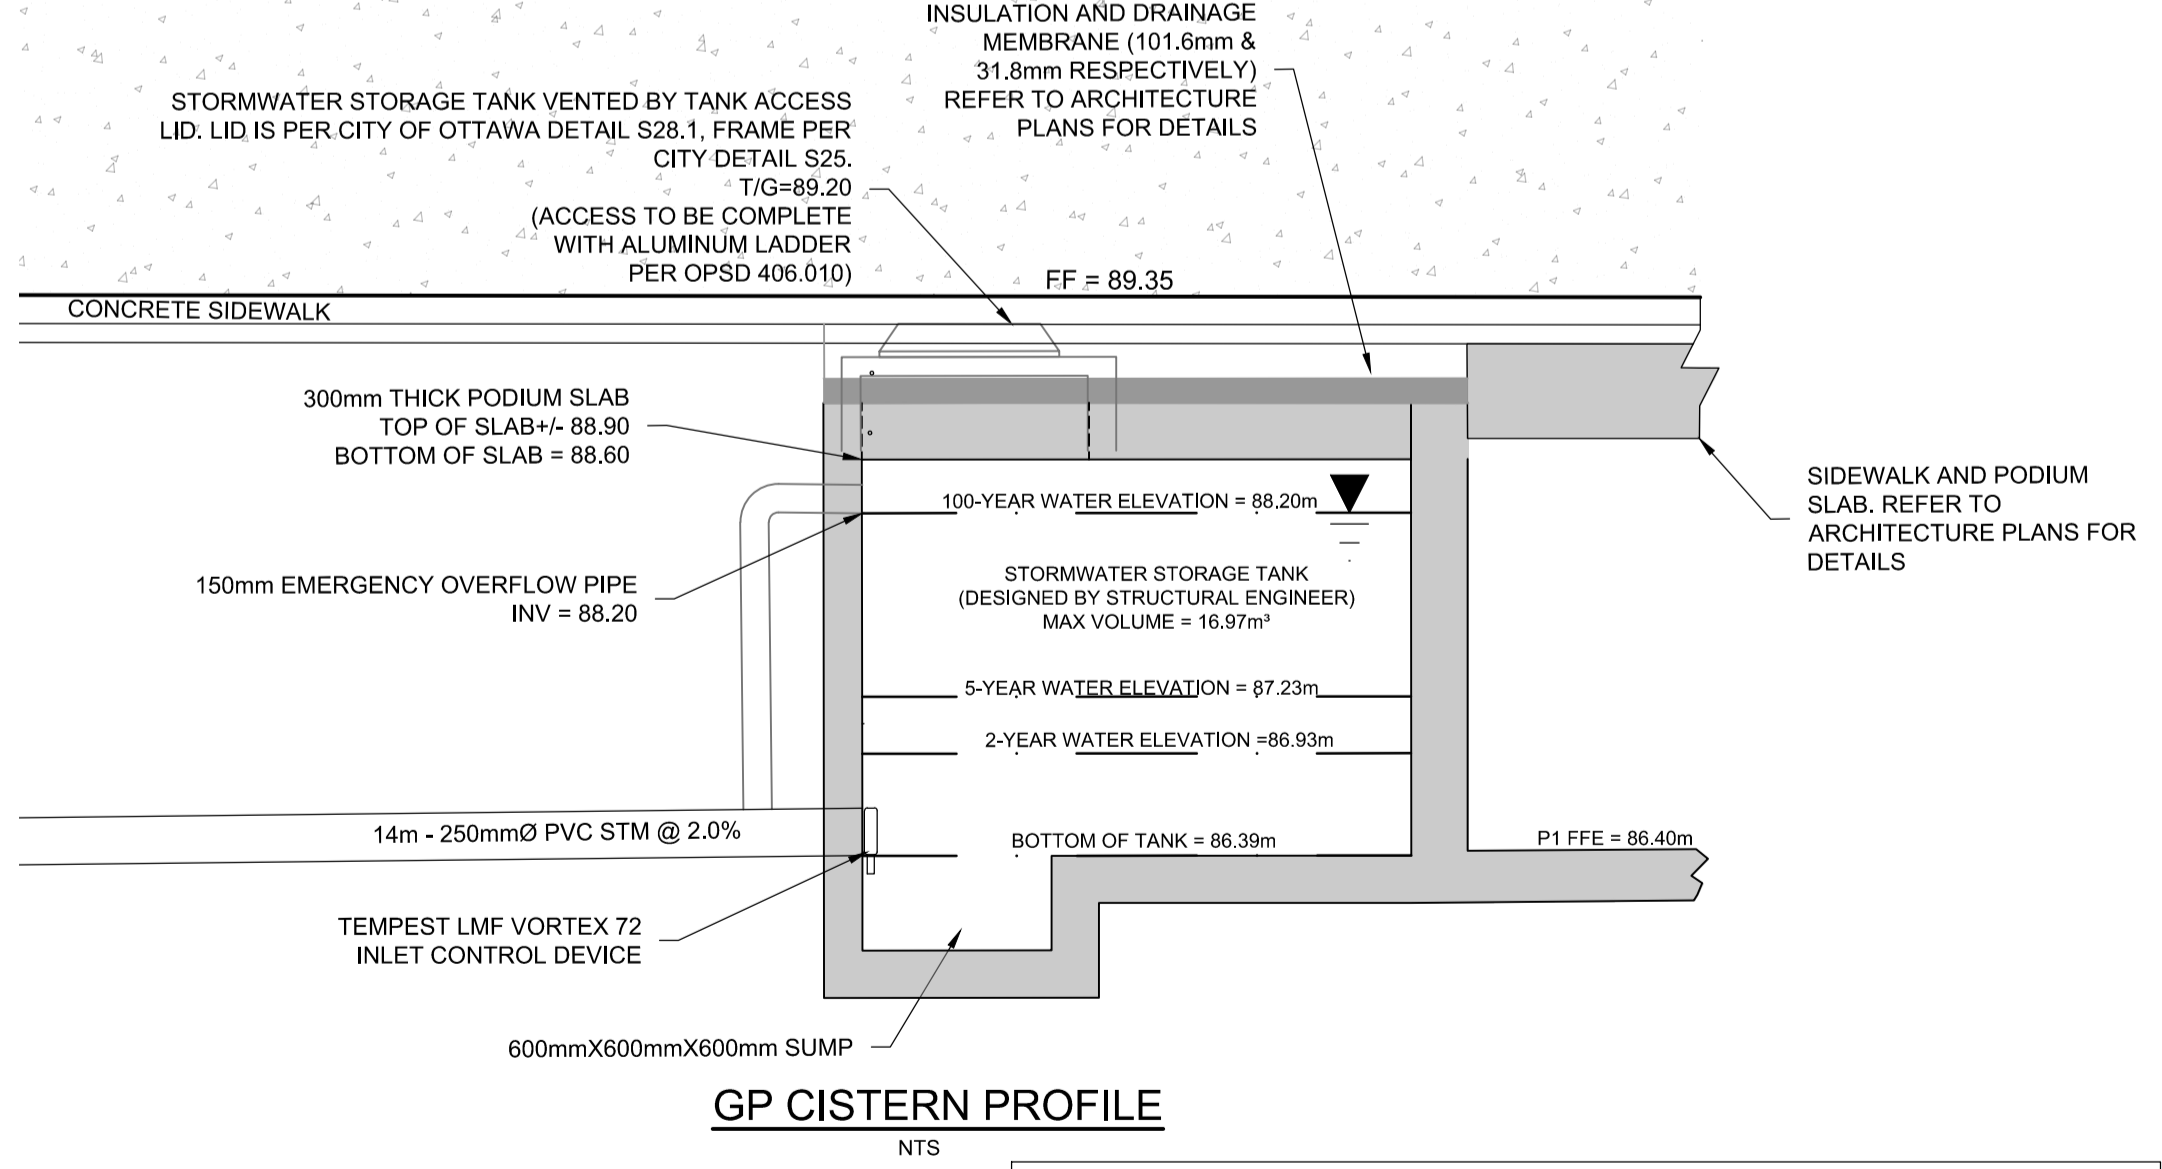

NOTE: THE POSITION OF ALL POLE LINES, CONDUITS, WATERMANS, SEWERS AND OTHER UNDERGROUND AND OVERGROUND UTILITIES AND STRUCTURES IS NOT NECESSARILY SHOWN ON THE CONTRACT DRAWINGS, AND WHERE SHOWN, THE ACCURACY OF THE POSITION OF SUCH UTILITIES AND STRUCTURES IS NOT GUARANTEED. BEFORE STARTING WORK, DETERMINE THE EXACT LOCATION OF ALL SUCH UTILITIES AND STRUCTURES AND ASSUME ALL LIABILITY FOR DAMAGE TO THEM.

NOT FOR CONSTRUCTION

No.	REVISION	DATE	BY
2.	REVISED PER CITY COMMENTS	SEPT 15/2023	GJM
1	ISSUED FOR SITE PLAN APPLICATION	MAY 24/2023	GJM

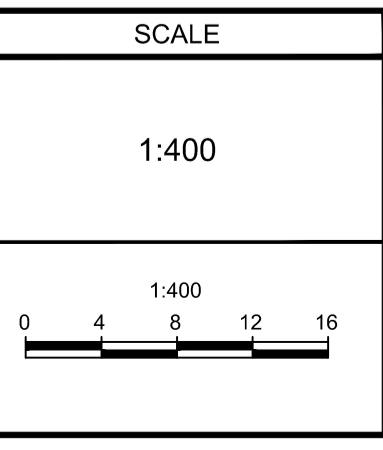

DESIGN ARM/CJF
CHECKED ARM
DRAWN ARM/CJF
CHECKED ARM
APPROVED GJM

FOR REVIEW ONLY

ARM/CJF

ARM

ARM/CJF

ARM

GJM

PROFESSIONAL ENGINEER
A. R. MESTWAP
100201604
September 15/2023
PROVINCE OF ONTARIO

PROFESSIONAL ENGINEER
G. J. MacDONALD
Sept 15, 2023
PROVINCE OF ONTARIO

NOVATECH

Engineers, Planners & Landscape Architects
Suite 200, 240 Michael Cowpland Drive
Ottawa, Ontario, Canada K2M 1P6

Telephone (613) 254-9643
Facsimile (613) 254-5867
Website www.novatech-eng.com

LOCATION
4200 INNES ROAD, CITY OF OTTAWA
TRINTY APARTMENTS

DRAWING NAME
GENERAL PLAN OF SERVICES

PROJECT No. 122179

REV#2

DRAWING No. 122179 - GP

PLAN No. 18993

M:\2023\122179\GP\CD\122179-GP.dwg, GP, Sep 14, 2023, 11:07am, armstwap