


WOODVALE PENTECOSTAL CHURCH - NEW ADDITION

205 GREENBANK RD, NEPEAN, ON K2H 8K9

ELECTRICAL

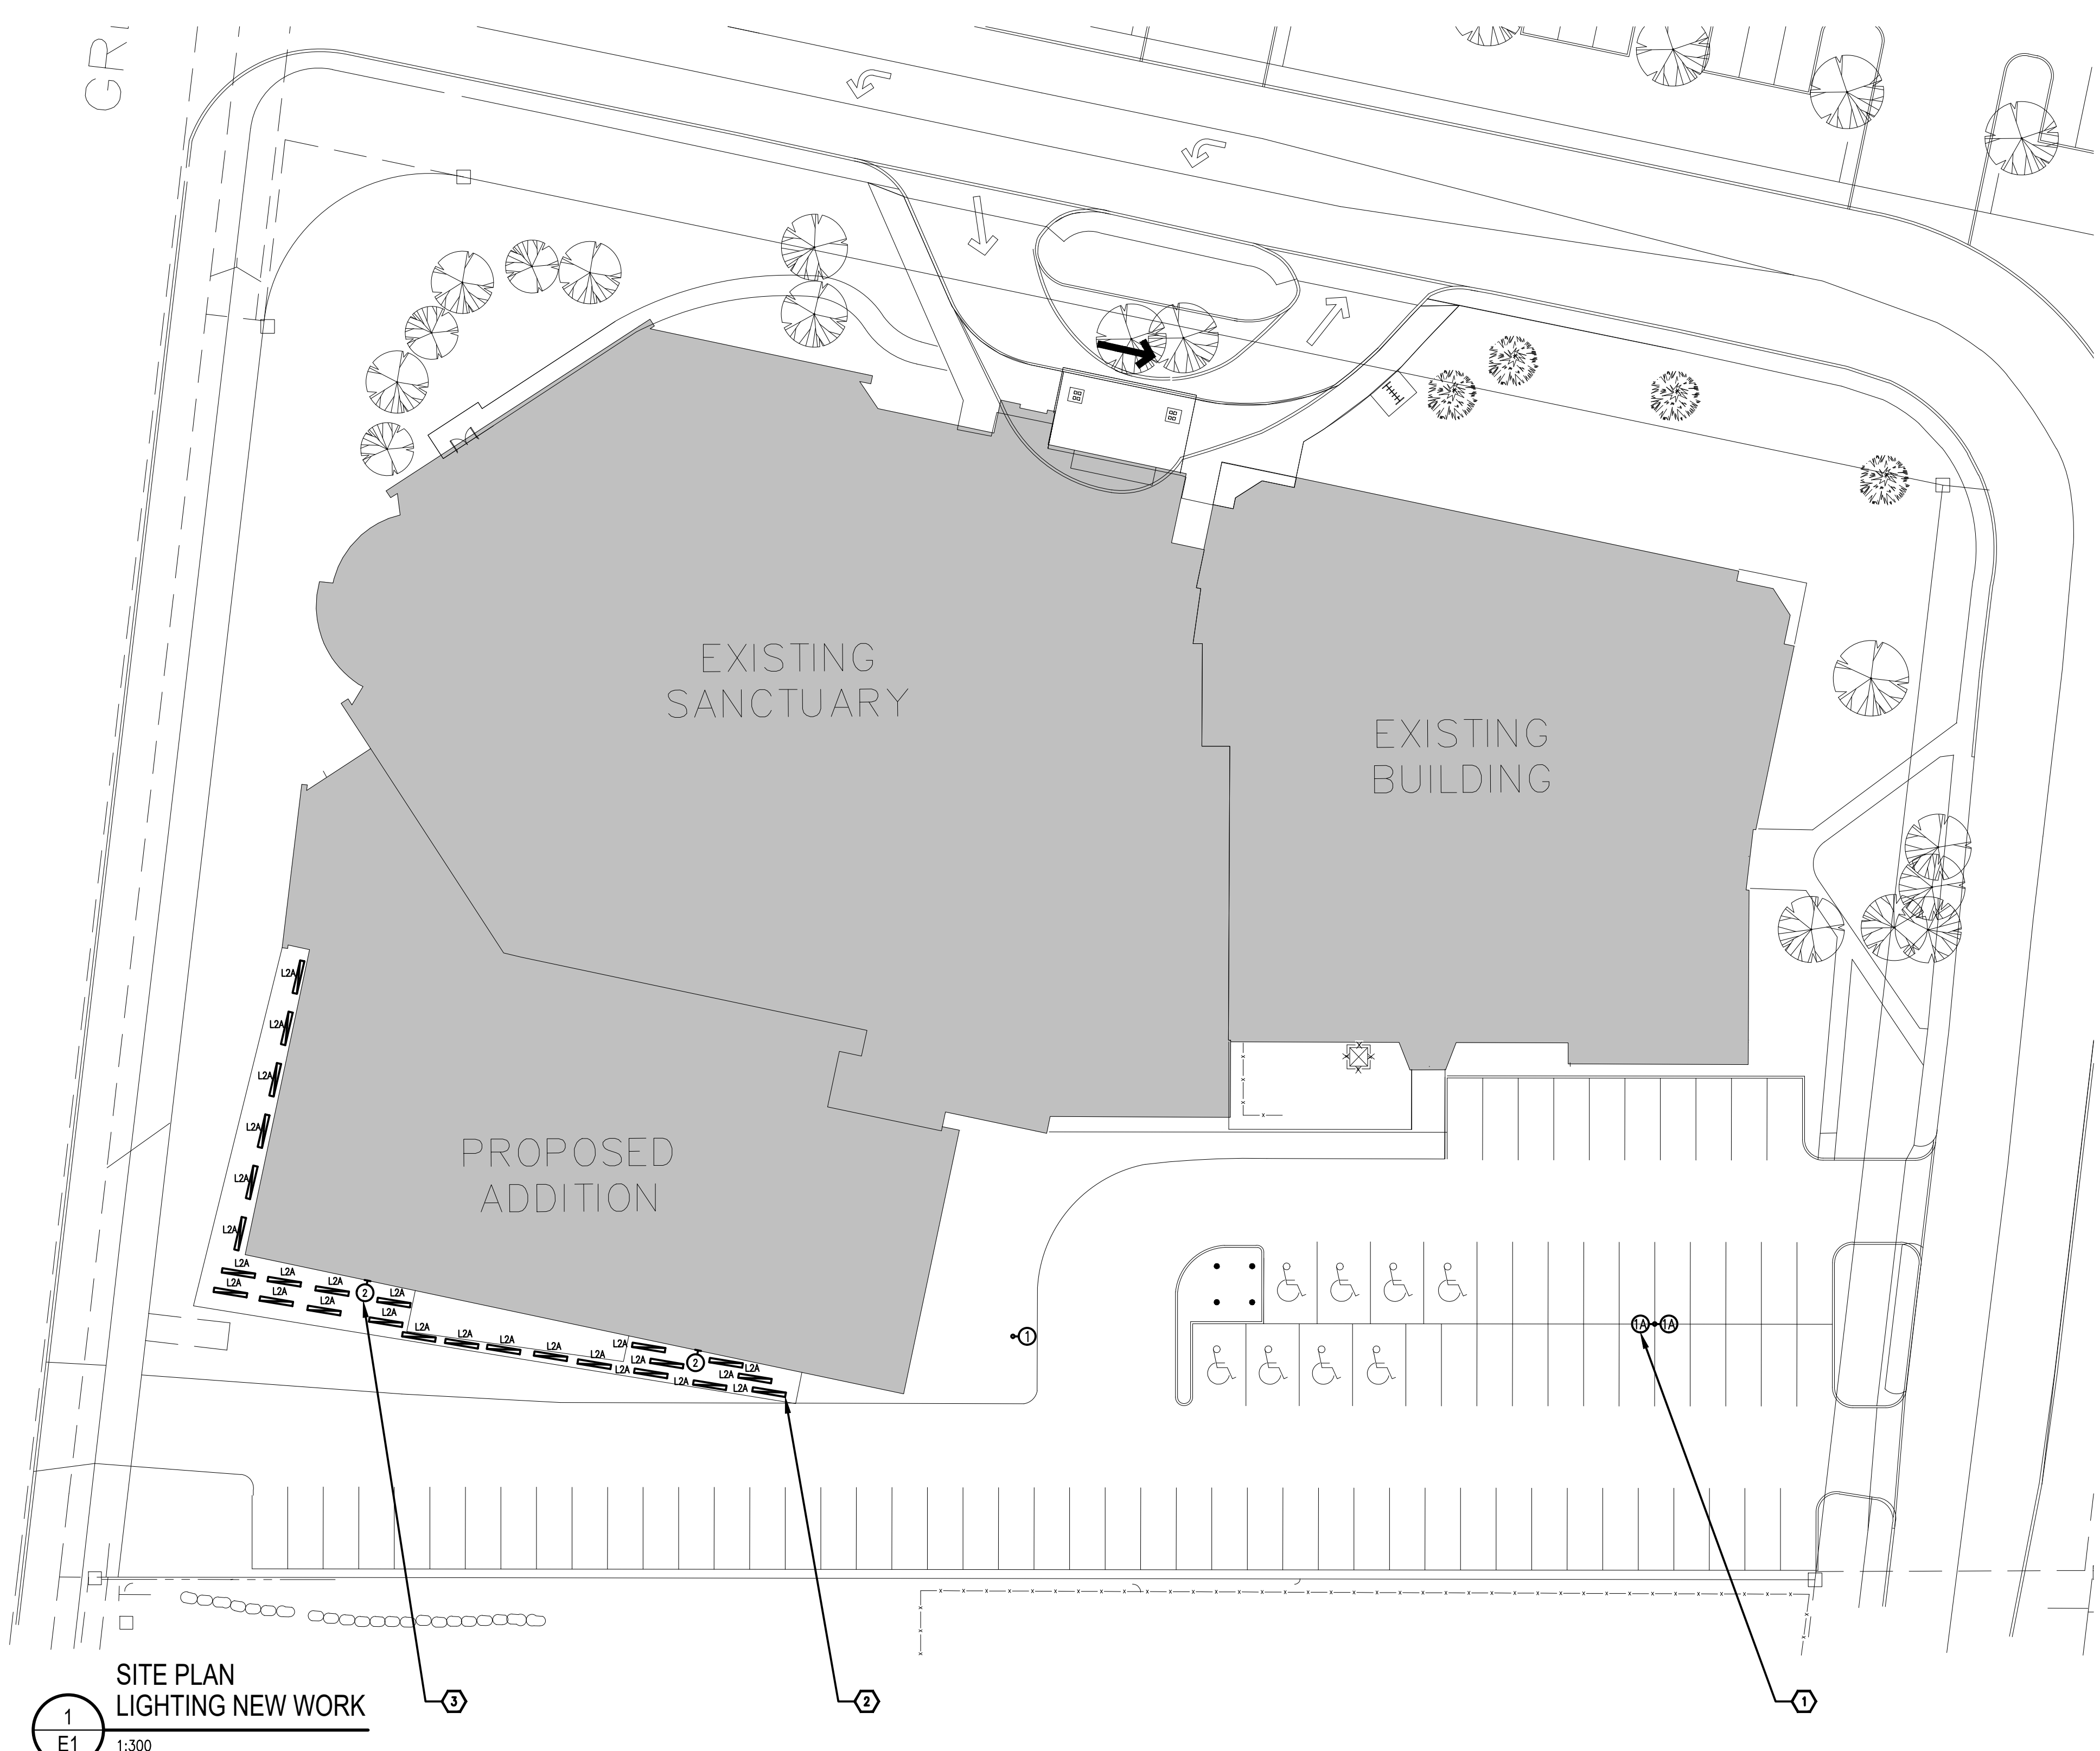

DRAWING LIST	
SYMBOL	DESCRIPTION
E1	ELECTRICAL SITE LIGHTING WORK

LIGHTING LEGEND	
SYMBOL	DESCRIPTION
⊕	EXTERIOR POLE MOUNTED LIGHT FIXTURE - TYPE AS SHOWN
⊙	EXTERIOR WALL PACK LIGHT FIXTURE - TYPE AS SHOWN
⊖	EXTERIOR DOWNLIGHT FIXTURE - TYPE AS SHOWN

- DRAWING NOTES**
- TYPICAL:** PROVIDE NEW EXTERIOR POLE MOUNTED LIGHT FIXTURE C/W CONDUIT AND WIRE AND CONNECT TO NEW TIME CLOCK SYSTEM AND NEW EXTERIOR LIGHTING CIRCUIT. COORDINATE EXACT LOCATION, MOUNTING AND MOUNTING HEIGHT ON SITE WITH CLIENT REPRESENTATIVE AND ARCHITECT.
 - TYPICAL:** PROVIDE NEW EXTERIOR LINEAR FIXTURE C/W CONDUIT AND WIRE AND CONNECT TO NEW TIME CLOCK SYSTEM AND NEW EXTERIOR LIGHTING CIRCUIT. COORDINATE EXACT LOCATION, MOUNTING AND MOUNTING HEIGHT ON SITE WITH CLIENT REPRESENTATIVE AND ARCHITECT.
 - TYPICAL:** PROVIDE NEW EXTERIOR WALL PACK FIXTURE C/W CONDUIT AND WIRE AND CONNECT TO NEW TIME CLOCK SYSTEM AND NEW EXTERIOR LIGHTING CIRCUIT. COORDINATE EXACT LOCATION, MOUNTING AND MOUNTING HEIGHT ON SITE WITH CLIENT REPRESENTATIVE AND ARCHITECT.

DATE	REVISION	REF
2023-08-31	ISSUED FOR SITE PLAN APPROVAL	0

THE ENGINEER WAIVES ANY AND ALL RESPONSIBILITY AND LIABILITY FOR PROBLEMS WHICH ARISE FROM FAILURE TO FOLLOW THESE PLANS, SPECIFICATIONS AND THE DESIGN INTENT THEY CONVEY, OR FOR PROBLEMS WHICH ARISE FROM OTHER FAILURE TO OBTAIN AND / OR FOLLOW THE ENGINEER'S GUIDANCE WITH RESPECT TO ANY ERRORS, OMISSIONS, INCONSISTENCIES, AMBIGUITIES OR CONFLICTS WHICH ARE ALLEGED.

THIS DRAWING IS THE PROPERTY OF GOODKEY WEEDMARK & ASSOCIATES LIMITED AND ALL COPYRIGHTS ARE RESERVED. NO USE OF THIS DRAWING MAY BE MADE WITHOUT EXPRESS WRITTEN CONSENT.

DO NOT SCALE DRAWINGS

L'INGÉNIEUR DÉCLINE TOUTE RESPONSABILITÉ DÉCOULANT DE PROBLÈMES FAISANT SUITE AU NON RESPECT DES PLANS, DES SPÉCIFICATIONS ET DE L'INTENTION DU CONCEPTEUR, OÙ ILS INDIQUENT OU DE TOUS LES PROBLÈMES POUVANT RÉSULTER DU DÉFAUT D'OBTENIR ET / OU DE SUIVRE LES CONSEILS DE L'INGÉNIEUR EN CE QUI CONCERNE LES ERREURS, OMISSIONS, INCONSISTANCES, AMBIGUITÉS OU CONFLITS ALLÉGUÉS.

CE Dessin est la propriété littéraire & associée de Goodkey Weedmark & Associates Limited et tous les droits sont réservés. L'utilisation est interdite sans le consentement écrit de l'auteur.

NE PAS MESURER LES DESSINS À L'ÉCHELLE

Goodkey Weedmark
Consulting Engineers

GOODKEY WEEDMARK & ASSOCIATES LIMITED
1688 Woodward Dr. Ottawa Ontario Canada K2C 3R8

613 727-5111 Voice
613 727-5115 Fax
www.gweal.com Web

Project north / Nord du projet

Seal/Scieu

LICENSED PROFESSIONAL ENGINEER
J. MOFFAT
100120151
2023-08-31
PROVINCE OF ONTARIO

Project/Projet
**205 GREENBANK RD.
WOODVALE PENTECOSTAL
CHURCH - NEW ADDITION**

Drawing title/Titre du dessin
**ELECTRICAL
SITE LIGHTING
WORK**

Scale / Échelle	AS NOTED	Project no./No. du projet	2021-284-1
Design by / Conçu par	J.MOFFAT	Drawing/Dessein	E1
Drawn by / Dessiné par	C.BEHAN	Examined by / Examiné par	
Date	AUGUST 2023	Revision no.	OF 1

SITE PLAN LIGHTING NEW WORK
1 E1 1:300

LIGHTING FIXTURE SCHEDULE									
TYPE	DESCRIPTION	CATALOG NUMBER	LAMPS PER FIXTURE			VOLT	MOUNTING	REMARKS	
			QTY	TYPE	WATTS				
1	NEW LED ARCHITECTURAL EXTERIOR POLE FIXTURE	CREE OSQL-B-30L-40K7-4M-UH-NM-BZ + OSQ-ML-DA	1	LED	202W	4000K	347V	POLE	-
1A	NEW LED ARCHITECTURAL EXTERIOR POLE FIXTURE	CREE OSQL-B-30L-40K7-4M-UH-NM-BZ + OSQ-ML-DA	1	LED	202W	4000K	347V	POLE	-
2	NEW EXTERIOR ARCHITECTURAL WALL PACK	CREE XSPW-B-NM-4ME-6L-40K-UH-BZ	1	LED	47W	4000K	347V	SURFACE	-
L2A	NEW LED ARCHITECTURAL DOWNLIGHT	JG LIGHTING JG-15LI-D250-S80-35K-UNV-DM-FL-XX-4'	1	LED	9.15W	3500K	347V	SUSPENDED	-

NOTES:
1. COORDINATE AMING OF FIXTURES WITH ARCHITECT AND CLIENT REPRESENTATIVE.