


- LEGEND: REMOVAL**
- ASPHALT REMOVAL
 - CATCHBASIN REMOVAL
 - STORM MANHOLE REMOVAL
 - SANITARY MANHOLE REMOVAL
 - HYDRO MANHOLE REMOVAL
 - WATER VALVE REMOVAL
 - FIRE HYDRANT REMOVAL
 - STORM SEWER REMOVAL
 - SANITARY SEWER REMOVAL
 - WATERMAIN REMOVAL
 - POWER CONDUIT REMOVAL
 - CONCRETE CURB REMOVAL

- NOTES:**
- FOR TREE AND PLANT REMOVALS, REFER TO TREE CONSERVATION REPORT.
 - FOR REMOVALS OF ELECTRICAL AND TELECOMMUNICATIONS, REFER TO ELECTRICAL DEMOLITION - SITE PLAN.
 - CONTRACTOR TO SALVAGE EXISTING METERING INFRASTRUCTURE AND PROVIDE TO UNIVERSITY.

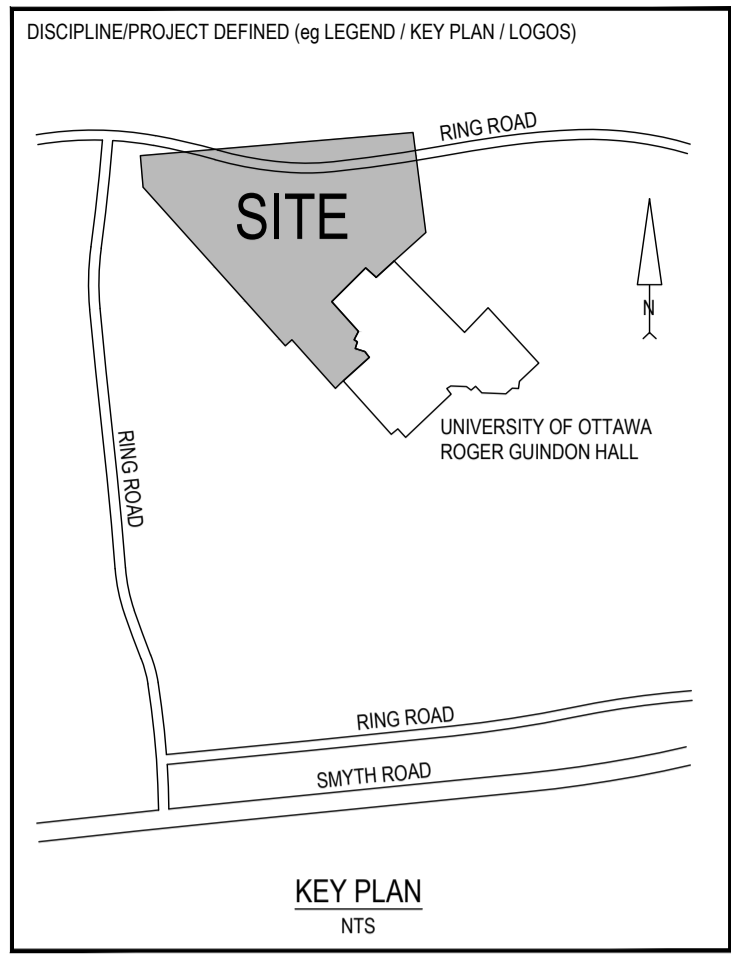

REVISION:

REV	DATE	DESCRIPTION	BY
6	2024-04-18	ISSUED FOR ZBLA AND SPC SUBMISSION	VT
5	2024-02-26	ISSUED FOR SITE PLAN APPROVAL	VT
4	2024-02-02	ISSUED FOR COORDINATION	VT
3	2023-11-30	ISSUED FOR SITE PLAN APPROVAL	VT
2	2023-11-20	ISSUED FOR BUILDING PERMIT	VT
1	2023-10-31	ISSUED FOR PRICING PROPOSAL	VT

SEAL:

NORTH:

DISCLAIMER: THIS DRAWING AND DESIGN IS COPYRIGHT PROTECTED WHICH SHALL NOT BE USED, REPRODUCED OR REVISED WITHOUT WRITTEN PERMISSION BY WSP. THE CONTRACTOR SHALL CHECK AND VERIFY ALL DIMENSIONS AND UTILITY LOCATIONS AND REPORT ALL ERRORS AND OMISSIONS PRIOR TO COMMENCING WORK.

ORIGINAL SCALE: AS NOTED
DESIGNED BY: Y. TENG
DRAWN BY: B. NANDLAL
APPROVED BY: I. JAFFERJEE
DISCIPLINE: CIVIL

DATE: 2023-09-25
IF THIS BAR IS NOT 25mm LONG, ADJUST YOUR PLOTTING SCALE.

WSP CANADA INC.
2611 QUEENVIEW DRIVE, SUITE 300
OTTAWA ONTARIO K2B 8K2 CANADA
WSP.COM


PROJECT NUMBER: CA0009956.0165-CA
CLIENT:

CLIENT REF. #:

PROJECT:
ADVANCED MEDICAL RESEARCH CENTRE

TITLE:
EXISTING CONDITIONS AND REMOVALS PLAN

DRAWING NUMBER: **C102** | REV: **6**

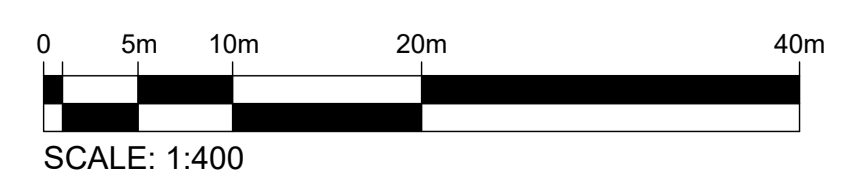

C:\Users\wsp_001\OneDrive - wsp.com\Documents\2024-04-18 - 11:42 AM
 FILE: \\10.10.13.mn.2023.project\ca0009956.0165-ca\ottawa_amlc_pursuit\4.0\tech_prof_services\14.60_civils_drawing\working_drawing\sheet\ca0009956.0165-ca_dml_amlc.dwg
 PLOTTED: 2024-04-18 - 11:42 AM