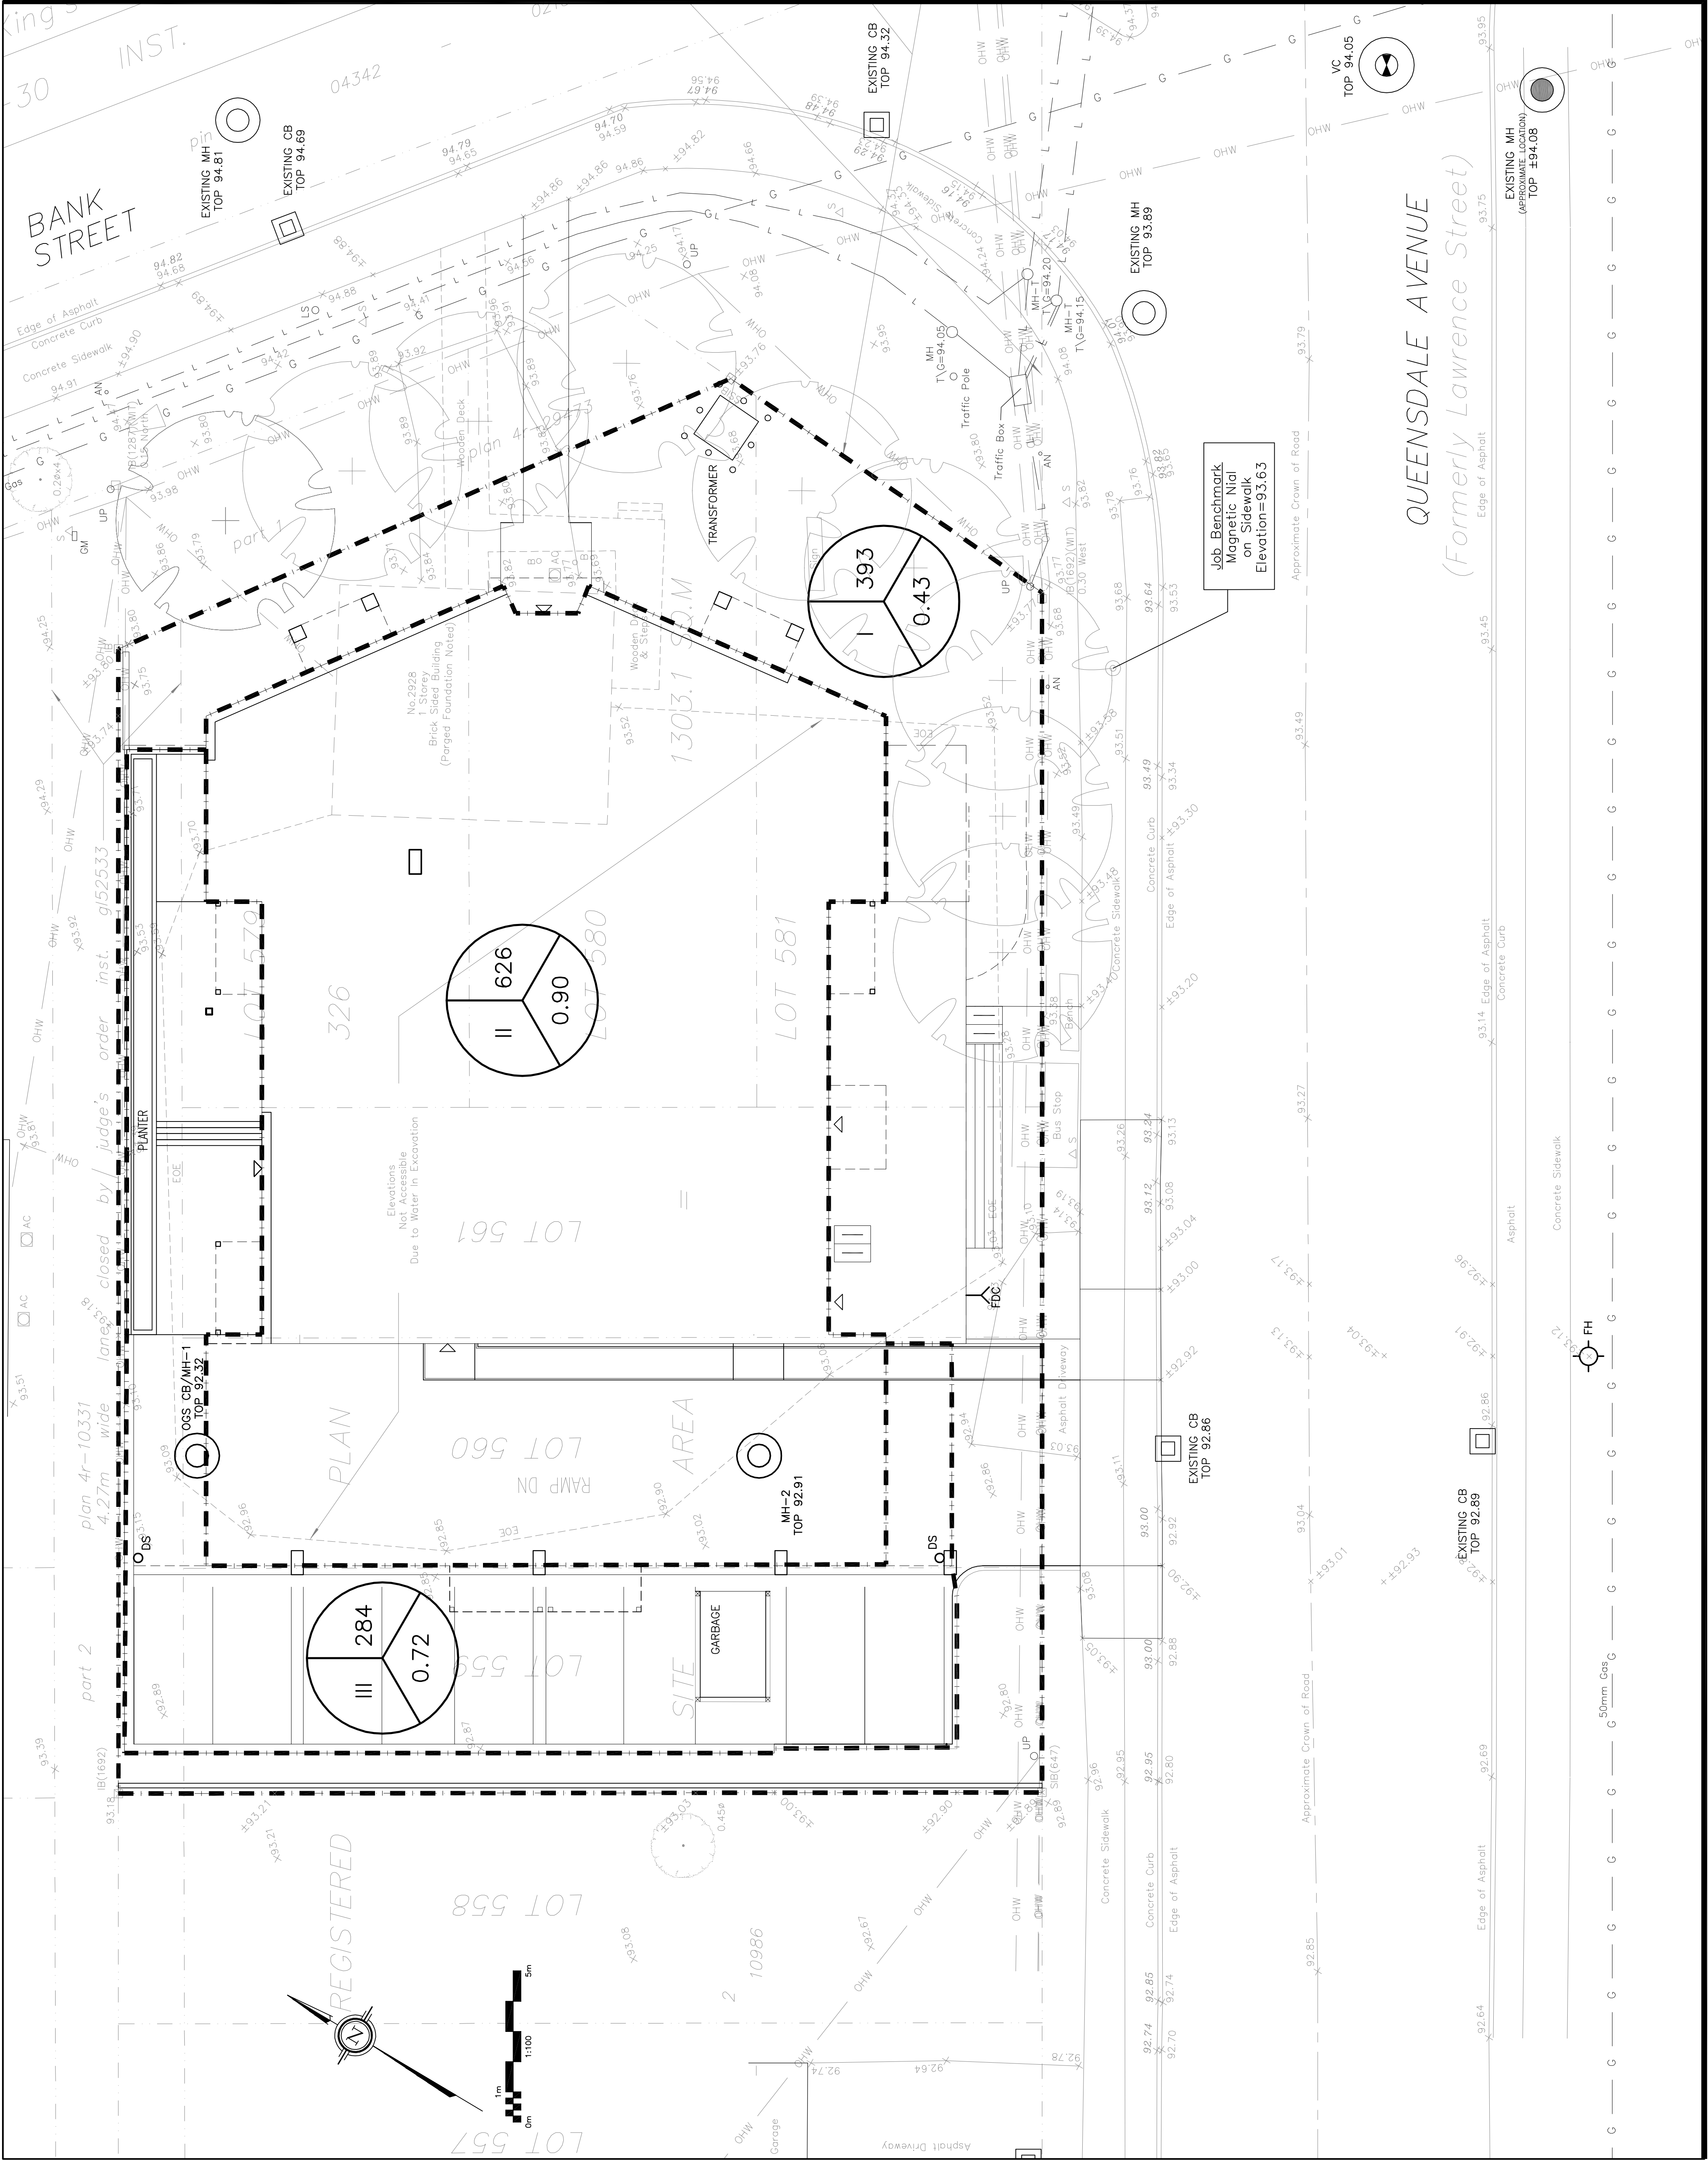


[illegible]

D. B. GRAY ENGINEERING INC.
Stormwater Management • Grading & Drainage • Storm & Sanitary Sewers • Watersheds

700 Long Point Circle
Ottawa, Ontario

613-425-8044
d.gray@dbgrayengineering.com

Project
PROPOSED 4-STORY
APARTMENT BUILDING
2928 BANK STREET
OTTAWA, ONTARIO

Drawing Title

**POST-DEVELOPMENT
DRAINAGE PLAN**

Drawn	D.B.G.
H. Scale	1:100
V. Scale	
Date	MAR 22-24
Job No.	23019