




MVP LIGHTING
Liam Beck
em: liam@mvp-lighting.ca
ph: 613-601-2042

Drawn By:
Checked By:
Date: 5/3/2024

Scale:

STITTSVILLE STATION

MVP LIGHTING

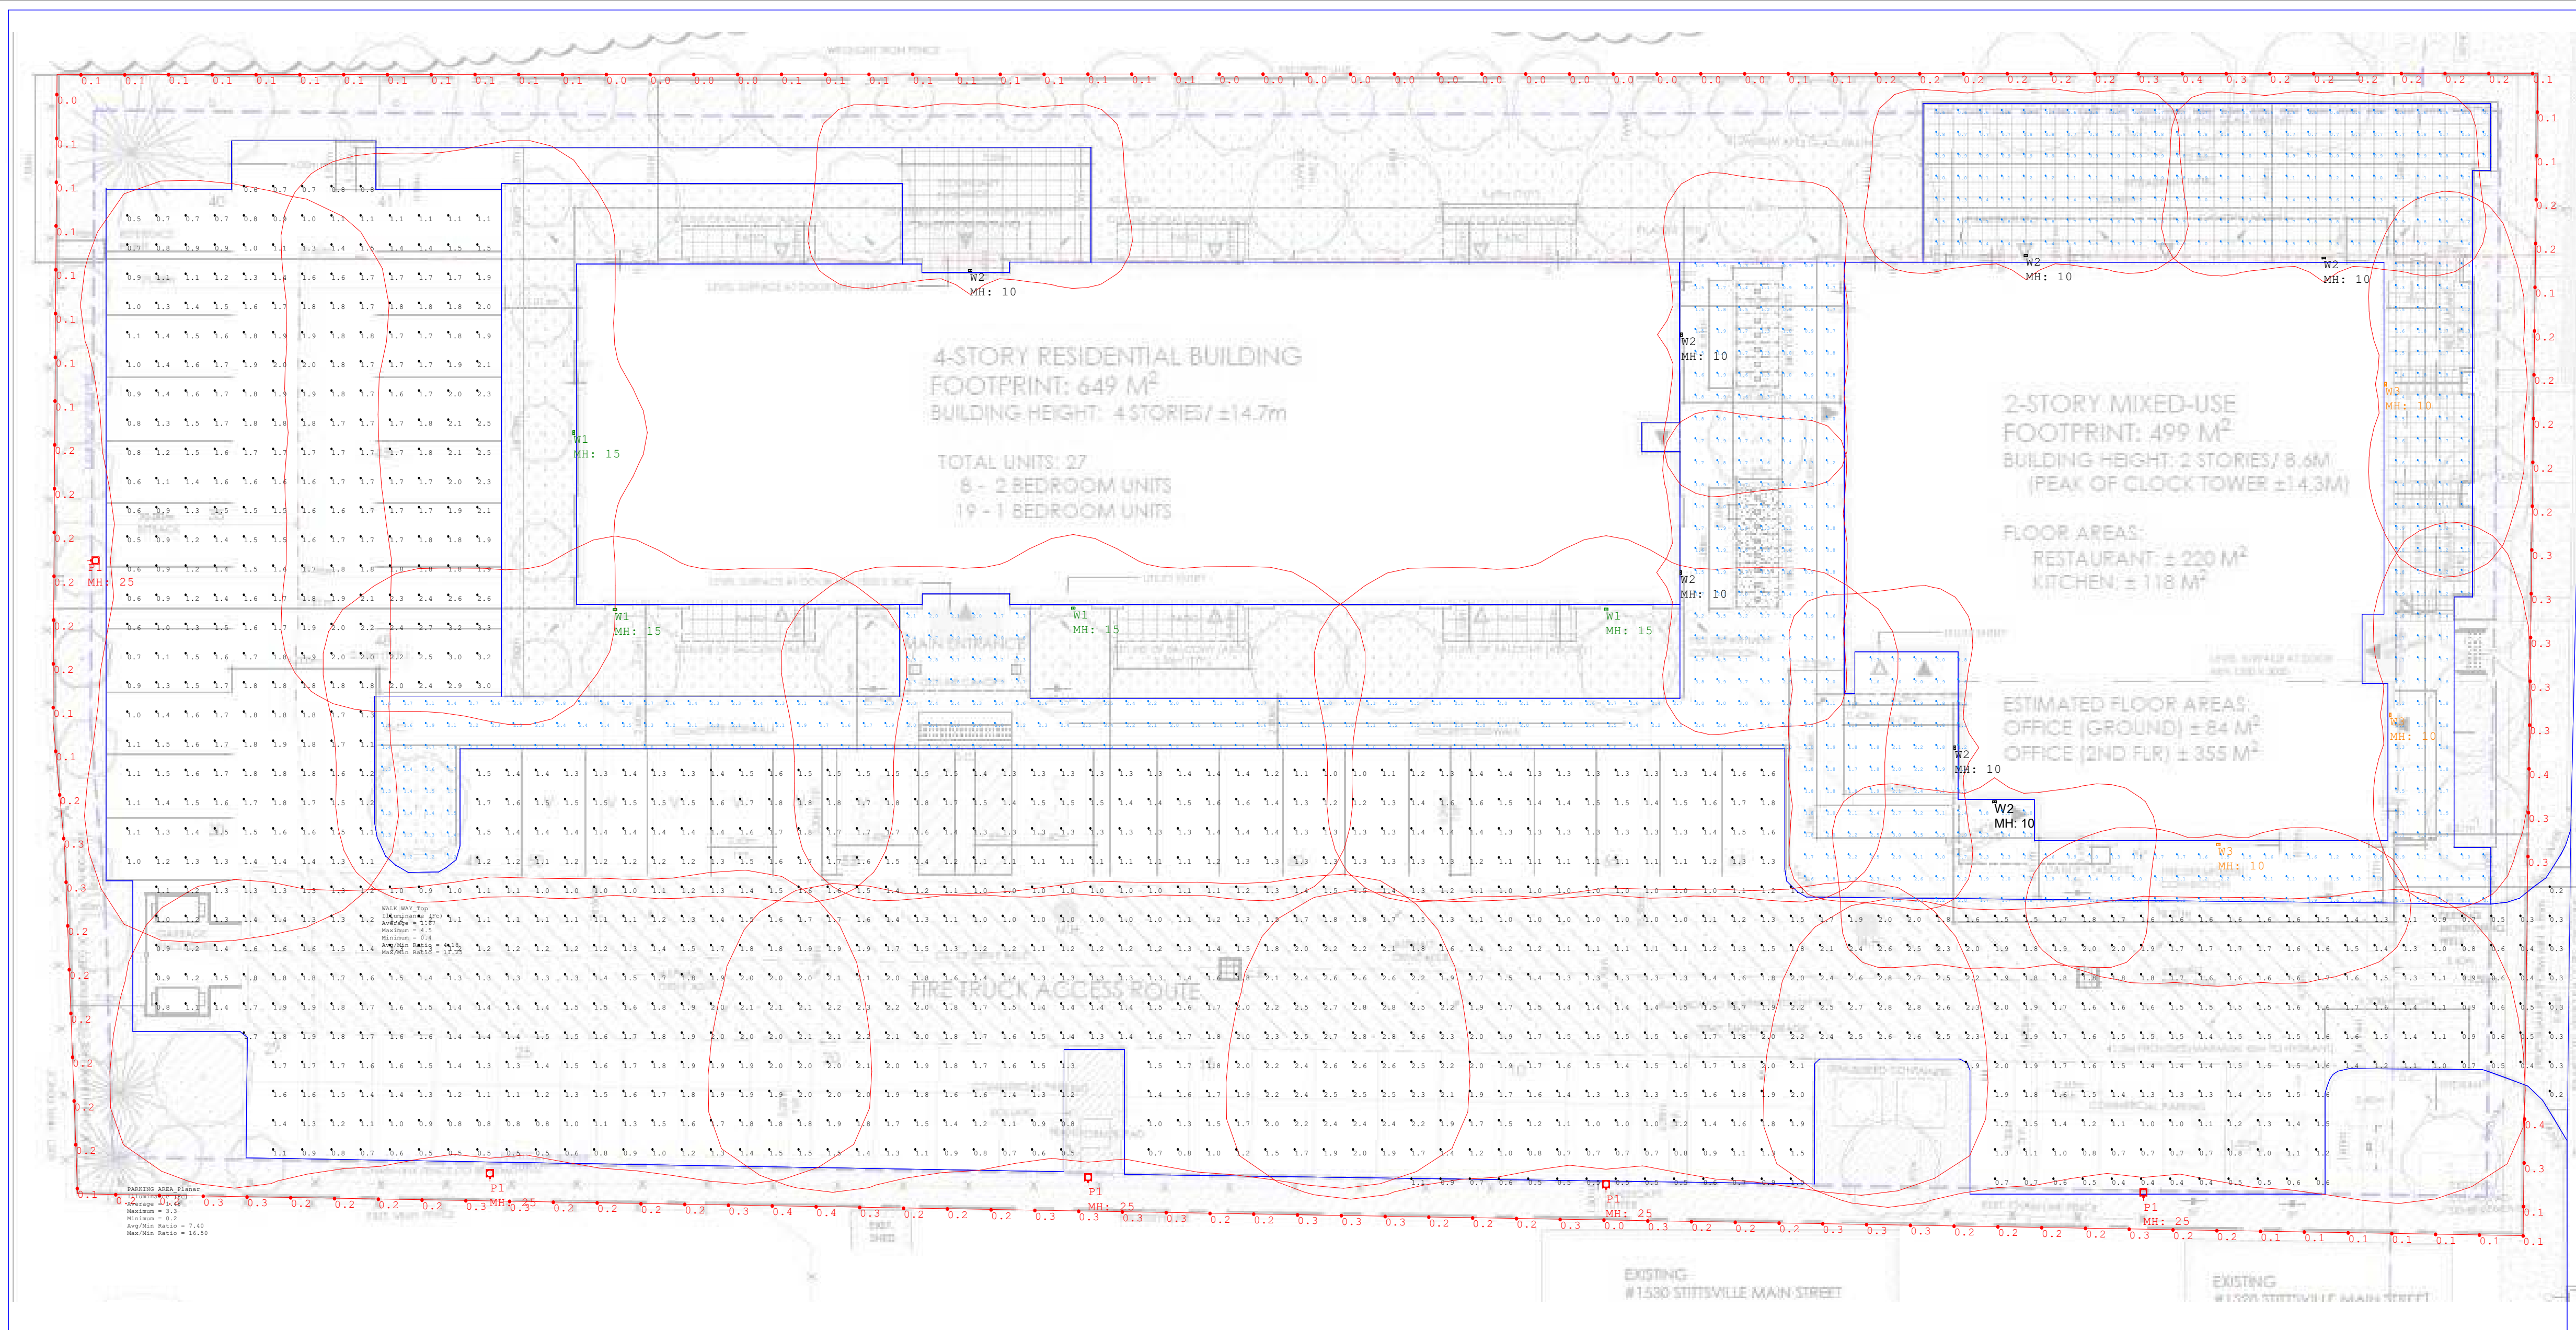

Luminaire Schedule						
Symbol	Qty	Label	Arrangement	LLF	Description	Lum. Lumens
	5	P1	SINGLE	0.900	CURRENT - BEACON - VP-1-160L-75-4K7-4W-BC	5582
	4	W1	SINGLE	0.900	CURRENT - BEACON - RWL1-48L-45-4K7-4W-U	5704
	7	W2	SINGLE	0.900	CURRENT - BEACON - RWL1-48L-10-4K7-4W-U	1336
	3	W3	SINGLE	0.900	CURRENT - BEACON - RWL1-48L-10-3K7-3-U	1303

Calculation Summary						
Label	CalcType	Units	Avg	Max	Min	Avg/Min
PARKING AREA_Planar	Illuminance	Fc	1.48	3.3	0.2	7.40
SPILLAGE	Illuminance	Fc	0.17	0.4	0.0	N.A.
WALK WAY_Top	Illuminance	Fc	1.67	4.5	0.4	4.18

