



LEGEND

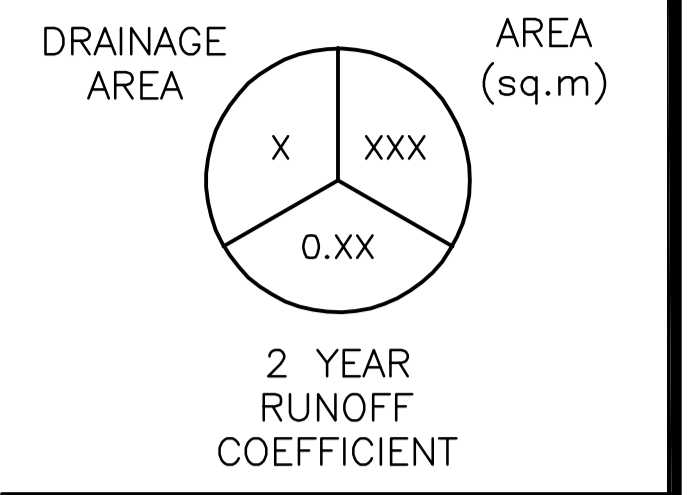

2 YEAR RUNOFF COEFFICIENT

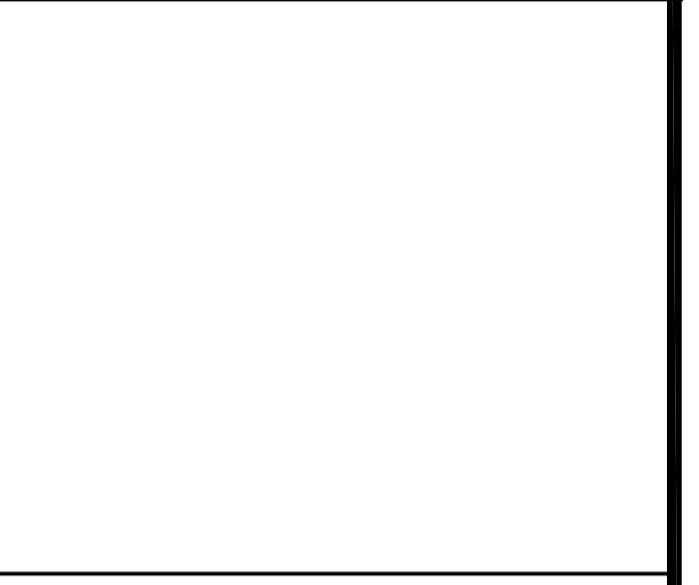

KEY PLAN




| No. | DATE | REVISION |
|-----|-----------|----------------------------|
| 6 | AUG 22-24 | RE-ISSUED FOR APPROVAL |
| 5 | JUL 10-24 | ISSUED FOR BUILDING PERMIT |
| 4 | DEC 13-23 | RE-ISSUED FOR APPROVAL |
| 3 | AUG 31-23 | ISSUED FOR APPROVAL |
| 2 | AUG 16-23 | ISSUED FOR COORDINATION |
| 1 | JUL 17-23 | ISSUED FOR COORDINATION |

D. B. GRAY ENGINEERING INC.
 Stormwater Management - Grading & Drainage - Storm & Sanitary Sewers - Watermain
 700 Long Point Circle 613-425-8044
 Ottawa, Ontario d.gray@dbgrayengineering.com

Project
SUNBELT RENTALS INC. - EQUIPMENT MAINTENANCE FACILITY
 CARP, ONTARIO

Drawing Title
PRE-DEVELOPMENT DRAINAGE PLANS

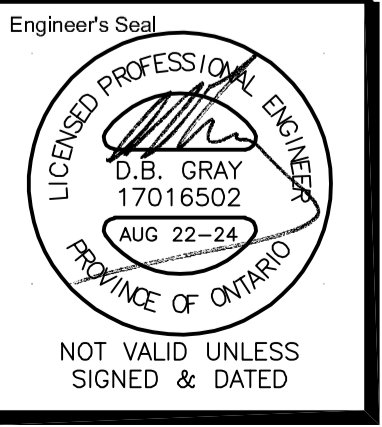

Engineer's Seal
 Drawn D.B.G.
 H. Scale 1:500
 V. Scale
 Date JUL 17-23
 Job No. 22111
 Drawing No.
C-16
 of 17