


LIGHTING FIXTURE SCHEDULE												
TYPE	DESCRIPTION	LAMPS						DIMMING OPTION	VOLT	MOUNTING	REMARKS	
							LUMENS/WATT (LPW)					
A	EXTERIOR BUILDING MOUNTED LIGHT WALL PACK SHALL BE LITHONIA DSXW-1 SERIES.	10	LED	73W	4000K	10,000	134	0-10V	347	BUILDING MOUNT HEIGHT AS SHOWN	- FULL CUT-OFF - BLACK FINISH - 80 CRI - FORWARD THROW MEDIUM DISTRIBUTION - INTEGRAL DRIVER - CONTROLLED BY PHOTOCELL AND TIMECLOCK. CONTROLS TO LOWER EXTERIOR LIGHTING (DW) BY 30% DURING OVERNIGHT OR INACTIVE HOURS	
A1	EXTERIOR BUILDING MOUNTED LIGHT WALL PACK SHALL BE LITHONIA DSXW-1 SERIES.	10	LED	73W	4000K	10,000	134	0-10V	347	BUILDING MOUNT HEIGHT AS SHOWN	- FULL CUT-OFF - BLACK FINISH - 80 CRI - TYPE 4 MEDIUM DISTRIBUTION - INTEGRAL DRIVER - CONTROLLED BY PHOTOCELL AND TIMECLOCK. CONTROLS TO LOWER EXTERIOR LIGHTING (DW) BY 30% DURING OVERNIGHT OR INACTIVE HOURS	

DIMMING NOTES:  
1. 0-10V DENOTES 0-10V DIMMING CONTROL

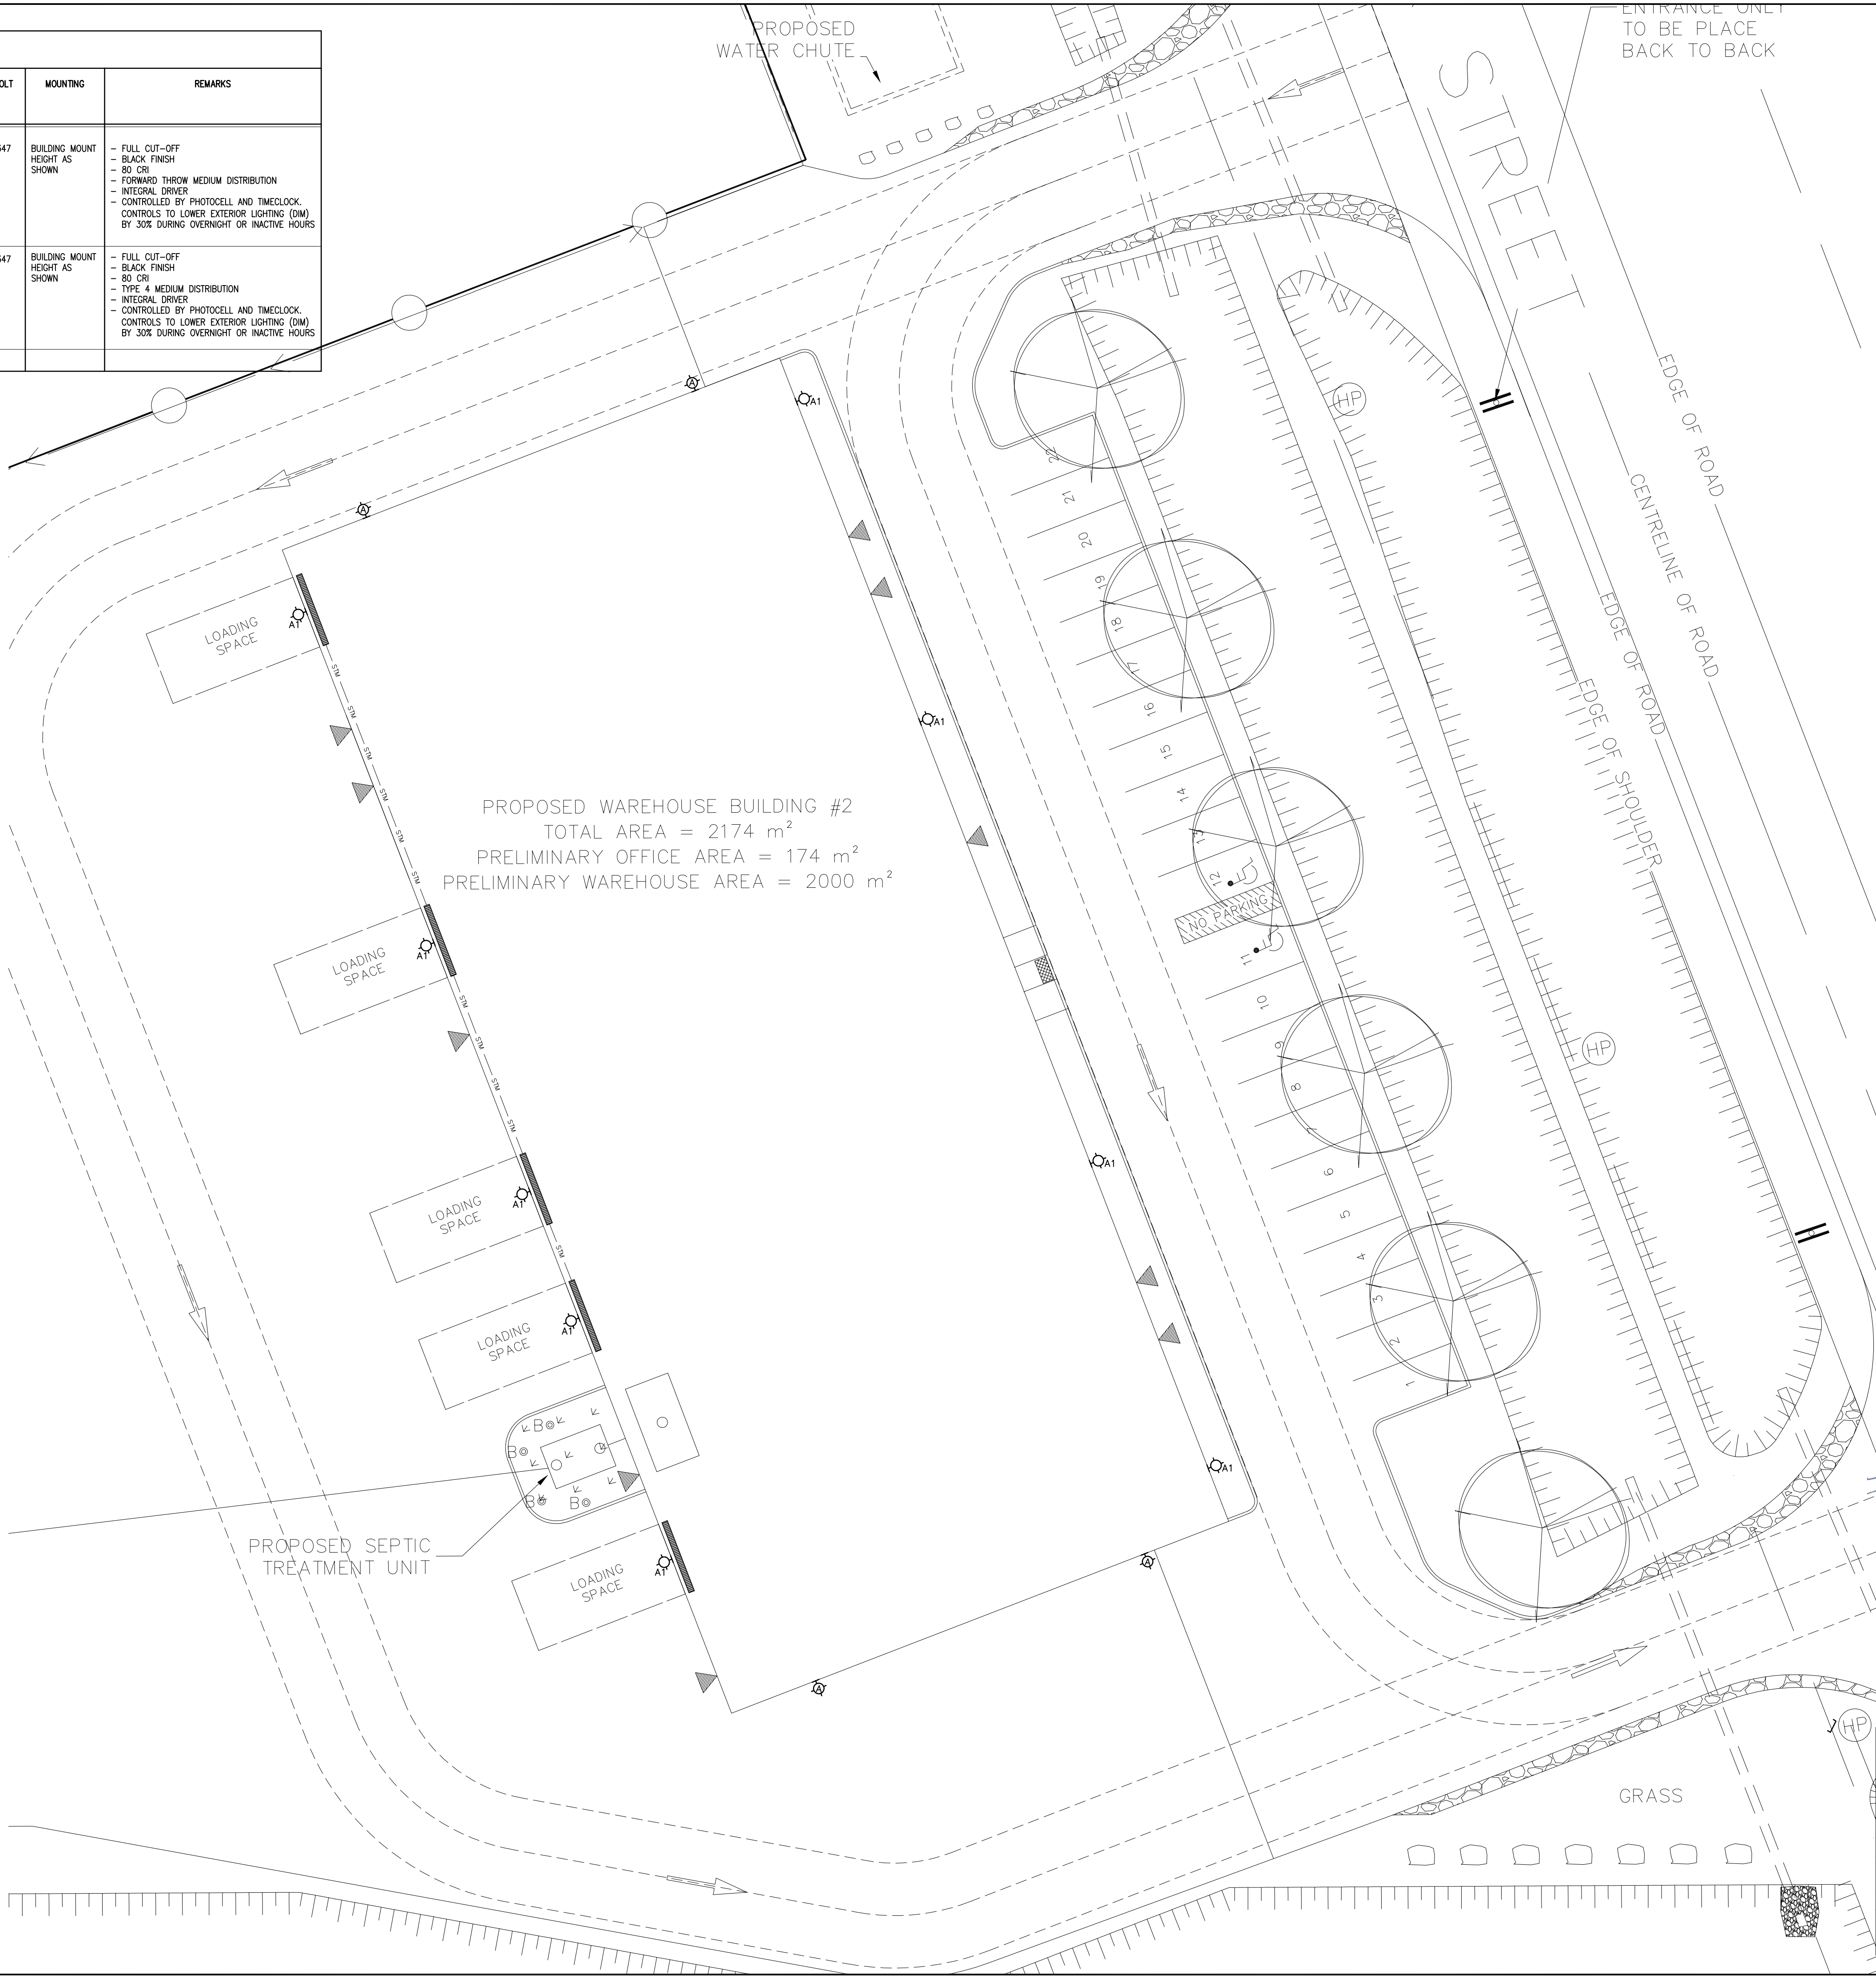

NOTES:

THESE DESIGN DOCUMENTS ARE PREPARED SOLELY FOR THE USE BY THE PARTY WITH WHOM THE DESIGN PROFESSIONAL HAS ENTERED INTO A CONTRACT AND THERE ARE NO REPRESENTATIONS OF ANY KIND MADE BY THE DESIGN PROFESSIONAL TO ANY PARTY WITH WHOM THE DESIGN PROFESSIONAL HAS NOT ENTERED INTO A CONTRACT.

THE PAPER COPY OF THE DRAWINGS ISSUED FOR BUILDING PERMIT AND/OR TENDER WILL TAKE PRECEDENCE OVER ELECTRONIC COPIES.

THE ENGINEER WAIVES ANY AND ALL RESPONSIBILITY AND LIABILITY FOR PROBLEMS THAT ARISE FROM FAILURE TO FOLLOW THESE PLANS, SPECIFICATIONS AND THE DESIGN INTENT THEY CONVEY, OR FOR PROBLEMS WHICH ARISE FROM OTHER FAILURE TO OBTAIN AND / OR FOLLOW ENGINEER'S GUIDANCE WITH RESPECT TO ANY ERRORS, OMISSIONS, INCONSISTENCIES, AMBIGUITIES OR CONFLICTS WHICH ARE ALLEGED.

THIS DRAWING IS THE PROPERTY OF 4C ENG AND ALL COPYRIGHTS ARE RESERVED. NO USE OF THIS DRAWING MAY BE MADE WITHOUT EXPRESS WRITTEN CONSENT.

DO NOT SCALE DRAWINGS.

4C

4C ENG  
MECHANICAL AND  
ELECTRICAL ENGINEERS  
OTTAWA, ON  
ADMIN@4CENG.CA  
(613)417-2853

2.	RE-ISSUED FOR SITE PLAN APPLICATION	APR 23/25
1.	ISSUED FOR SITE PLAN APPLICATION	MAR 3/25
REV:	DESCRIPTION:	DATE:

STAMP  
PROFESSIONAL ENGINEER  
A. SALAH  
100072517  
2025-04-23  
PROVINCE OF ONTARIO

PROJECT NORTH

PROJECT:  
Camm Heavy Machinery  
Movers Ltd., 6622 Bank St,  
Ottawa, Ontario

DRAWING: ELECTRICAL: SITE PLAN LIGHTING			
DATE: FEB 2025	DRAWN: J.N.	DESIGNED: J.N.	CHECKED: A.S.
SCALE: AS SHOWN	DRAWING NO: E-2		
PROJECT NO: 25001	OF 6		

1  
E-2

SITE PLAN LIGHTING  
1/16" = 1'-0"