


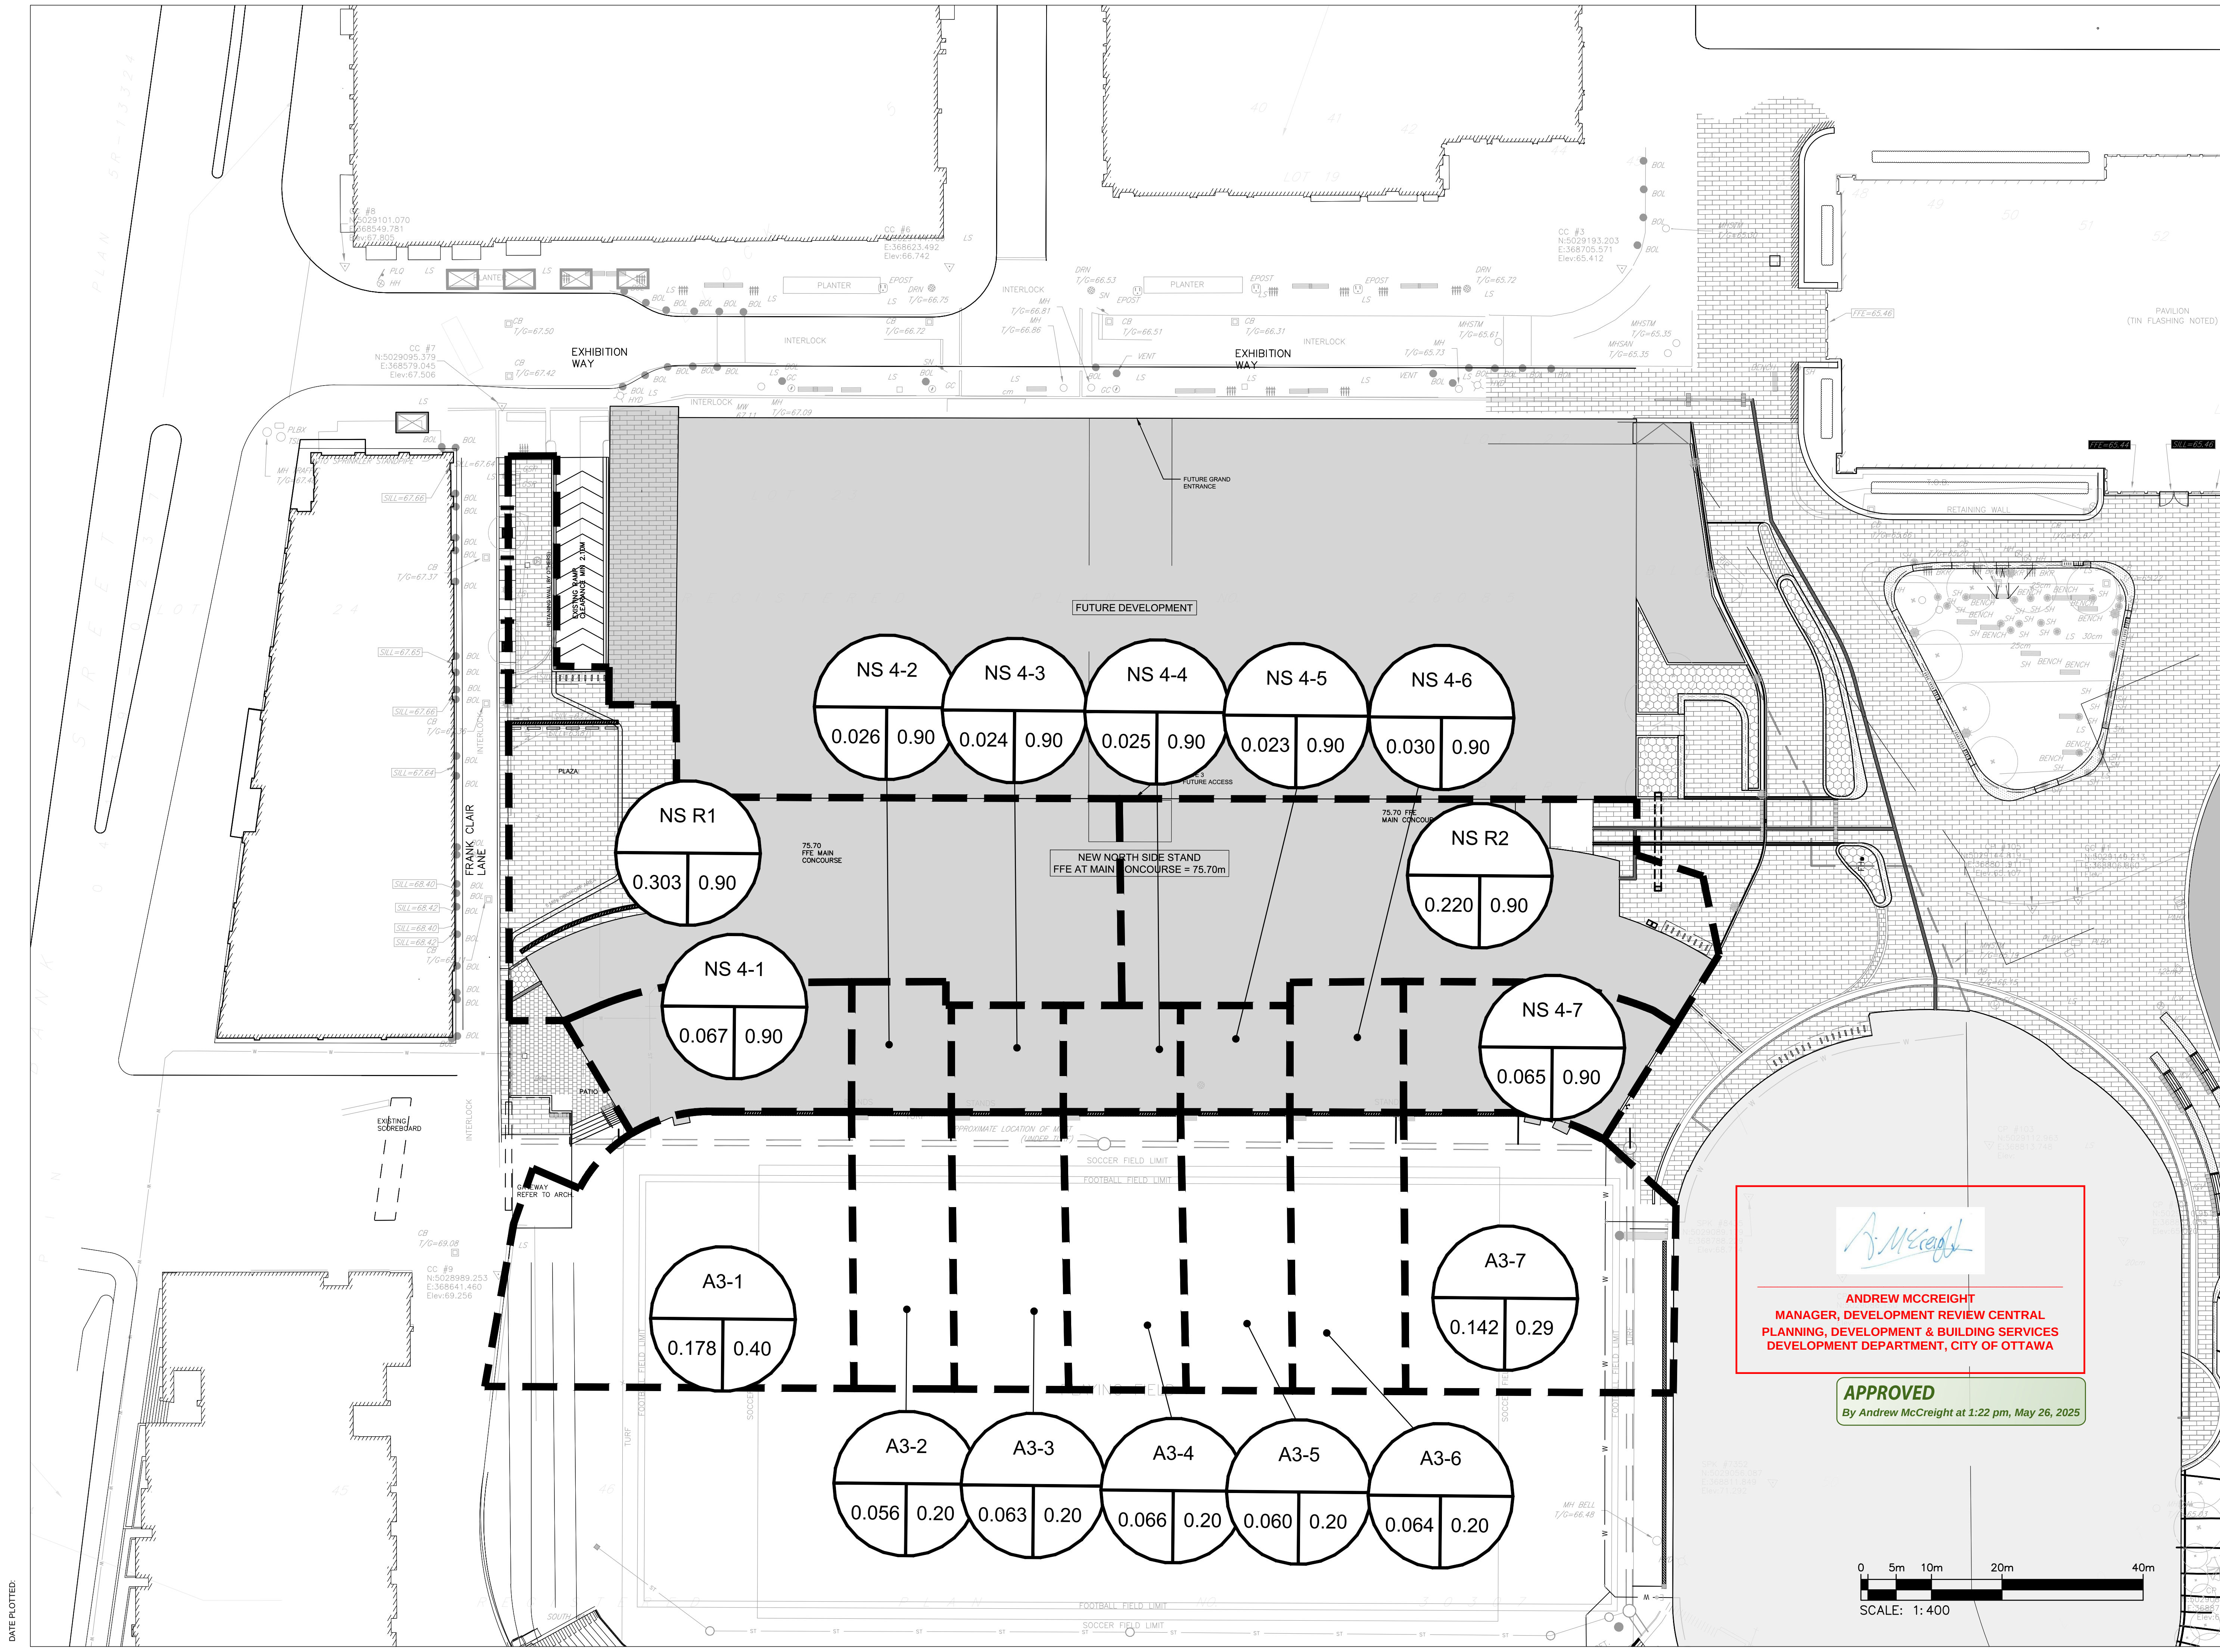

135 LAURIER AVE WEST, SUITE 413
OTTAWA, ON K1P 5J2
(343) 308-9274

STRUCTURAL ENGINEER

200 KING, ST. WEST, SUITE 310
TORONTO, ON M5H 3T4
(416) 499-8000
MECH. PLUMB. FIRE PROTECTION ENGINEER

MULVEY & BANANI

90 SHEPPARD AVE EAST, SUITE 500
TORONTO, ON M2N 3A
(416) 751-2520

ELEC. LIGHTING ENGINEER

S2O

530 N. WOOD STREET #C
CHICAGO, IL 60622
(224) 717-1999

FOOD AND BEVERAGE

CSW

319 MCRAE AVENUE, SUITE 502
OTTAWA, ONTARIO K1Z 0B9
(613) 729-4536

LANDSCAPE ARCHITECT

wsp

2011 QUEENSVIEW DR.
OTTAWA, ONTARIO K2B 8K2
(613) 829-2800

CIVIL ENGINEER

NO.	DESCRIPTION	DATE
4	REVISED PER CITY DEFICIENCY COMMENTS	2025-01-22
3	ISSUED FOR CD UPDATE	2025-01-17
2	ISSUED FOR SITE PLAN APPLICATION	2024-11-20
1	ISSUED FOR LDRP	2024-11-19

REVISIONS/ ISSUES

CONTRACTOR SHALL CHECK AND VERIFY ALL DIMENSIONS AND REPORT ANY OMISSIONS OR DISCREPANCIES TO THE ARCHITECT BEFORE PROCEEDING WITH THE WORK. DO NOT SCALE THE DRAWINGS

SEAL

DRAWN J.T
DATE 2025/01/22
CHECKED W.Y

LANDSDOWNE NSS

DWG. TITLE
POST DRAINAGE AREA PLAN

SCALE 1:400
PROJ. NO. CA0043476.7969

DWG. NO. C06

DATE PLOTTED

07-12-24-0178

#19220