



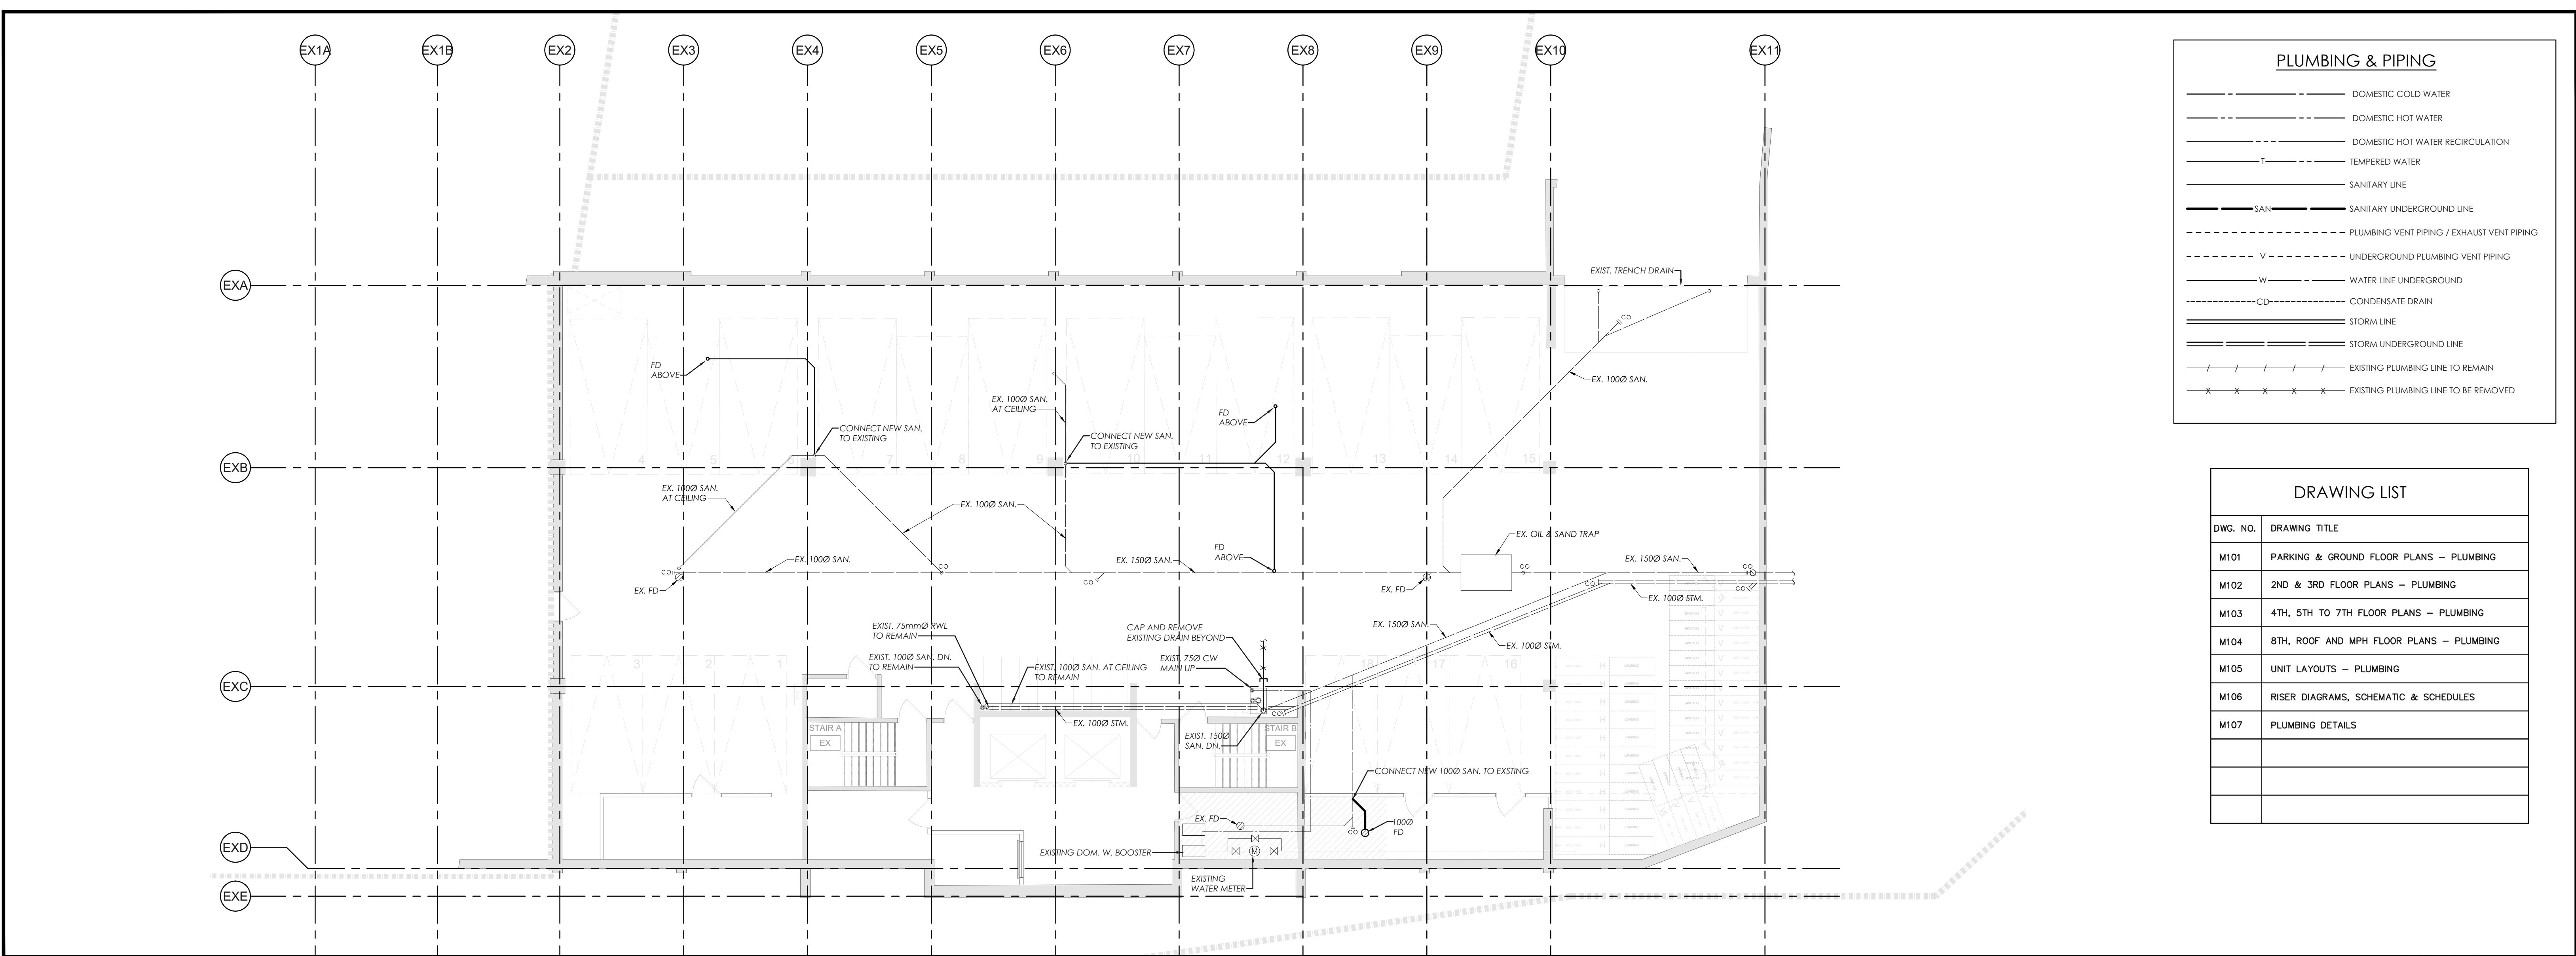

1 PARKING LEVEL FLOOR PLAN - PHASE 1
M101
SCALE = 1:100

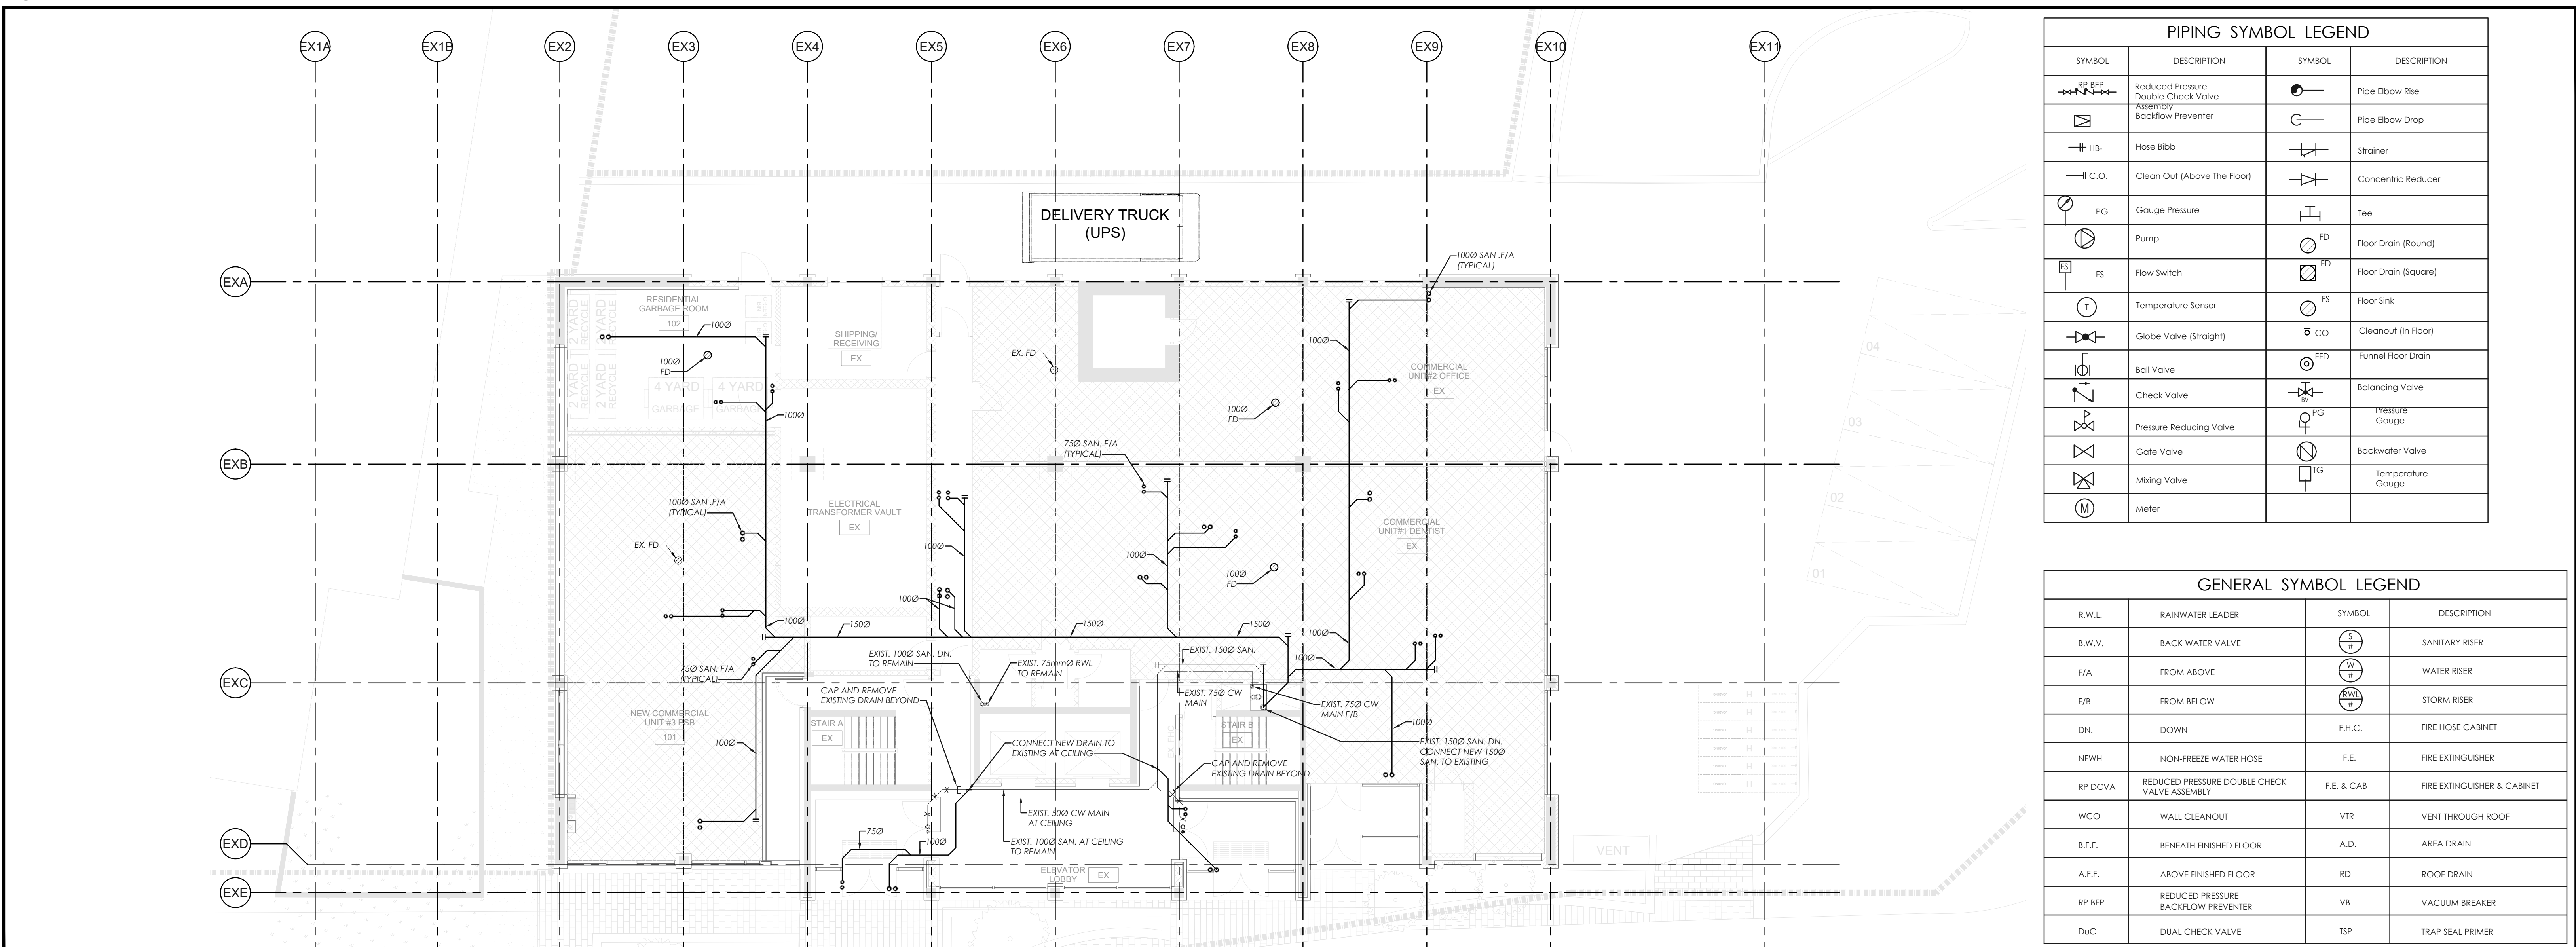

2 GROUND FLOOR PLAN - PHASE 1
M101
SCALE = 1:100

IT IS THE RESPONSIBILITY OF THE APPROPRIATE CONTRACTOR TO CHECK AND VERIFY ALL DIMENSIONS ON SITE AND TO REPORT ALL ERRORS AND/OR OMISSIONS TO THE ARCHITECT.
ALL CONTRACTORS MUST COMPLY WITH ALL PERTINENT CODES AND BY-LAWS.
THIS DRAWING MAY NOT BE USED FOR CONSTRUCTION UNTIL SIGNED BY THE ARCHITECT.
DO NOT SCALE DRAWINGS.
COPYRIGHT RESERVED.

DWG. NO.	DRAWING TITLE
M101	PARKING & GROUND FLOOR PLANS - PLUMBING
M102	2ND & 3RD FLOOR PLANS - PLUMBING
M103	4TH, 5TH TO 7TH FLOOR PLANS - PLUMBING
M104	8TH, ROOF AND MPH FLOOR PLANS - PLUMBING
M105	UNIT LAYOUTS - PLUMBING
M106	RISER DIAGRAMS, SCHEMATIC & SCHEDULES
M107	PLUMBING DETAILS

DWG. NO.	DRAWING TITLE
M101	PARKING & GROUND FLOOR PLANS - PLUMBING
M102	2ND & 3RD FLOOR PLANS - PLUMBING
M103	4TH, 5TH TO 7TH FLOOR PLANS - PLUMBING
M104	8TH, ROOF AND MPH FLOOR PLANS - PLUMBING
M105	UNIT LAYOUTS - PLUMBING
M106	RISER DIAGRAMS, SCHEMATIC & SCHEDULES
M107	PLUMBING DETAILS

1	ISSUED FOR REVIEW	Aug 27, 24
No.	DESCRIPTION	DATE
1	ISSUED FOR REVIEW	Aug 27, 24

ARCHITECT SEAL:	NORTH ARROW:
SEAL DATE: STAMP DATE	DATE
CLIENT:	

ARCHITECT:

PROJECT TITLE:
265 CARLING AVENUE
SHEET TITLE:
PARKING & GROUND FLOOR PLANS PLUMBING

DRAWN:	CHECKED:
SCALE: 1:100	SHEET No.
PROJECT No.	M101