
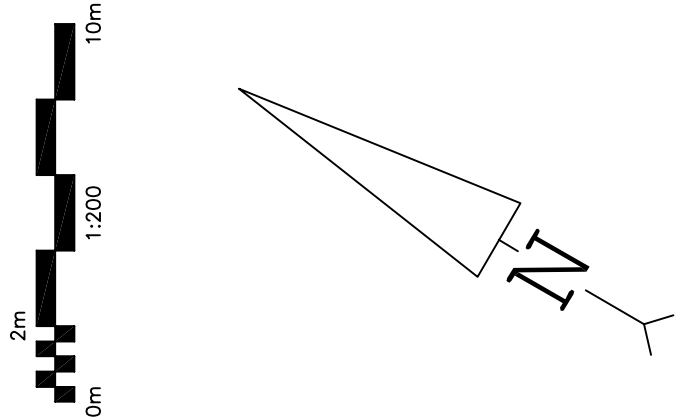


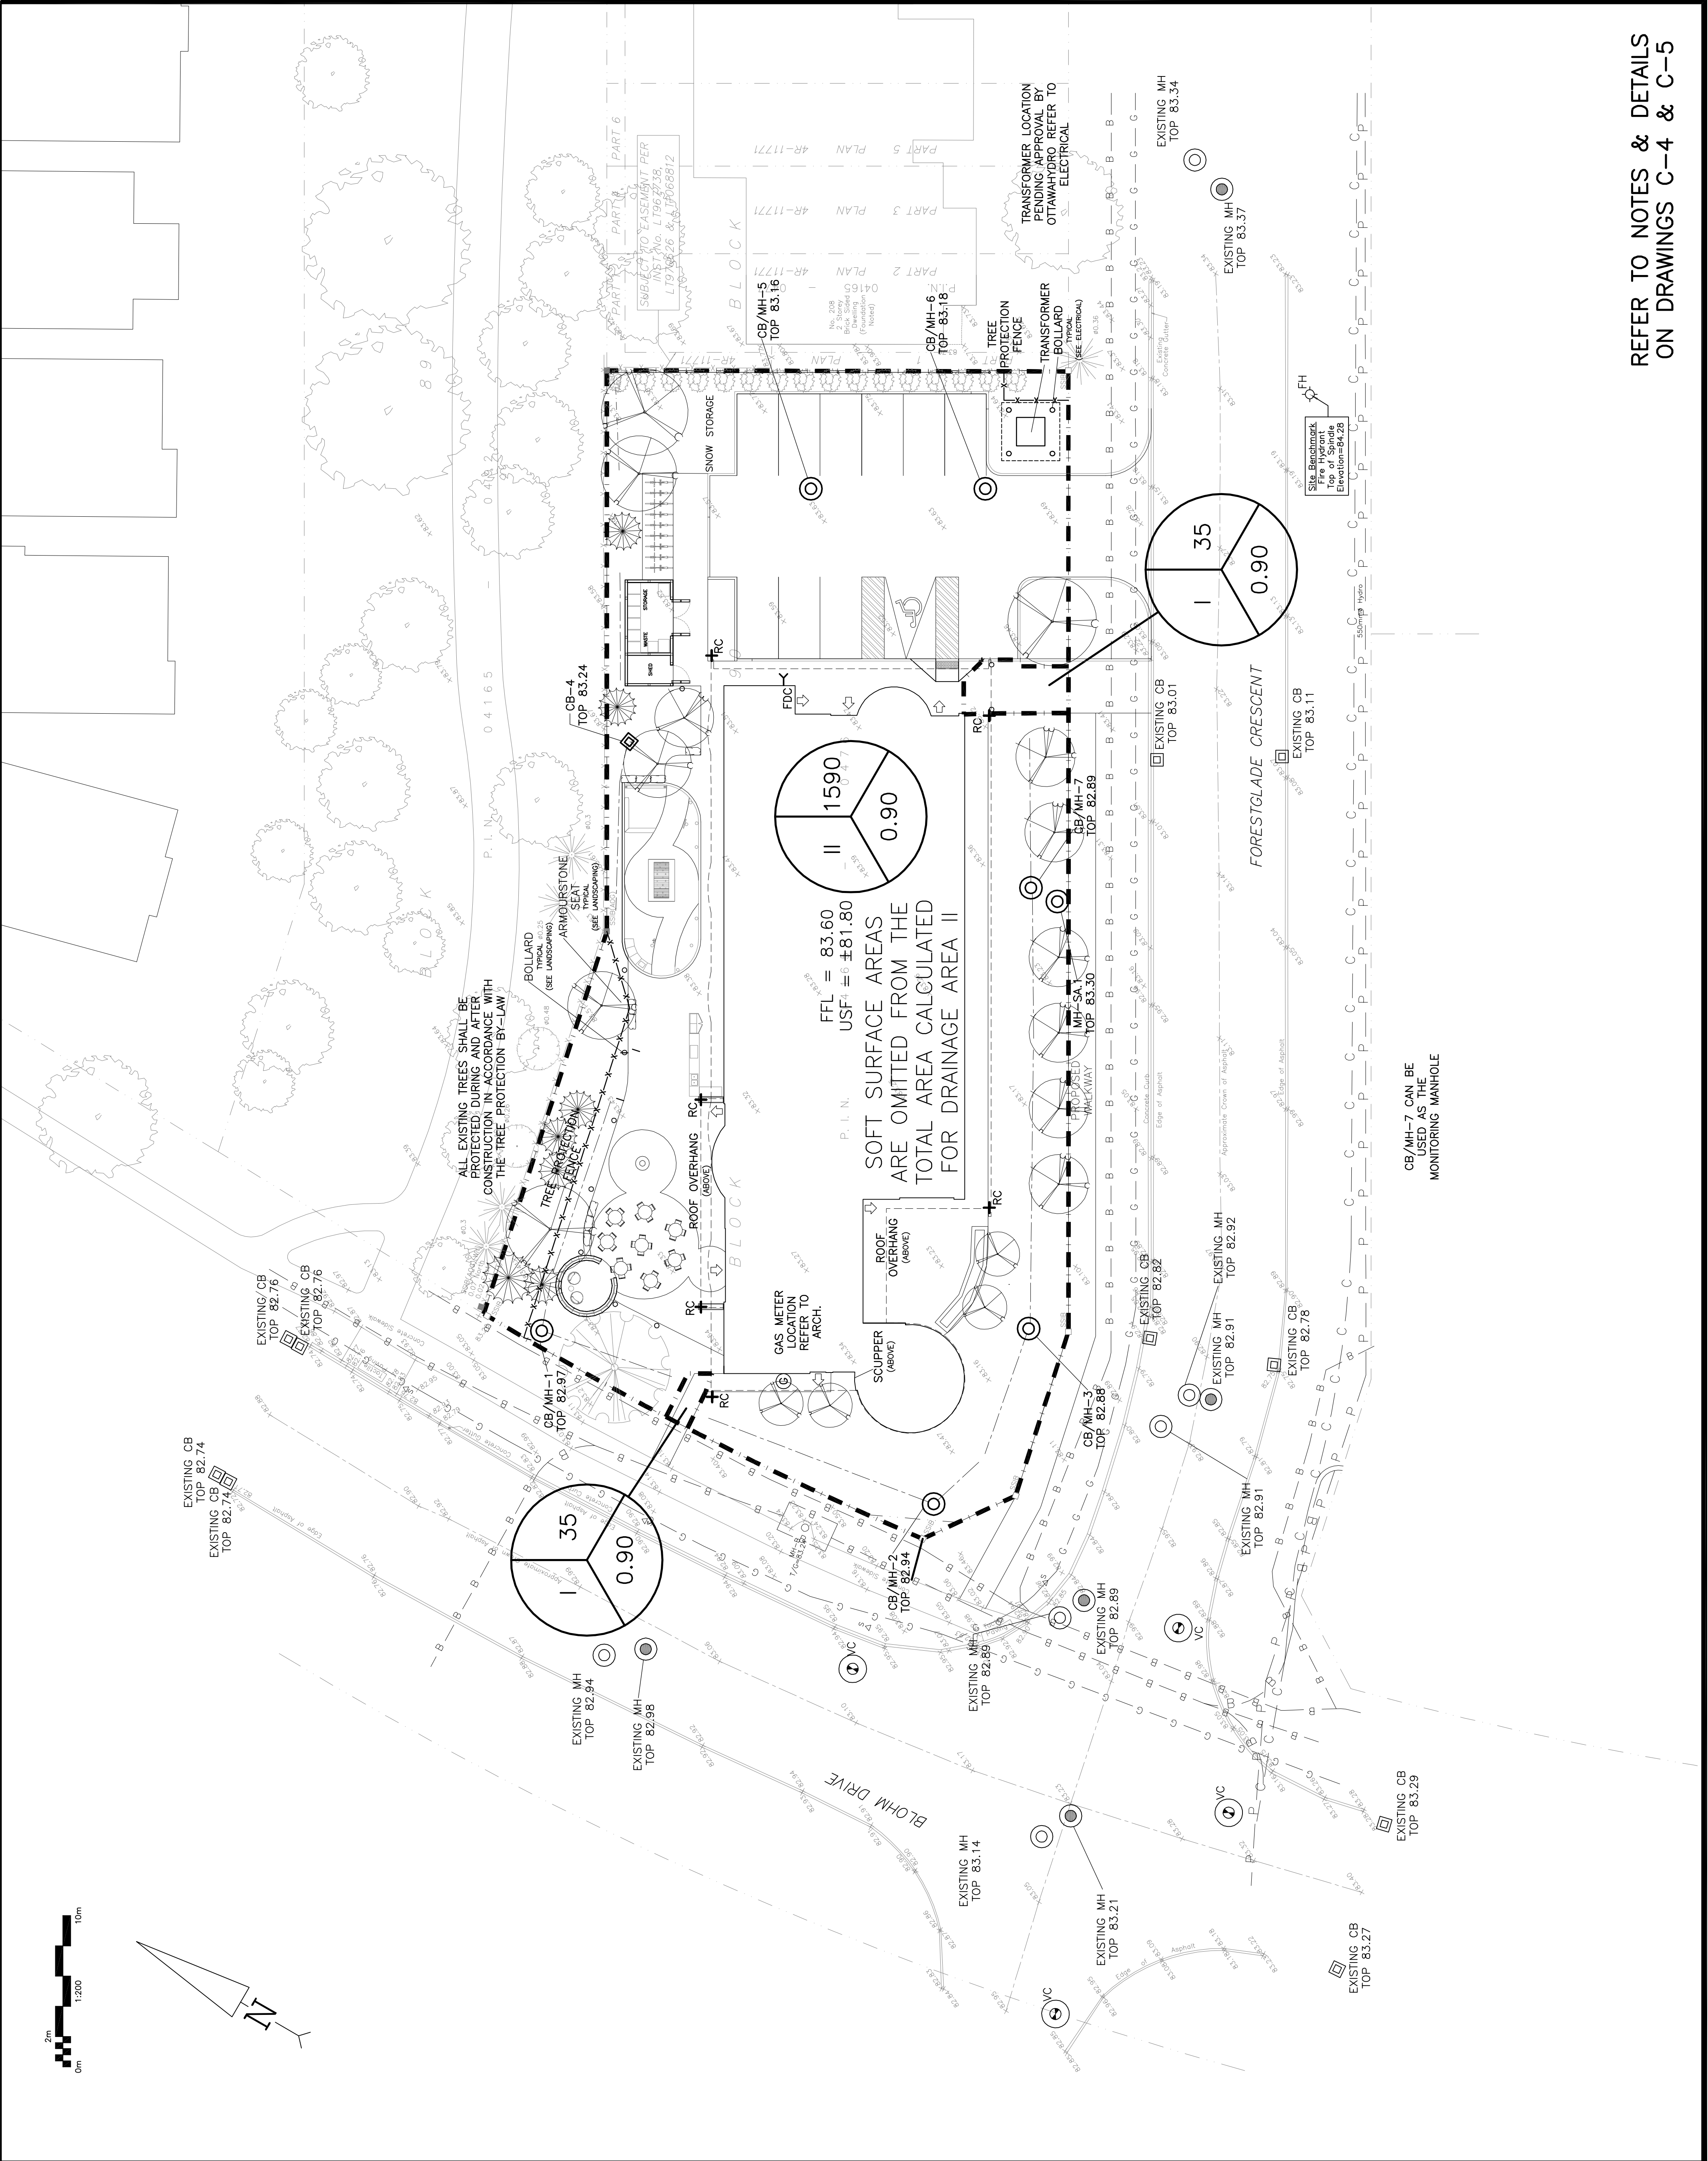

LEGEND

DRAINAGE AREA

AREA (sq.m)

X

XXX

0.XX

5 YEAR RUNOFF COEFFICIENT

KEY PLAN

5	MAY 7-25	RE-ISSUED FOR SITE PLAN CONTROL							
4	APR 4-25	ISSUED FOR SITE PLAN CONTROL							
3	APR 2-25	ISSUED FOR COORDINATION							
2	FEB 21-25	ISSUED FOR CLASH B COSTING							
1	FEB 14-25	ISSUED FOR COORDINATION							
No.	DATE	REVISION							

D. B. GRAY ENGINEERING INC.
Stormwater Management Grading & Drainage Snow & Safety Services Professional
7000 Long Point Circle
Ottawa, Ontario
d.gray@dbgrayengineering.com
613-425-8044

Project
**PROPOSED 3-STORY
OAC WOMEN'S SHELTER
250 FORESTGLADE
CRESCENT**
OTTAWA, ONTARIO

Drawing Title
**POST DEVELOPMENT
DRAINAGE PLAN**

Engineer's Seal

Drawn D.B.G.

H. Scale 1:200

V. Scale

Date FEB 14-25

Job No. 24053

Drawing No.

C-7

of 7

NOT VALID UNLESS
SIGNED & DATED

REFER TO NOTES & DETAILS
ON DRAWINGS C-4 & C-5