
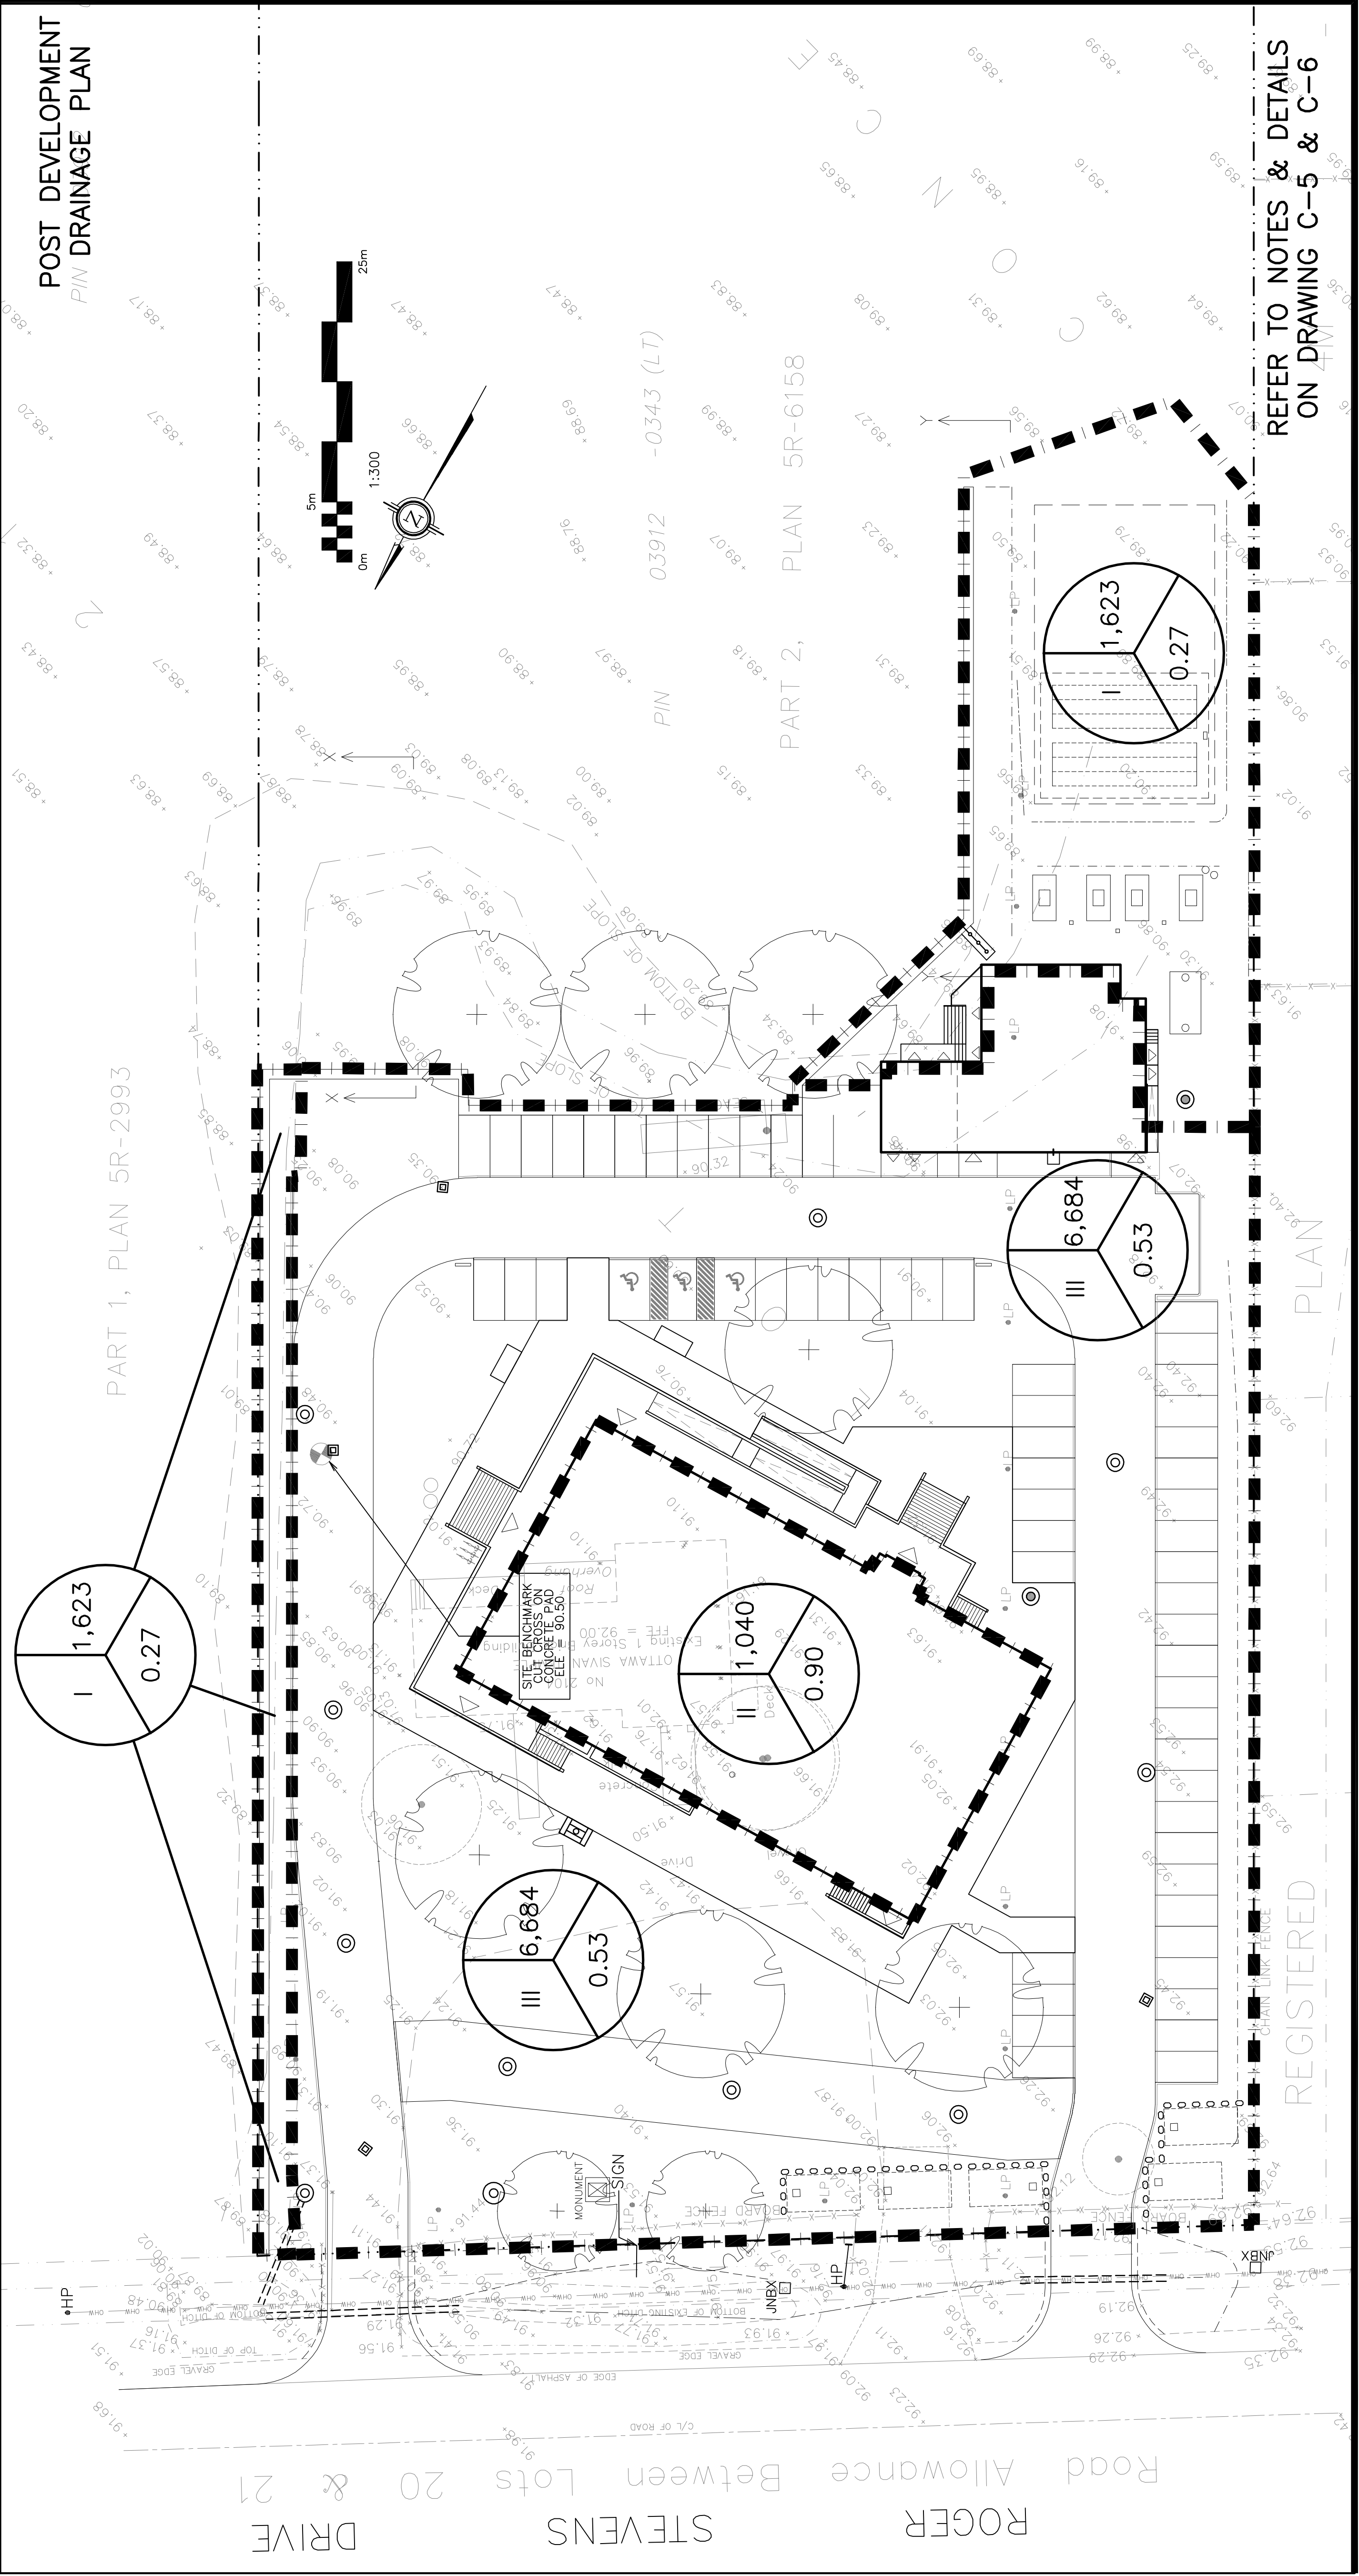


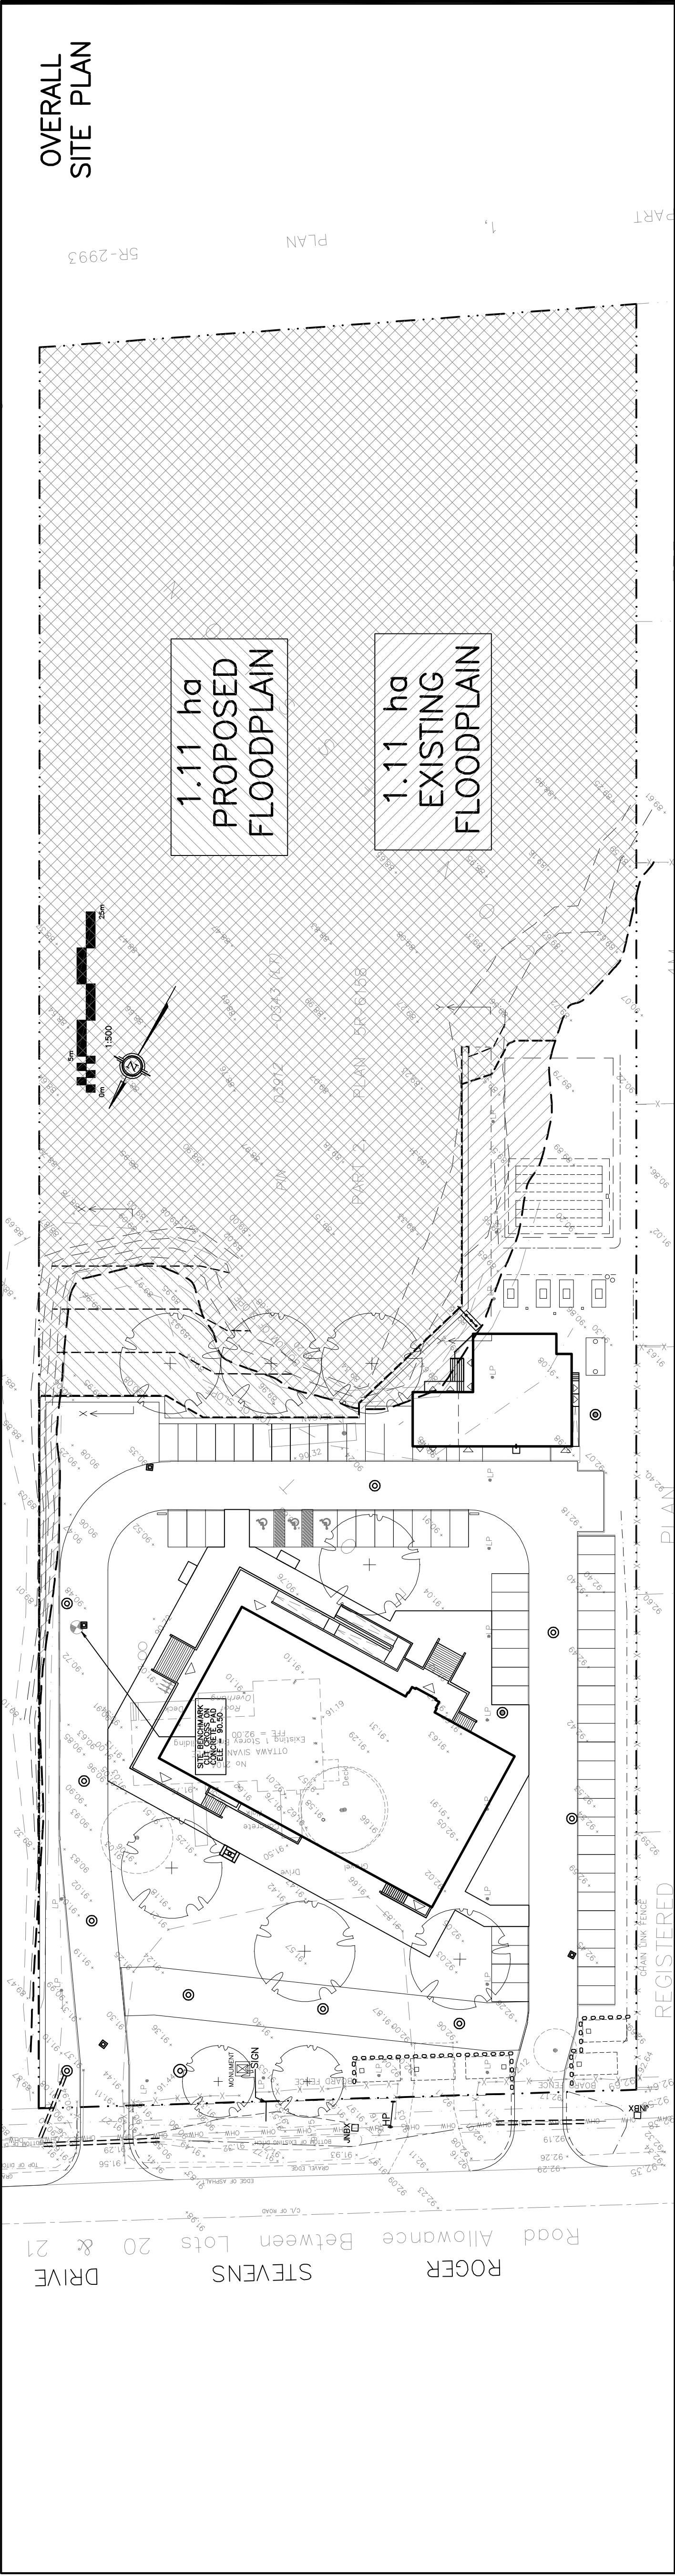

LEGEND

DRAINAGE AREA

AREA (sq.m)

X XXX

0.XX

5 YEAR RUNOFF COEFFICIENT

KEY PLAN

SITE

TRAILWOOD DR

5R-2993

No.	DATE	REVISION
1	JUL 11-24	PRELIMINARY
2	AUG 6-24	ISSUED FOR COORDINATION
3	SEP 20-24	ISSUED FOR COORDINATION
4	OCT 15-24	ISSUED FOR COORDINATION
5	OCT 18-24	ISSUED FOR COORDINATION
6	OCT 25-24	ISSUED FOR APPROVAL
7	APR 10-25	RE-ISSUED FOR APPROVAL
8	JUN 12-25	RE-ISSUED FOR APPROVAL & BUILDING PERMIT FOR PRIEST RESIDENCE

D.B. GRAY ENGINEERING INC.

Stormwater Management Consulting & Engineering • Storm & Sanitary Services • Professionals

7000 Long Point Circle

Ottawa, Ontario

d.gray@dbgrayengineering.com

613-425-8044

Project

PROPOSED HINDU TEMPLE

2104 ROGER STEVENS DR

NORTH GOWER, ONTARIO

Drawing Title

OVERALL SITE PLAN & POST DEVELOPMENT DRAINAGE PLAN

Engineer's Seal

D.B.G.

Drawn

H. Scale

V. Scale

Date

JUL 11-24

Job No.

20079

LICENSED PROFESSIONAL ENGINEER

116,166

116,166

JUN 12-24

PROVINCE OF ONTARIO

Drawing No.

C-7

of 7

NOT VALID UNLESS SIGNED & DATED