

PROPERTY LINE
JOINT UTILITY TRENCH
COMMUNICATIONS TRENCH
HYDRO SECONDARY
GAS MAIN
STREETLIGHT CABLE AND DUCT
1 PHASE PADMOUNT HYDRO TRANSFORMER
HYDRO PRIMARY PEDESTAL
6x12 PRECAST MANHOLE
STREETLIGHT
STREETLIGHT DISCONNECT
PROPOSED STREETLIGHT GROUNDING ROD

UTILITY POLE

ROGERS PEDESTAL

ROGERS GRADE LEVEL BOX

BELL PEDESTAL

BELL CENTRAL SPLIT POINT

BELL GRADE LEVEL BOX

PROPOSED ROAD CROSSING

2 STREET LIGHT

7 HYDRO

1 ROGERS

1 BELL

1 GAS

DEPRESSED CURB

COMMUNITY MAILBOX


	HYDRO METER BOX LOCATION
	HYDRO GANG METER LOCATION
	GAS METER BOX LOCATION
	PROPOSED HYDRANT LOCATION
	PROPOSED ROAD CATCHBASIN
	PROPOSED REARYARD CATCHBASIN
	PROPOSED SANITARY MANHOLE
	PROPOSED STORM MANHOLE
	SERVICE LOCATION

	PROPOSED DECIDUOUS TREE
	PROPOSED SIDEWALK REINSTATEMENT
	DRAINAGE EASEMENT
	UTILITY EASEMENT
	EXISTING TREE TO REMAIN IF POSSIBLE
	PROPOSED OVERLAY

COMPOSITE UTILITY PLAN TO BE READ IN
CONJUNCTION WITH:

- HYDRO OTTAWA PLANS, REF NO. XXX
- BELL PLANS, REF NO. XXX
- ROGERS PLANS, REF NO. XXX
- ENBRIDGE PLANS, REF NO. XXX
- STREETLIGHTING PLAN, 118224-SL
- LANDSCAPE PLANS,


ALL FOOTPRINTS SHOWN ARE CONCEPTUAL. REFER TO INDIVIDUAL SITING PLANS FOR FINAL MODEL FOOTPRINT

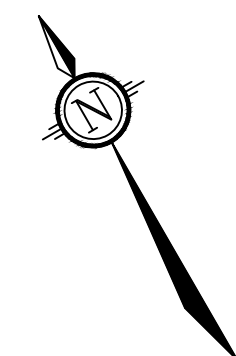

NORTH

KEY PL
N.T.S.

SITE BENCHMARK
REFERENCED TO LOCAL
GEODETIC DATUM

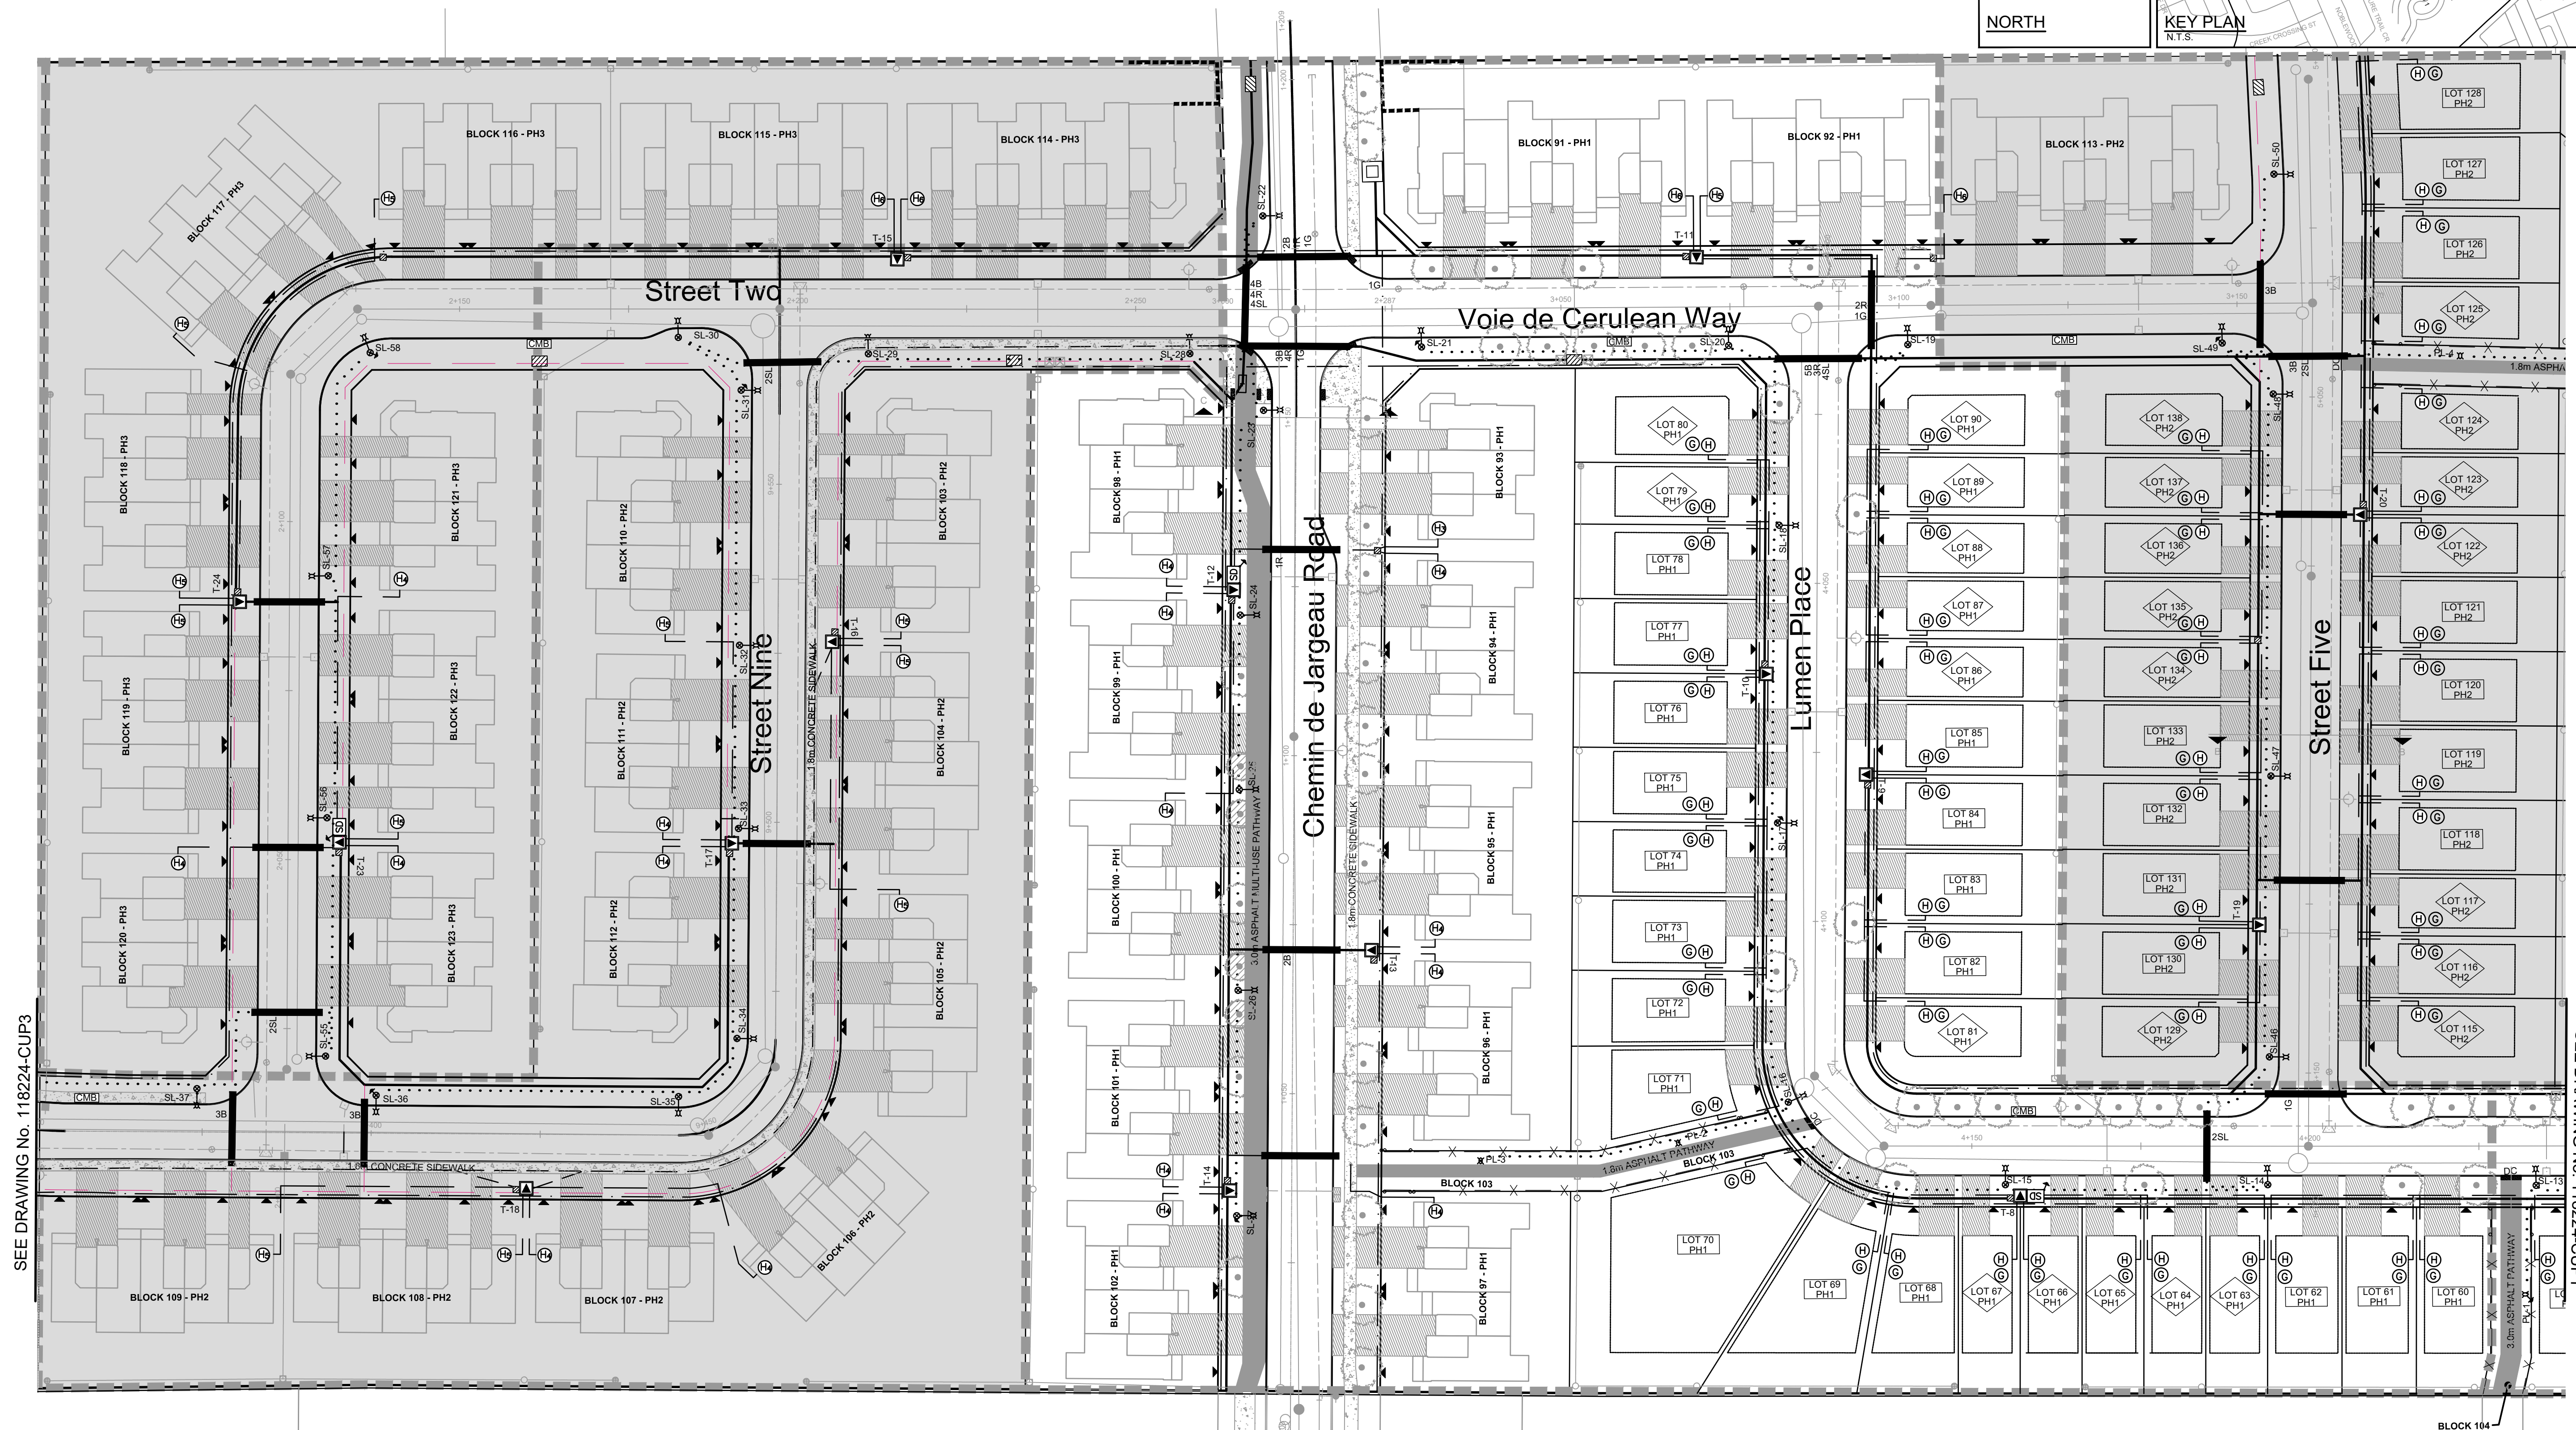

NOTE:
THE POSITION OF ALL POLE LINES, CONDUITS,
WATERMANS, SEWERS AND OTHER
UNDERGROUND AND OVERGROUND UTILITIES AND
STRUCTURES IS NOT NECESSARILY SHOWN ON
THE CONTRACT DRAWINGS, AND WHERE SHOWN,
THE ACCURACY OF THE POSITION OF SUCH
UTILITIES AND STRUCTURES IS NOT GUARANTEED.
BEFORE STARTING WORK, DETERMINE THE EXACT
LOCATION OF ALL SUCH UTILITIES AND
STRUCTURES AND ASSUME ALL LIABILITY FOR
DAMAGE TO THEM.

PRELIMINARY


REFER TO 118224-XS1 AND 118224-XS2 FOR TYPICAL ROAD CROSS SECTIONS

REFER TO 118224-ND FOR ADDITIONAL NOTES & DETAILS

2.	REVISED AND REISSUED FOR REVIEW	NOV 26/21	BH	
1.	ISSUED FOR REVIEW	JUNE 18/21	BH	
No.	REVISION	DATE	BY	

SCALE

 1:500



DESIGN


CHECKED

[illegible][illegible]

CHECKED

APPROVE

FOR REVIEW ONLY

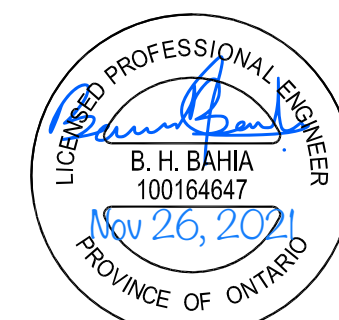

NOVATECH
Engineers, Planners & Landscape Architects
Suite 200, 240 Michael Cowpland Drive
Ottawa, Ontario, Canada K2M 1P6
Telephone (613) 254-9642
Facsimile (613) 254-5862
Website www.novatech-eng.com

LOCATION
CITY OF OTTAWA
THE COMMONS

DRAWING NAME

COMPOSITE UTILITY PLAN

PROJECT No.	118224-00
REV	REV # 2
DRAWING No.	118224-CUP2

\\temp\AcPublish 2024\118224-CUP.dwg, 118224-CUP2, Nov 17, 2021 - 4:45pm, breed

PLANA1.DWG - 841mmx594mm

SEE DRAWING NO. 118224-CUP1

#18535

0	2	2	D07-16-19-0027
---	---	---	----------------