

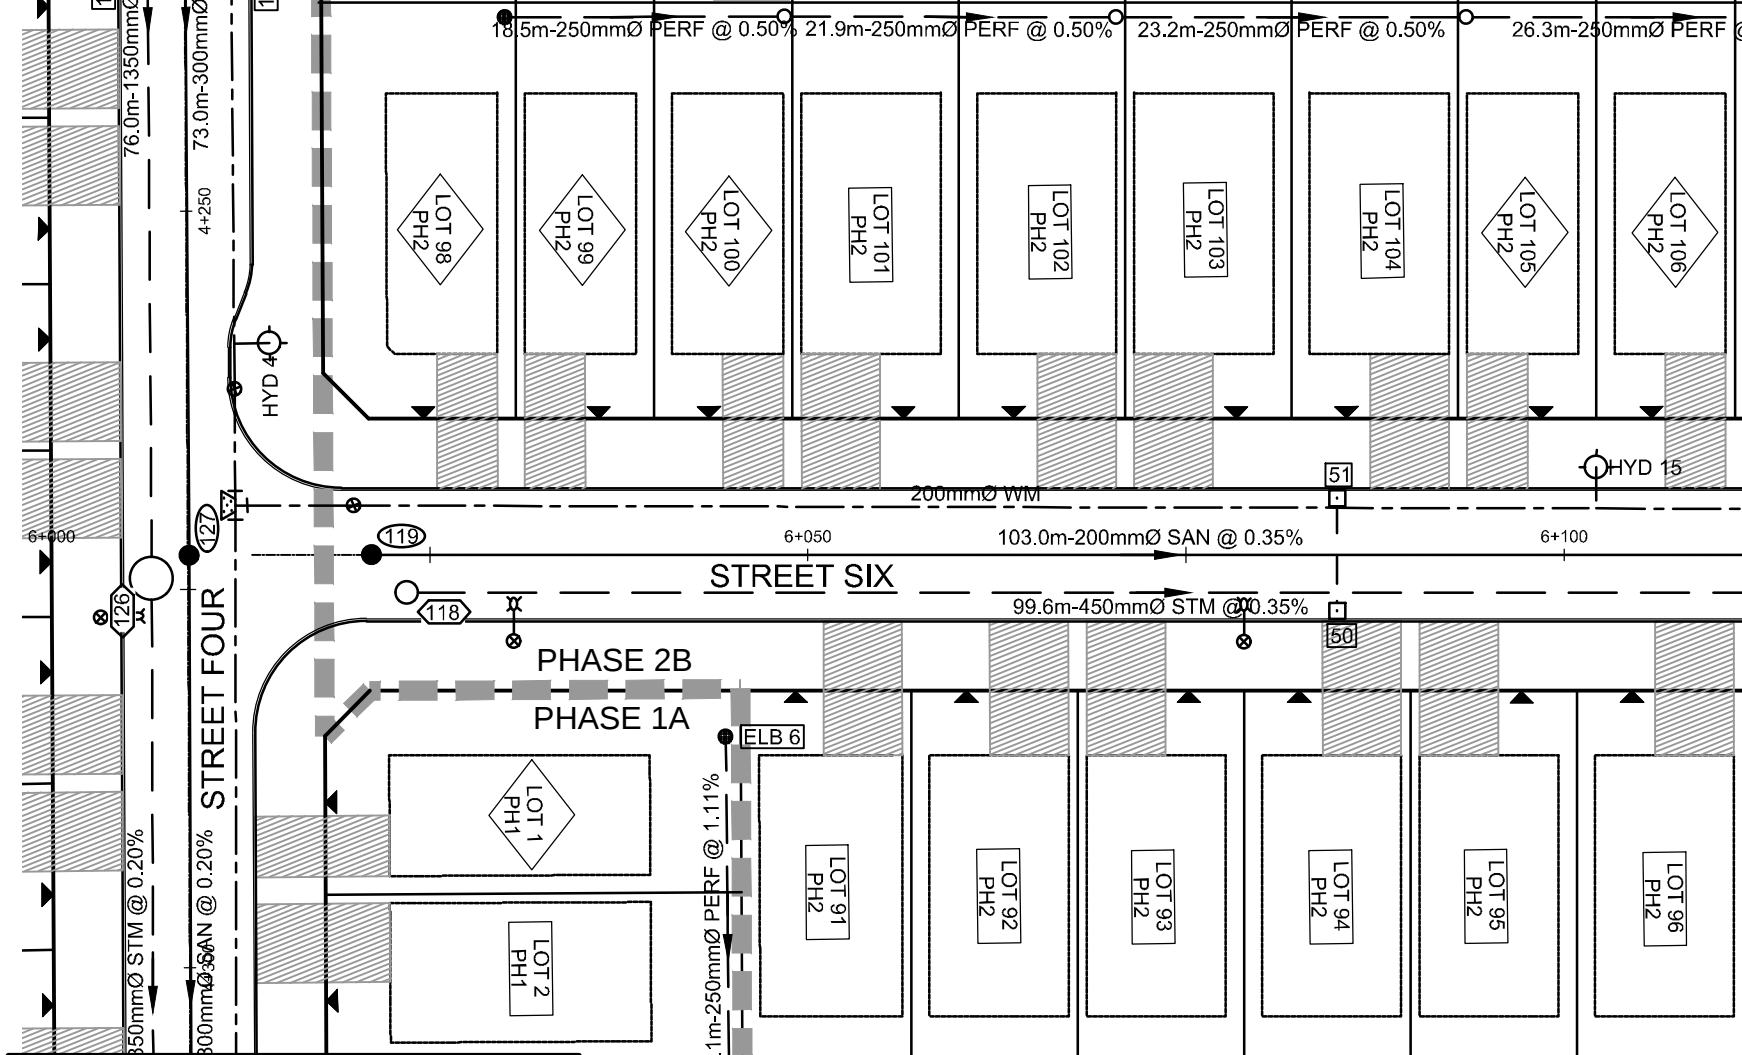
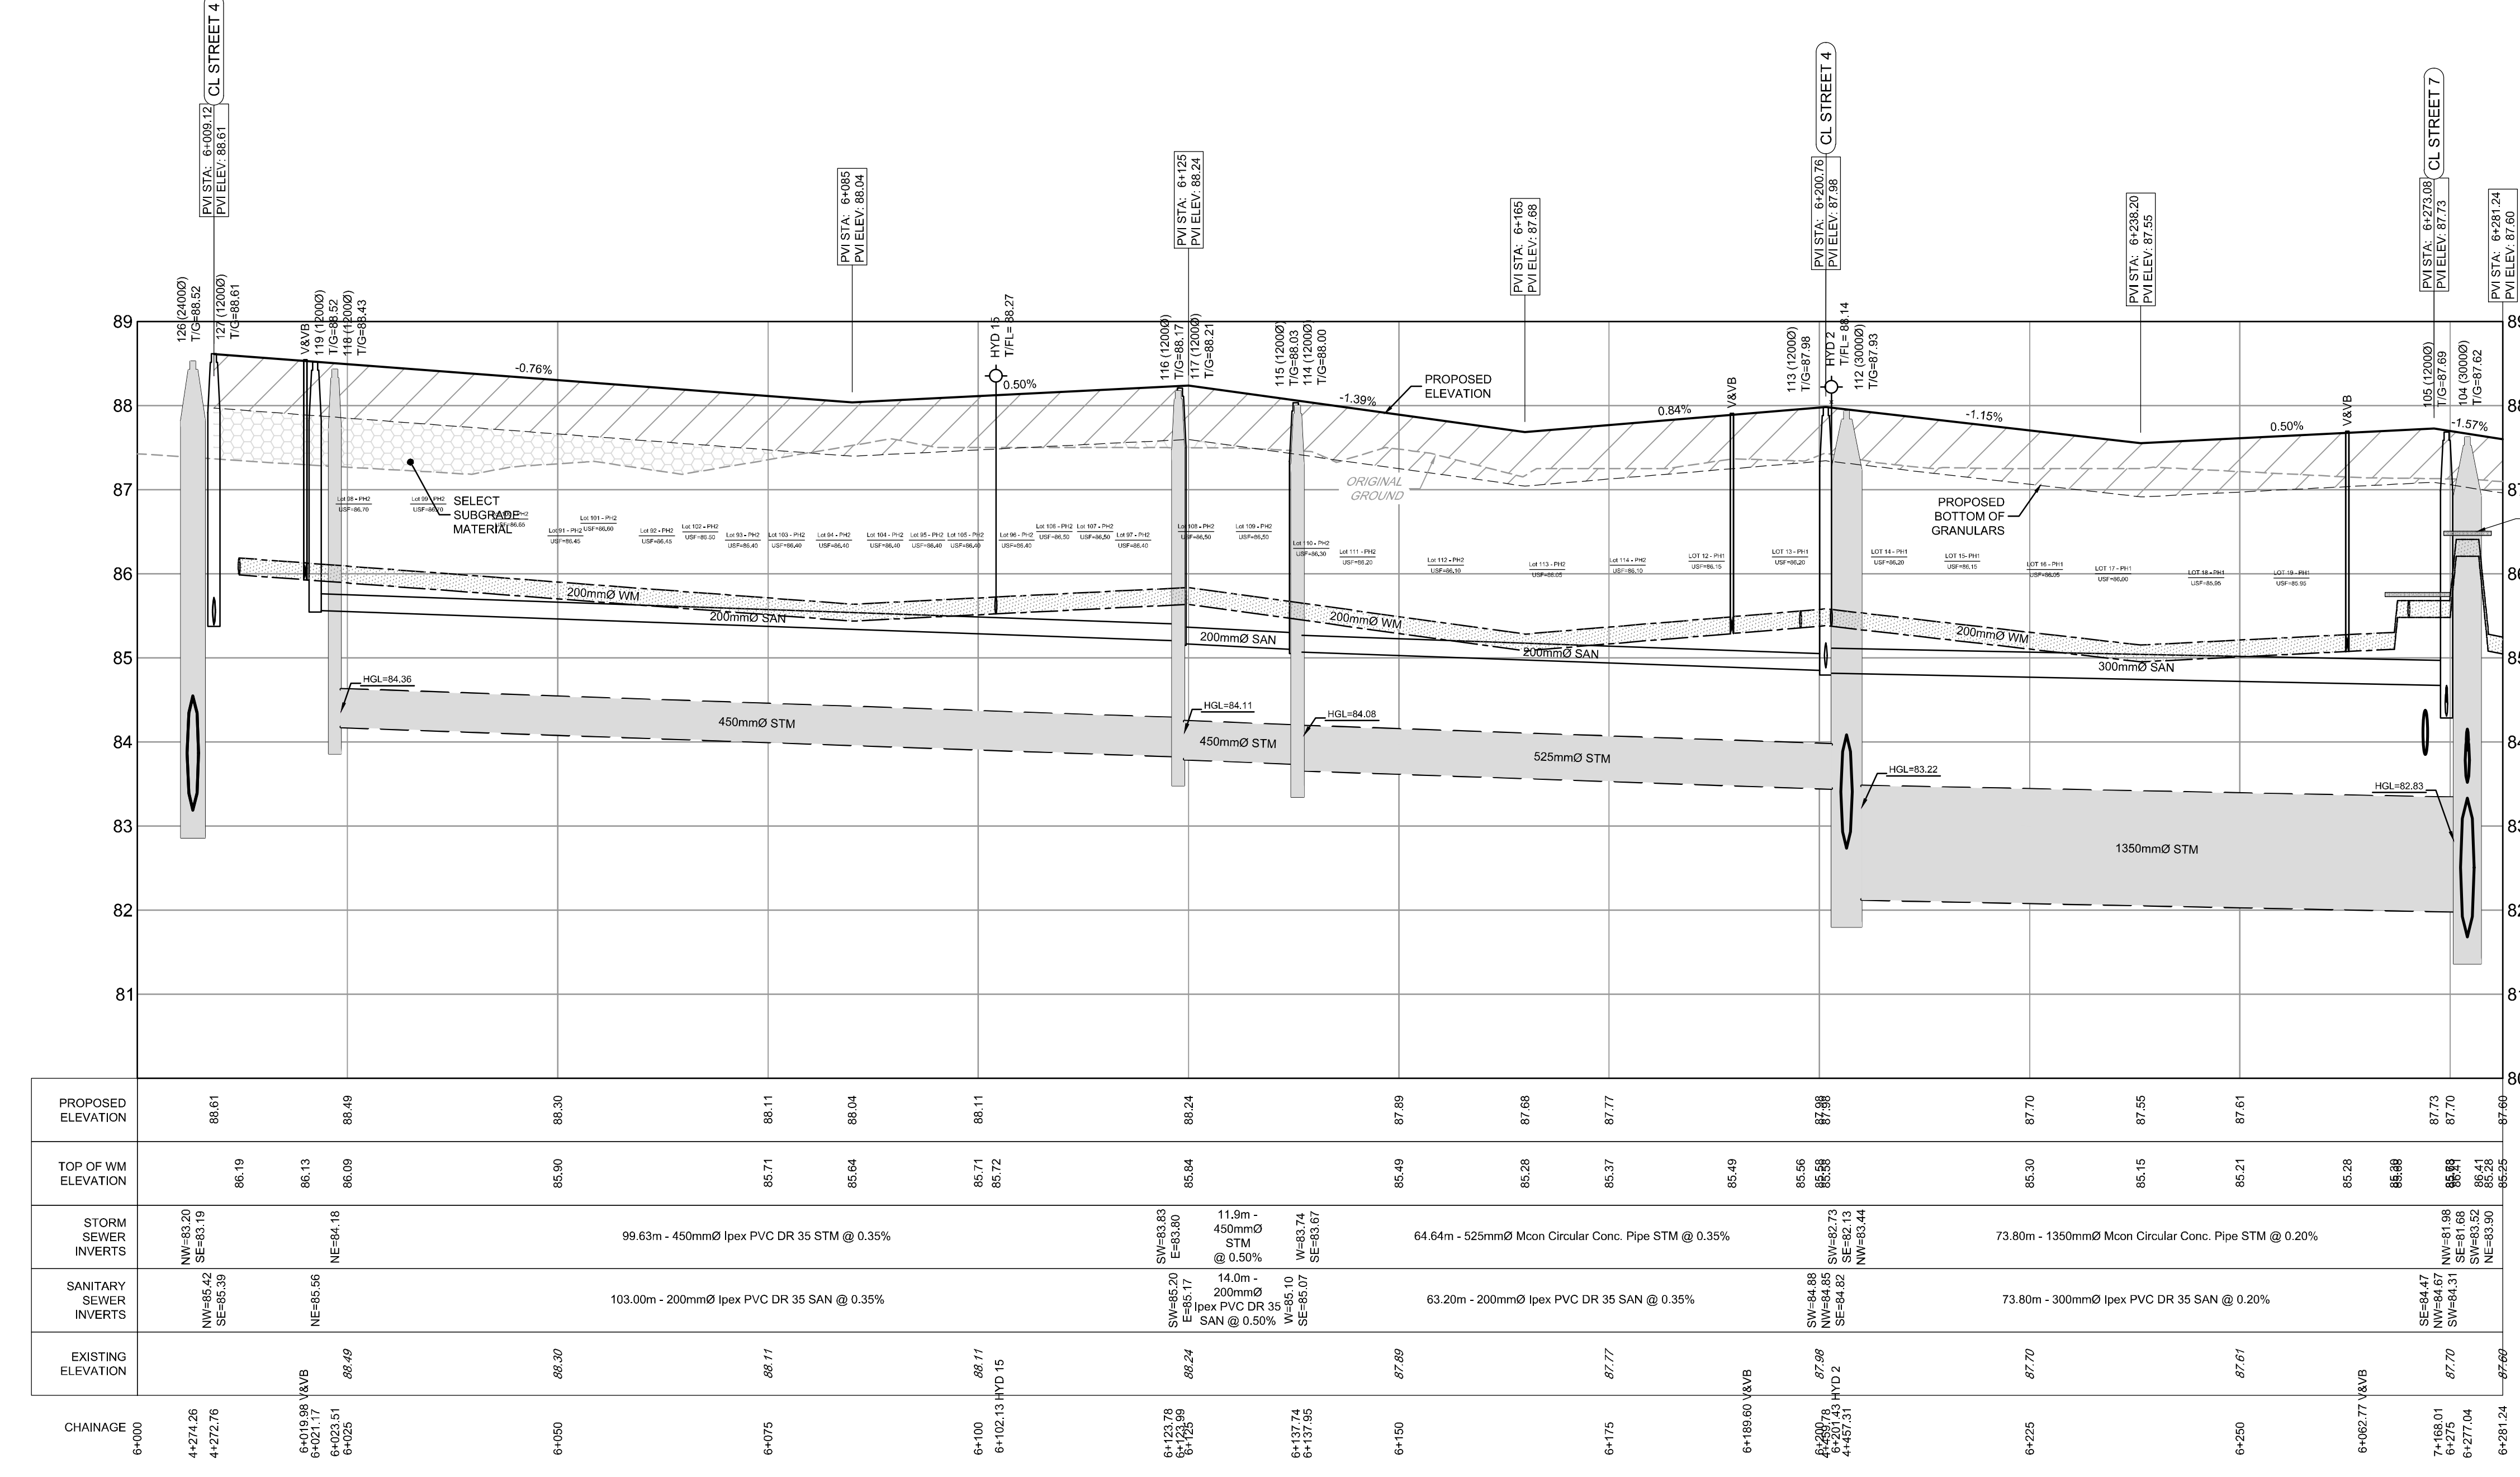


SEE DRAWING NO. 118224-PR3

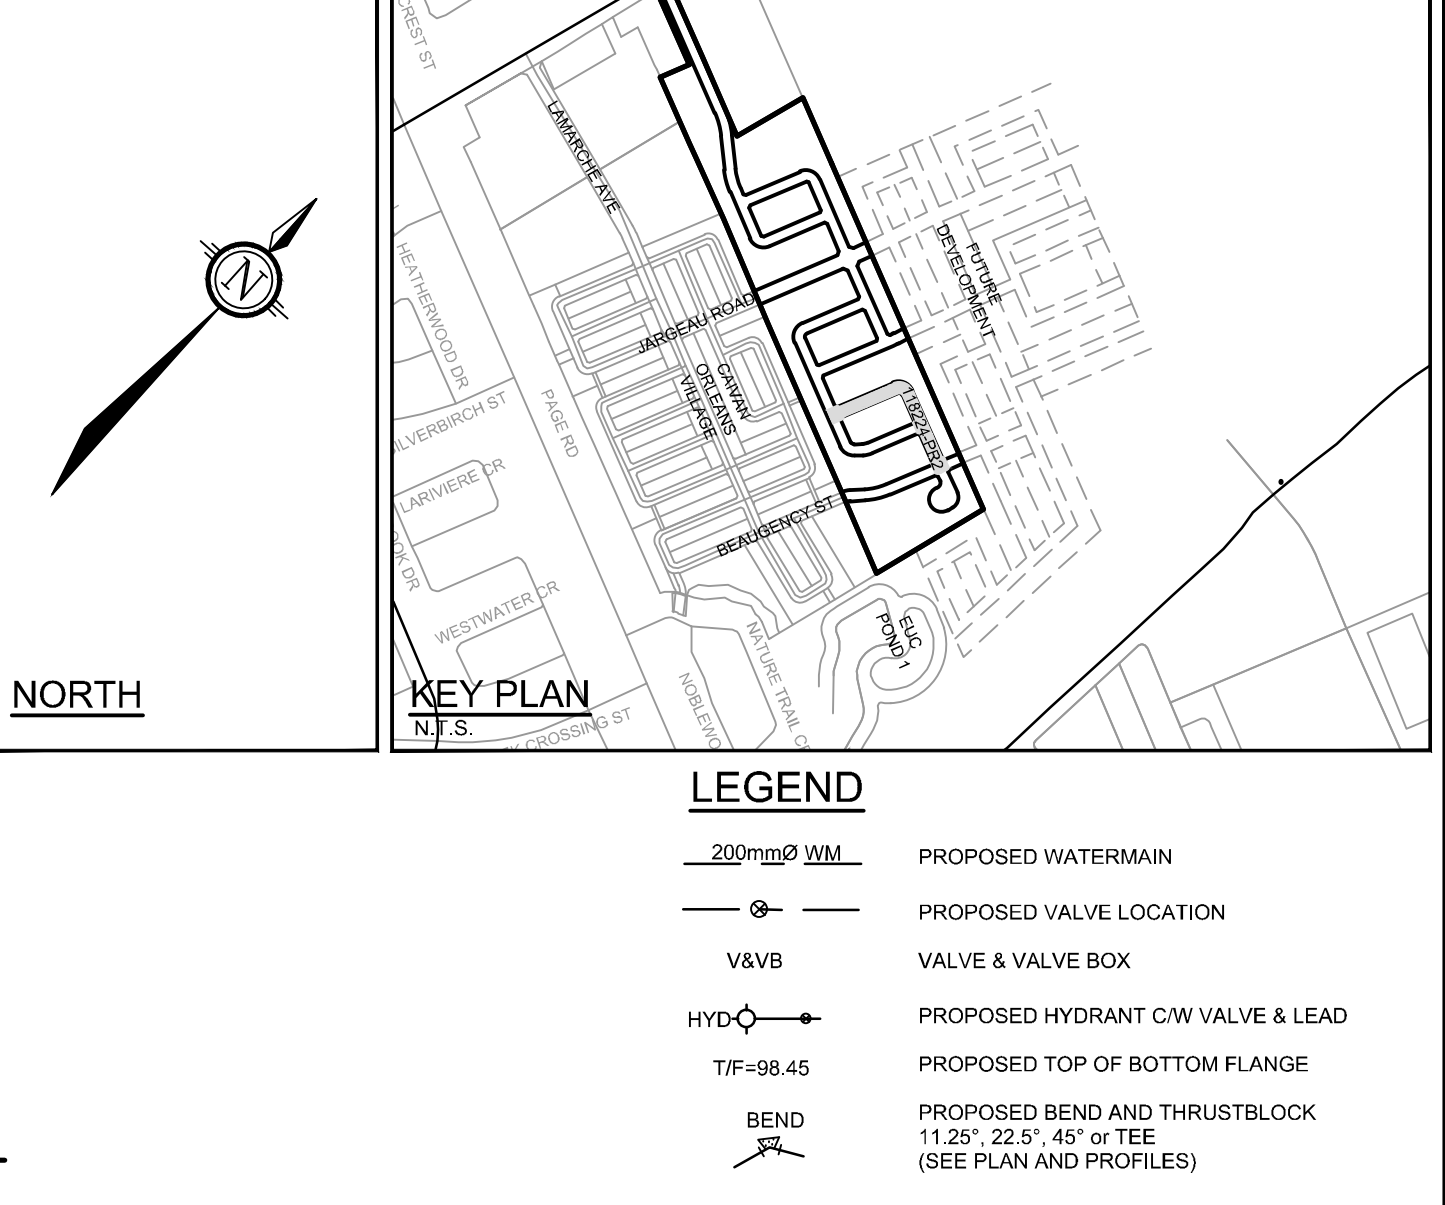


SEE DRAWING NO. 118224-PR3

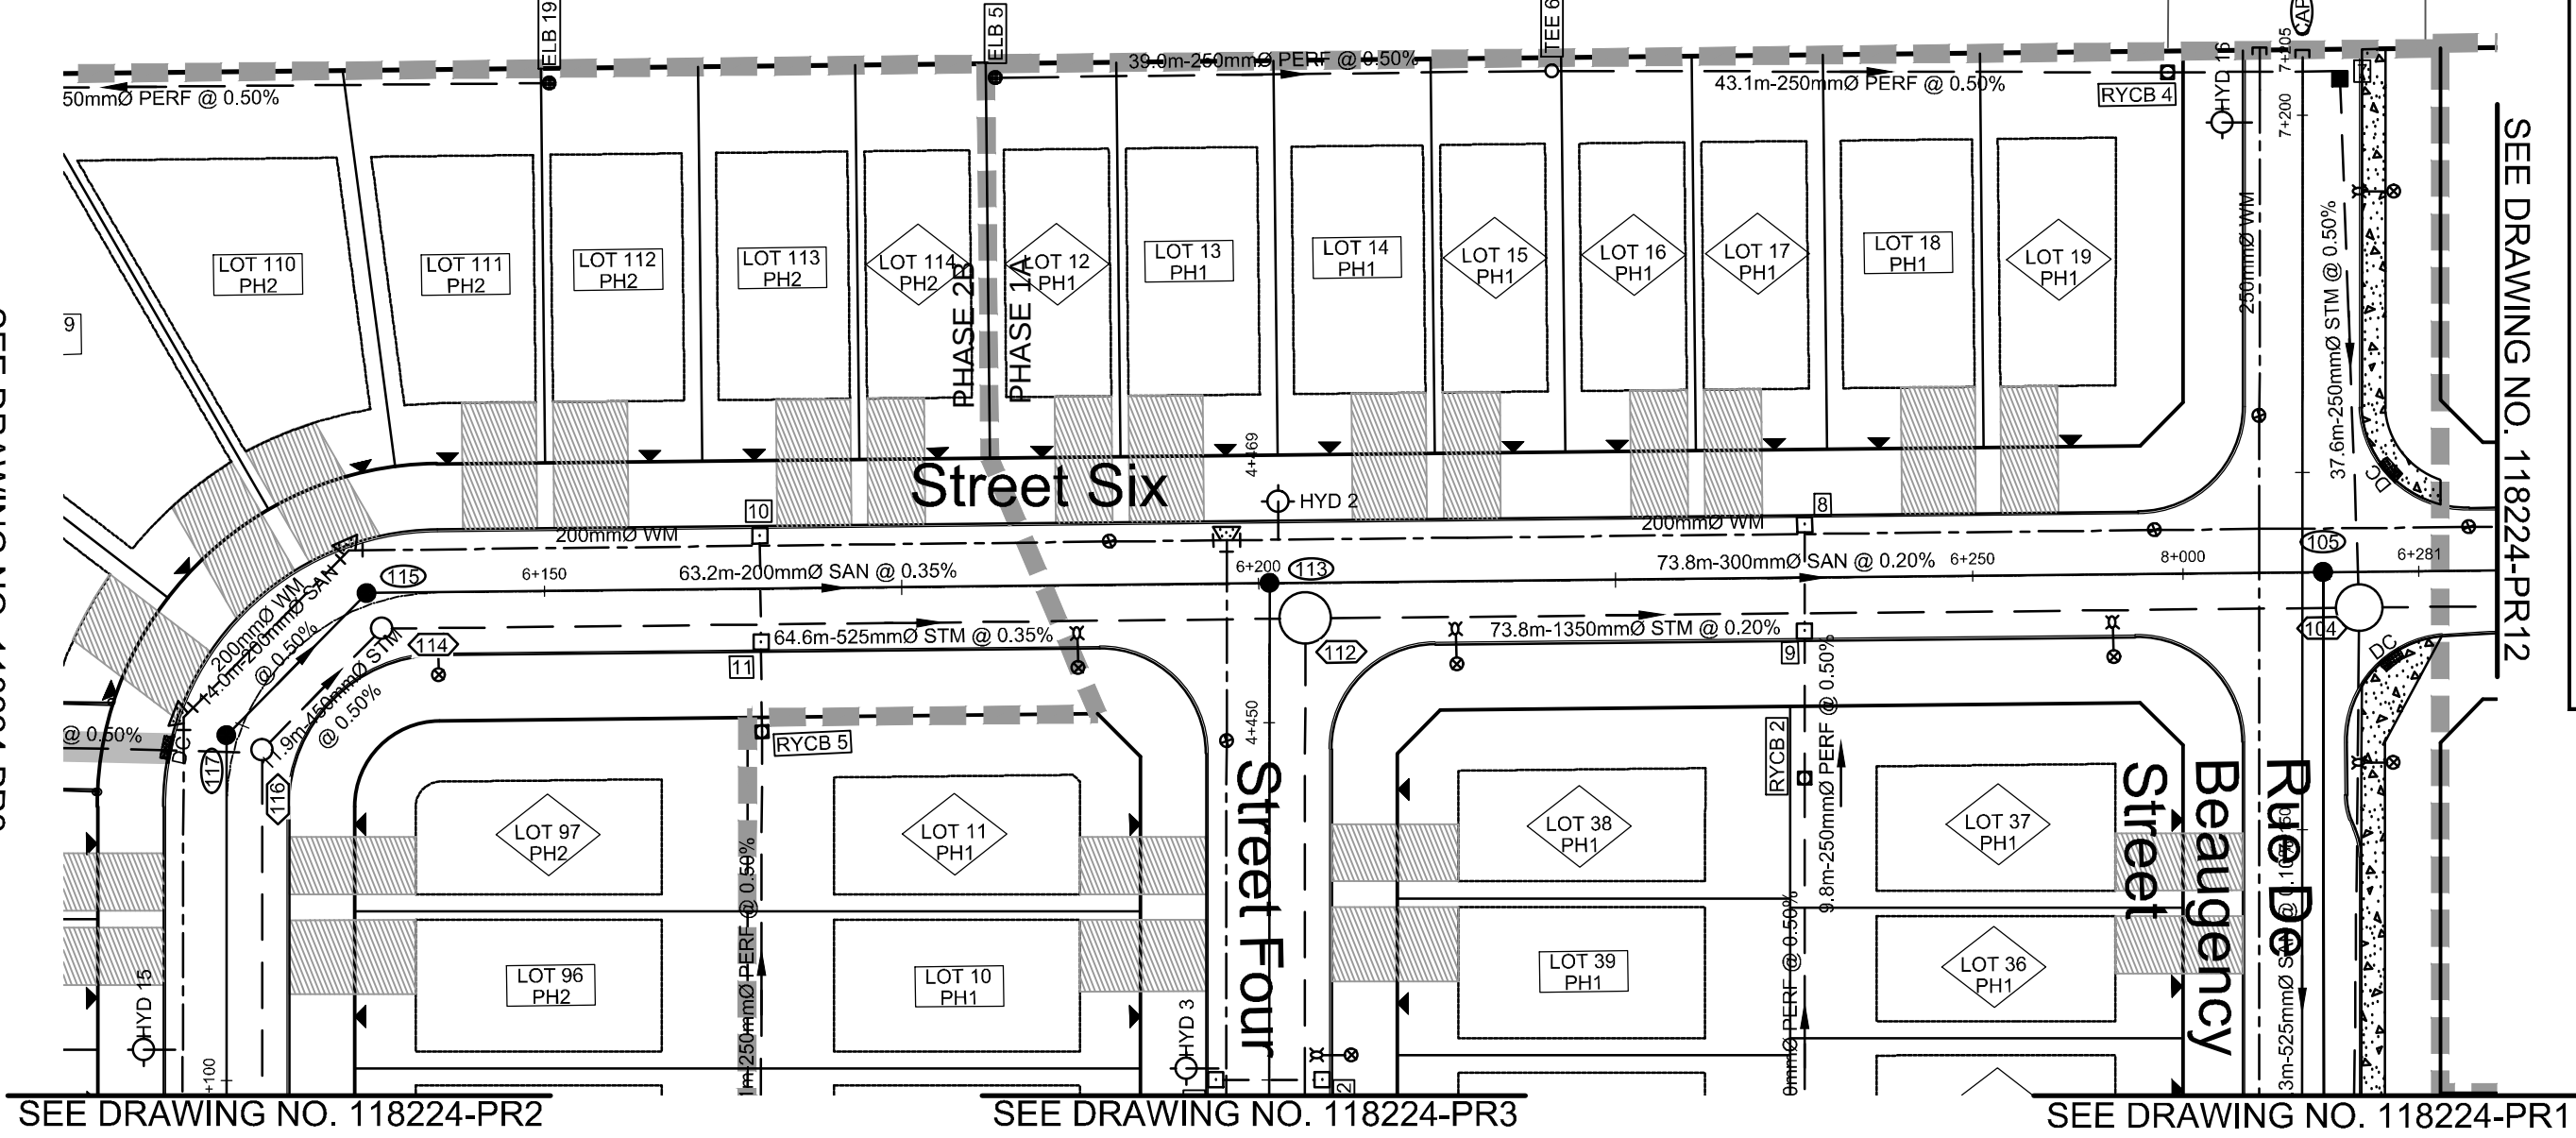

NOTE:
THE POSITION OF ALL POLE LINES, CONDUITS,
WATERMAINS, SEWERS AND OTHER
UNDERGROUND AND OVERGROUND UTILITIES AND
STRUCTURES IS NOT NECESSARILY SHOWN ON
THE CONTRACT DRAWINGS, AND WHERE SHOWN,
THE ACCURACY OF THE POSITION OF SUCH
UTILITIES AND STRUCTURES IS NOT GUARANTEED.
BEFORE STARTING WORK, DETERMINE THE EXACT
LOCATION OF ALL SUCH UTILITIES AND
STRUCTURES AND ASSUME ALL LIABILITY FOR
DAMAGE TO THEM.

PRELIMINARY

No.	REVISION	DATE	BY
2.	ISSUED FOR DISCUSSION	JUN 18/21	BHB
1.	ISSUED FOR DISCUSSION	MAR 5/21	BHB

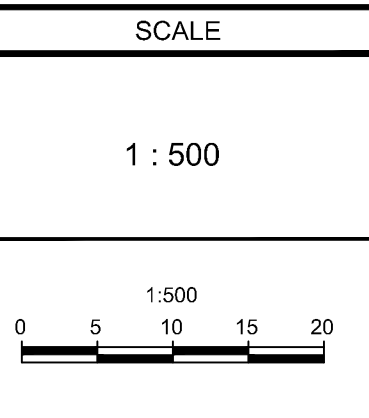

DESIGN	FOR REVIEW ONLY
DJC	
CHECKED	BCS
DRAWN	DJC
CHECKED	BCS
APPROVED	BHB



Engineers, Planners & Landscape Architects
Suite 200, 240 Michael Cowpland Drive
Ottawa, Ontario, Canada K2M 1P6

Telephone (613) 254-9643
Facsimile (613) 254-5867
Website www.novatech-eng.com

LOCATION
CITY OF OTTAWA
THE COMMONS

DRAWING NAME
PLAN AND PROFILE
STREET 6
STATION 6+000 TO 6+281

PROJECT No.
118224-00

REV
REV # 2

DRAWING No.
118224-PR2