

	PROPERTY LINE
	JOINT UTILITY TRENCH
	COMMUNICATIONS TRENCH
	HYDRO SECONDARY
	GAS MAIN
	STREETLIGHT CABLE AND DUCT
	1 PHASE PADMOUNT HYDRO TRANSFORMER
	HYDRO PRIMARY PEDESTAL
	6x12 PRECAST MANHOLE
	STREETLIGHT
	STREETLIGHT DISCONNECT
	PROPOSED STREETLIGHT GROUNDING ROD

	UTILITY POLE	
	ROGERS PEDESTAL	
	ROGERS GRADE LEVEL BOX	
	BELL PEDESTAL	
	BELL CENTRAL SPLIT POINT	
	BELL GRADE LEVEL BOX	
	PROPOSED ROAD CROSSING	
	2 STREET LIGHT	
	7 HYDRO	
	1 ROGERS	
	1 BELL	
	1 GAS	
	DEPRESSED CURB	
	COMMUNITY MAILBOX	


	HYDRO METER BOX LOCATION
	HYDRO GANG METER LOCATION
	GAS METER BOX LOCATION
	PROPOSED HYDRANT LOCATION
	PROPOSED ROAD CATCHBASIN
	PROPOSED REARYARD CATCHBASIN
	PROPOSED SANITARY MANHOLE
	PROPOSED STORM MANHOLE
	SERVICE LOCATION

	PROPOSED DECIDUOUS TREE
	PROPOSED SIDEWALK REINSTATEMENT
	DRAINAGE EASEMENT
	UTILITY EASEMENT
	EXISTING TREE TO REMAIN IF POSSIBLE
	PROPOSED OVERLAY



COMPOSITE UTILITY PLAN TO BE READ IN
CONJUNCTION WITH:

- HYDRO OTTAWA PLANS, REF NO. XXX
- BELL PLANS, REF NO. XXX
- ROGERS PLANS, REF NO. XXX
- ENBRIDGE PLANS, REF NO. XXX
- STREETLIGHTING PLAN, 118224-SL
- LANDSCAPE PLANS,

ALL FOOTPRINTS SHOWN ARE CONCEPTUAL. REFER TO INDIVIDUAL SITING PLANS FOR FINAL MODEL FOOTPRINT

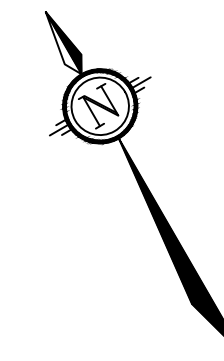

NORTH

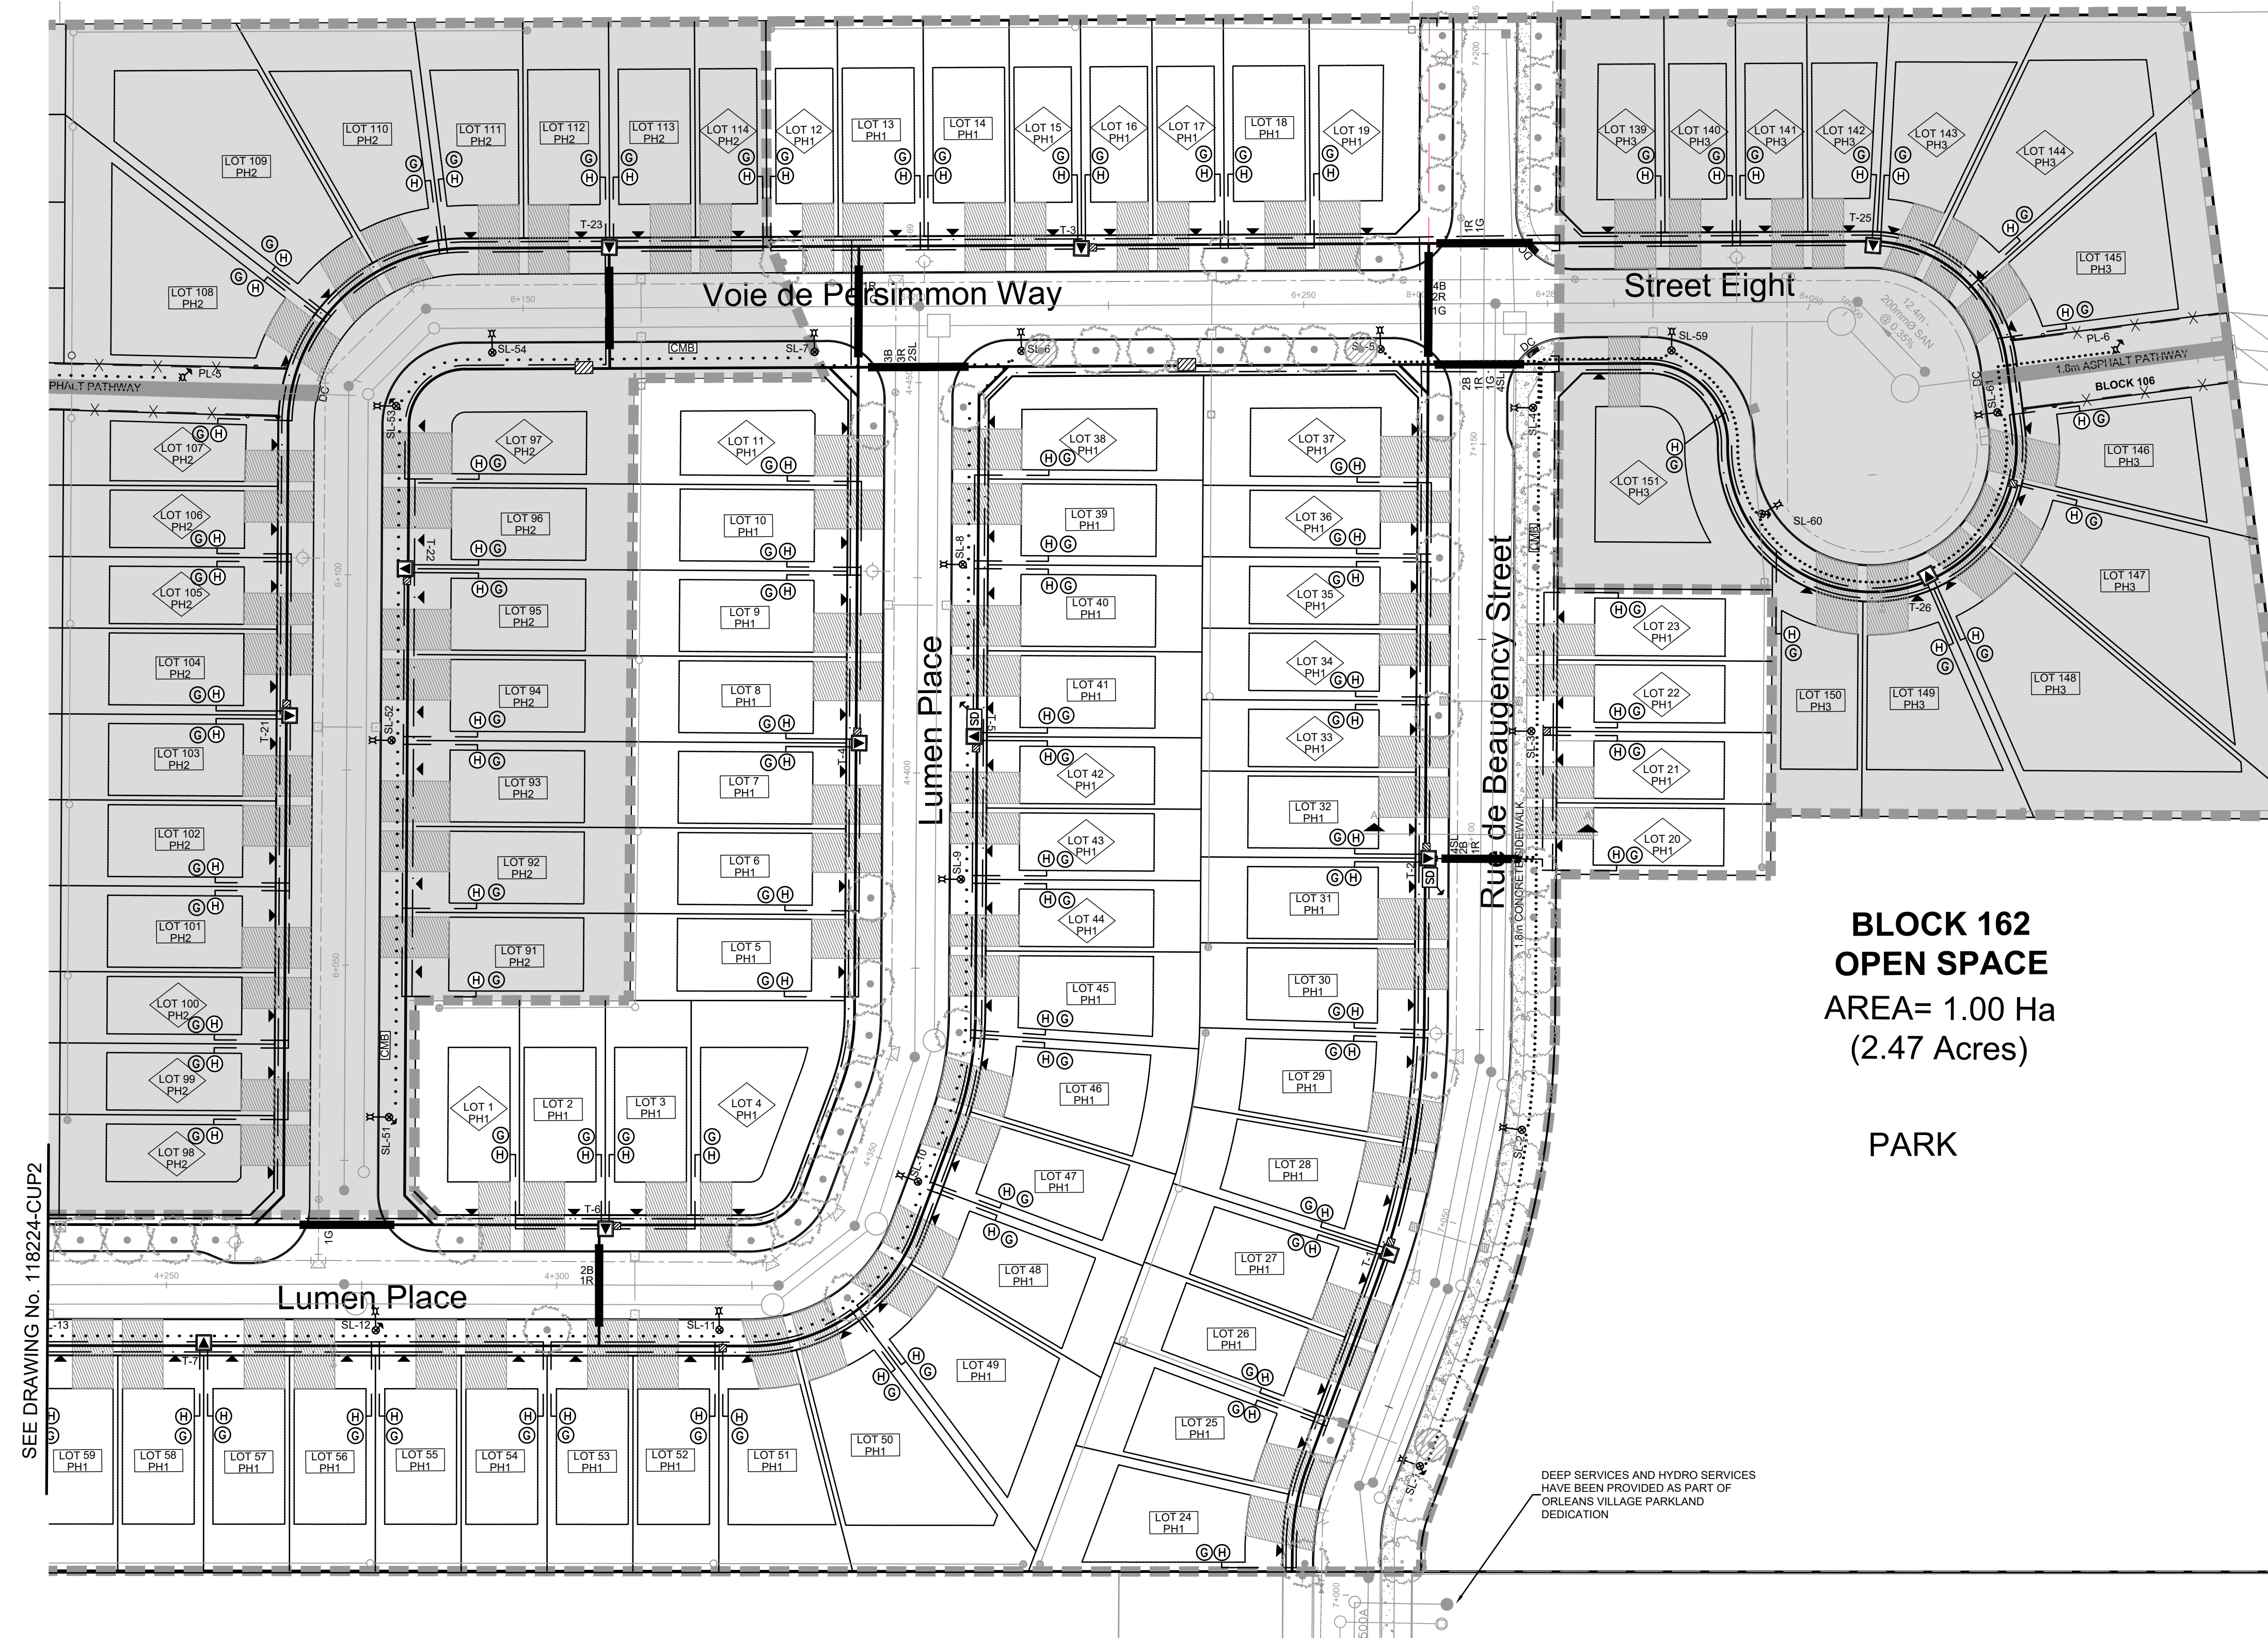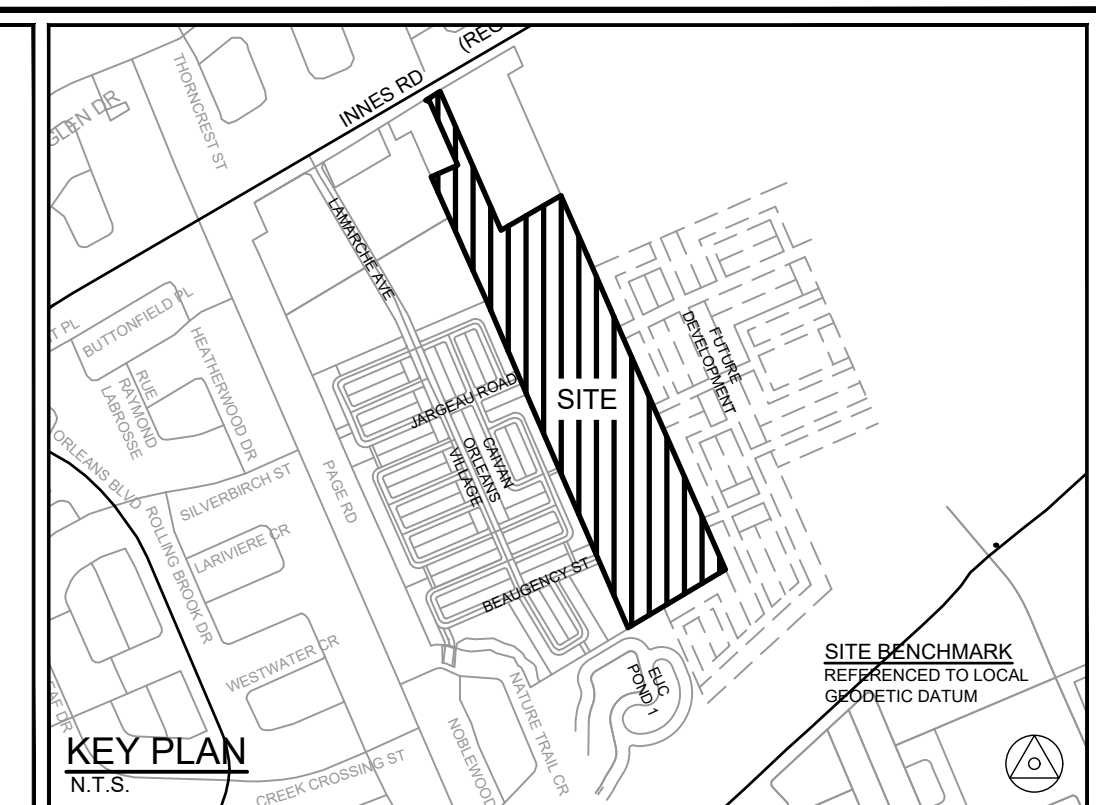

BLOCK 162
OPEN SPACE
AREA= 1.00 Ha
(2.47 Acres)

PARK

SEE DRAWING No. 118224-CUP2

NOTE:
THE POSITION OF ALL POLE LINES, CONDUITS, WATERMANS, SEWERS AND OTHER UNDERGROUND AND OVERGROUND UTILITIES AND STRUCTURES IS NOT NECESSARILY SHOWN ON THE CONTRACT DRAWINGS, AND WHERE SHOWN, THE ACCURACY OF THE POSITION OF SUCH UTILITIES AND STRUCTURES IS NOT GUARANTEED. BEFORE STARTING WORK, DETERMINE THE EXACT LOCATION OF ALL SUCH UTILITIES AND STRUCTURES AND ASSUME ALL LIABILITY FOR DAMAGE TO THEM.

PRELIMINARY

 
REFER TO 118224-XS1 AND 118224-XS2 FOR TYPICAL ROAD CROSS SECTIONS

REFER TO 118224-ND FOR ADDITIONAL NOTES & DETAILS

[illegible]

SCALE

1:500



DESIGN	BP
CHECKED	BCS
DRAWN	BP
CHECKED	BCS
APPROVED	BHE

FOR REVIEW ONLY



Engineers, Planners & Landscape Architects
Suite 200, 240 Michael Cowpland Drive
Ottawa, Ontario, Canada K2M 1P6

Telephone (613) 254-9643
Facsimile (613) 254-5867
Website www.novatech-eng.com

LOCATION	CITY OF OTTAWA THE COMMONS
----------	-------------------------------

DRAWING NAME

COMPOSITE UTILITY PLAN

PROJECT No. _____

118224-00

EV

REV # 2

118334 CUB1

#18535

D007-16-19-0027