

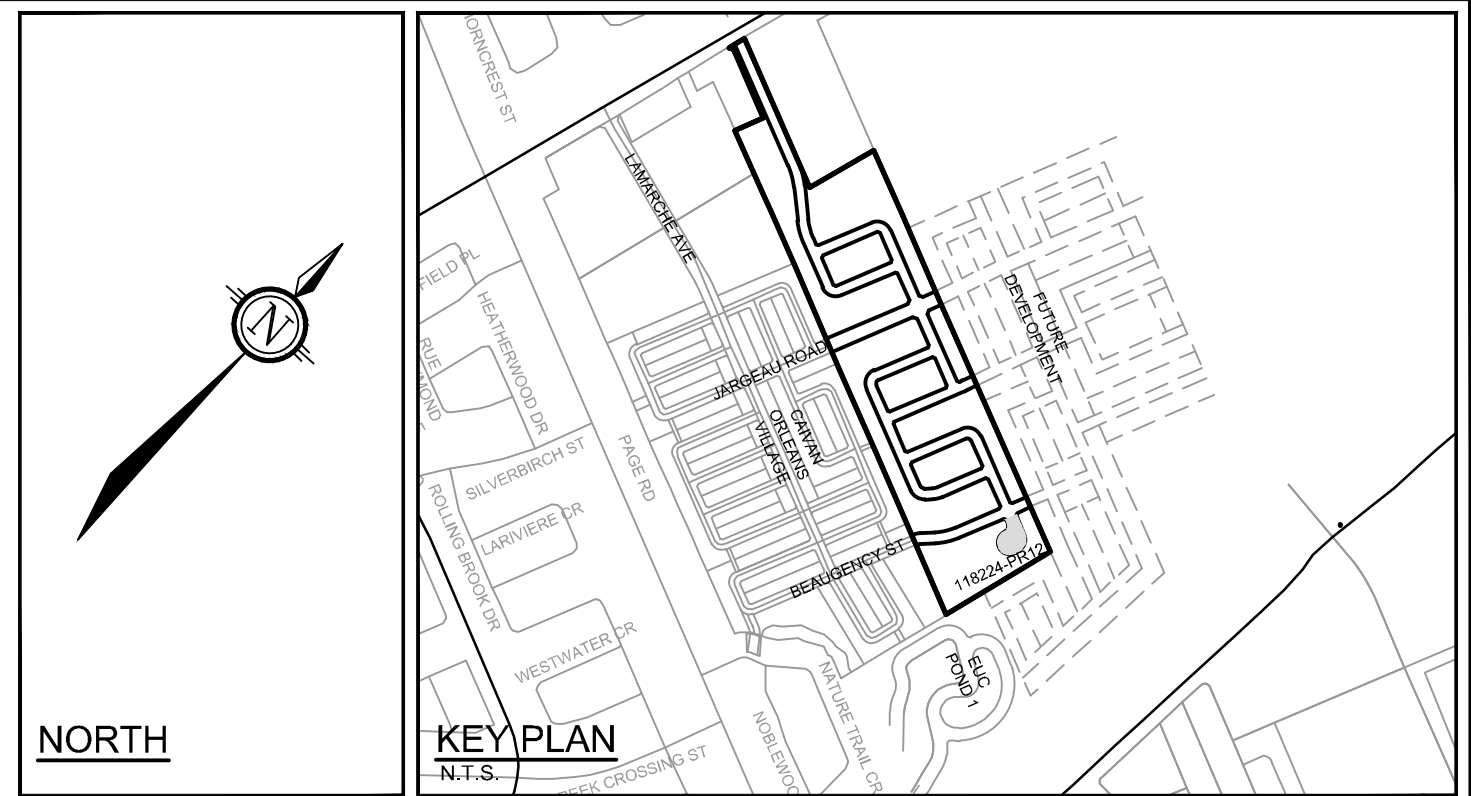


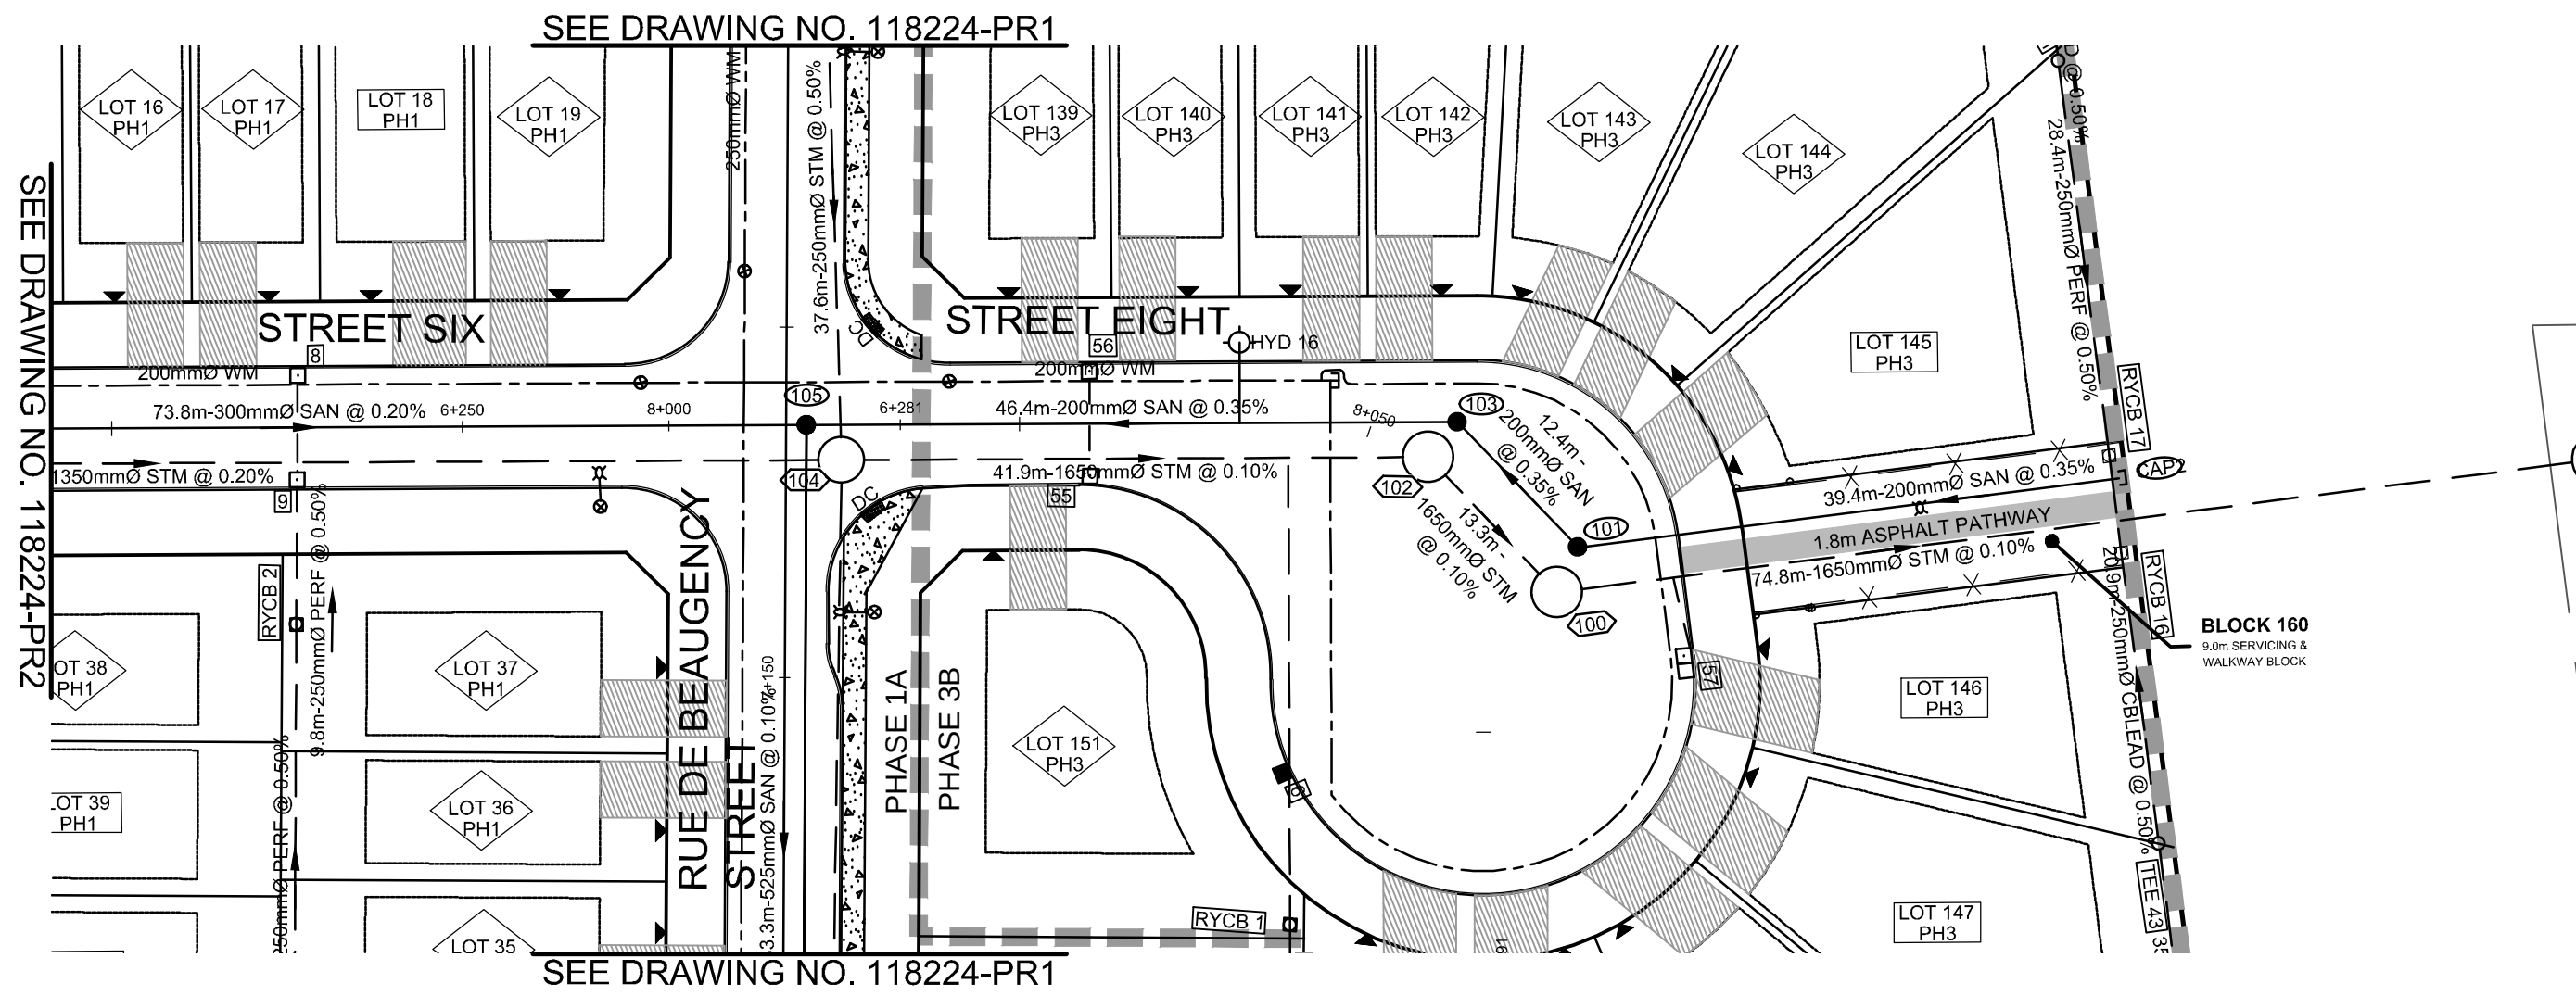

LEGEND

- 200mm Ø WM PROPOSED WATERMAIN
- V&VB PROPOSED VALVE LOCATION
- HYD T/F=98.45 PROPOSED HYDRANT C/W VALVE & LEAD
- BEND PROPOSED TOP OF BOTTOM FLANGE
- SERVICE CONNECTION STUB (SINGLE)
- 100mm STORM @1.0%
 - 19mm WATER
 - 125mm SANITARY @1.0%
- PROPOSED SANITARY MH & SEWER
- PROPOSED STORM MH & SEWER
- LYCB PROPOSED LANDSCAPE TEE CATCHBASIN & PERFORATED SUBDRAIN PER S29, S30, S31
- LYCB PROPOSED LANDSCAPE ELBOW CATCHBASIN & PERFORATED SUBDRAIN PER S29, S30, S31
- RYCBMH PROPOSED REAR YARD CATCHBASIN MANHOLE & LEAD
- RYCB PROPOSED REAR YARD CATCHBASIN & LEAD
- CB PROPOSED ROAD CATCHBASIN
- DIRECTION OF FLOW
- EXISTING 1.8m CONCRETE SIDEWALK
- DRAINAGE EASEMENT
- EXISTING FENCE - CHAINLINK
- SIDEWALK REINSTATEMENT FOR DEPRESSED CURBS
- UTILITY EASEMENT
- PROPOSED OVERLAY

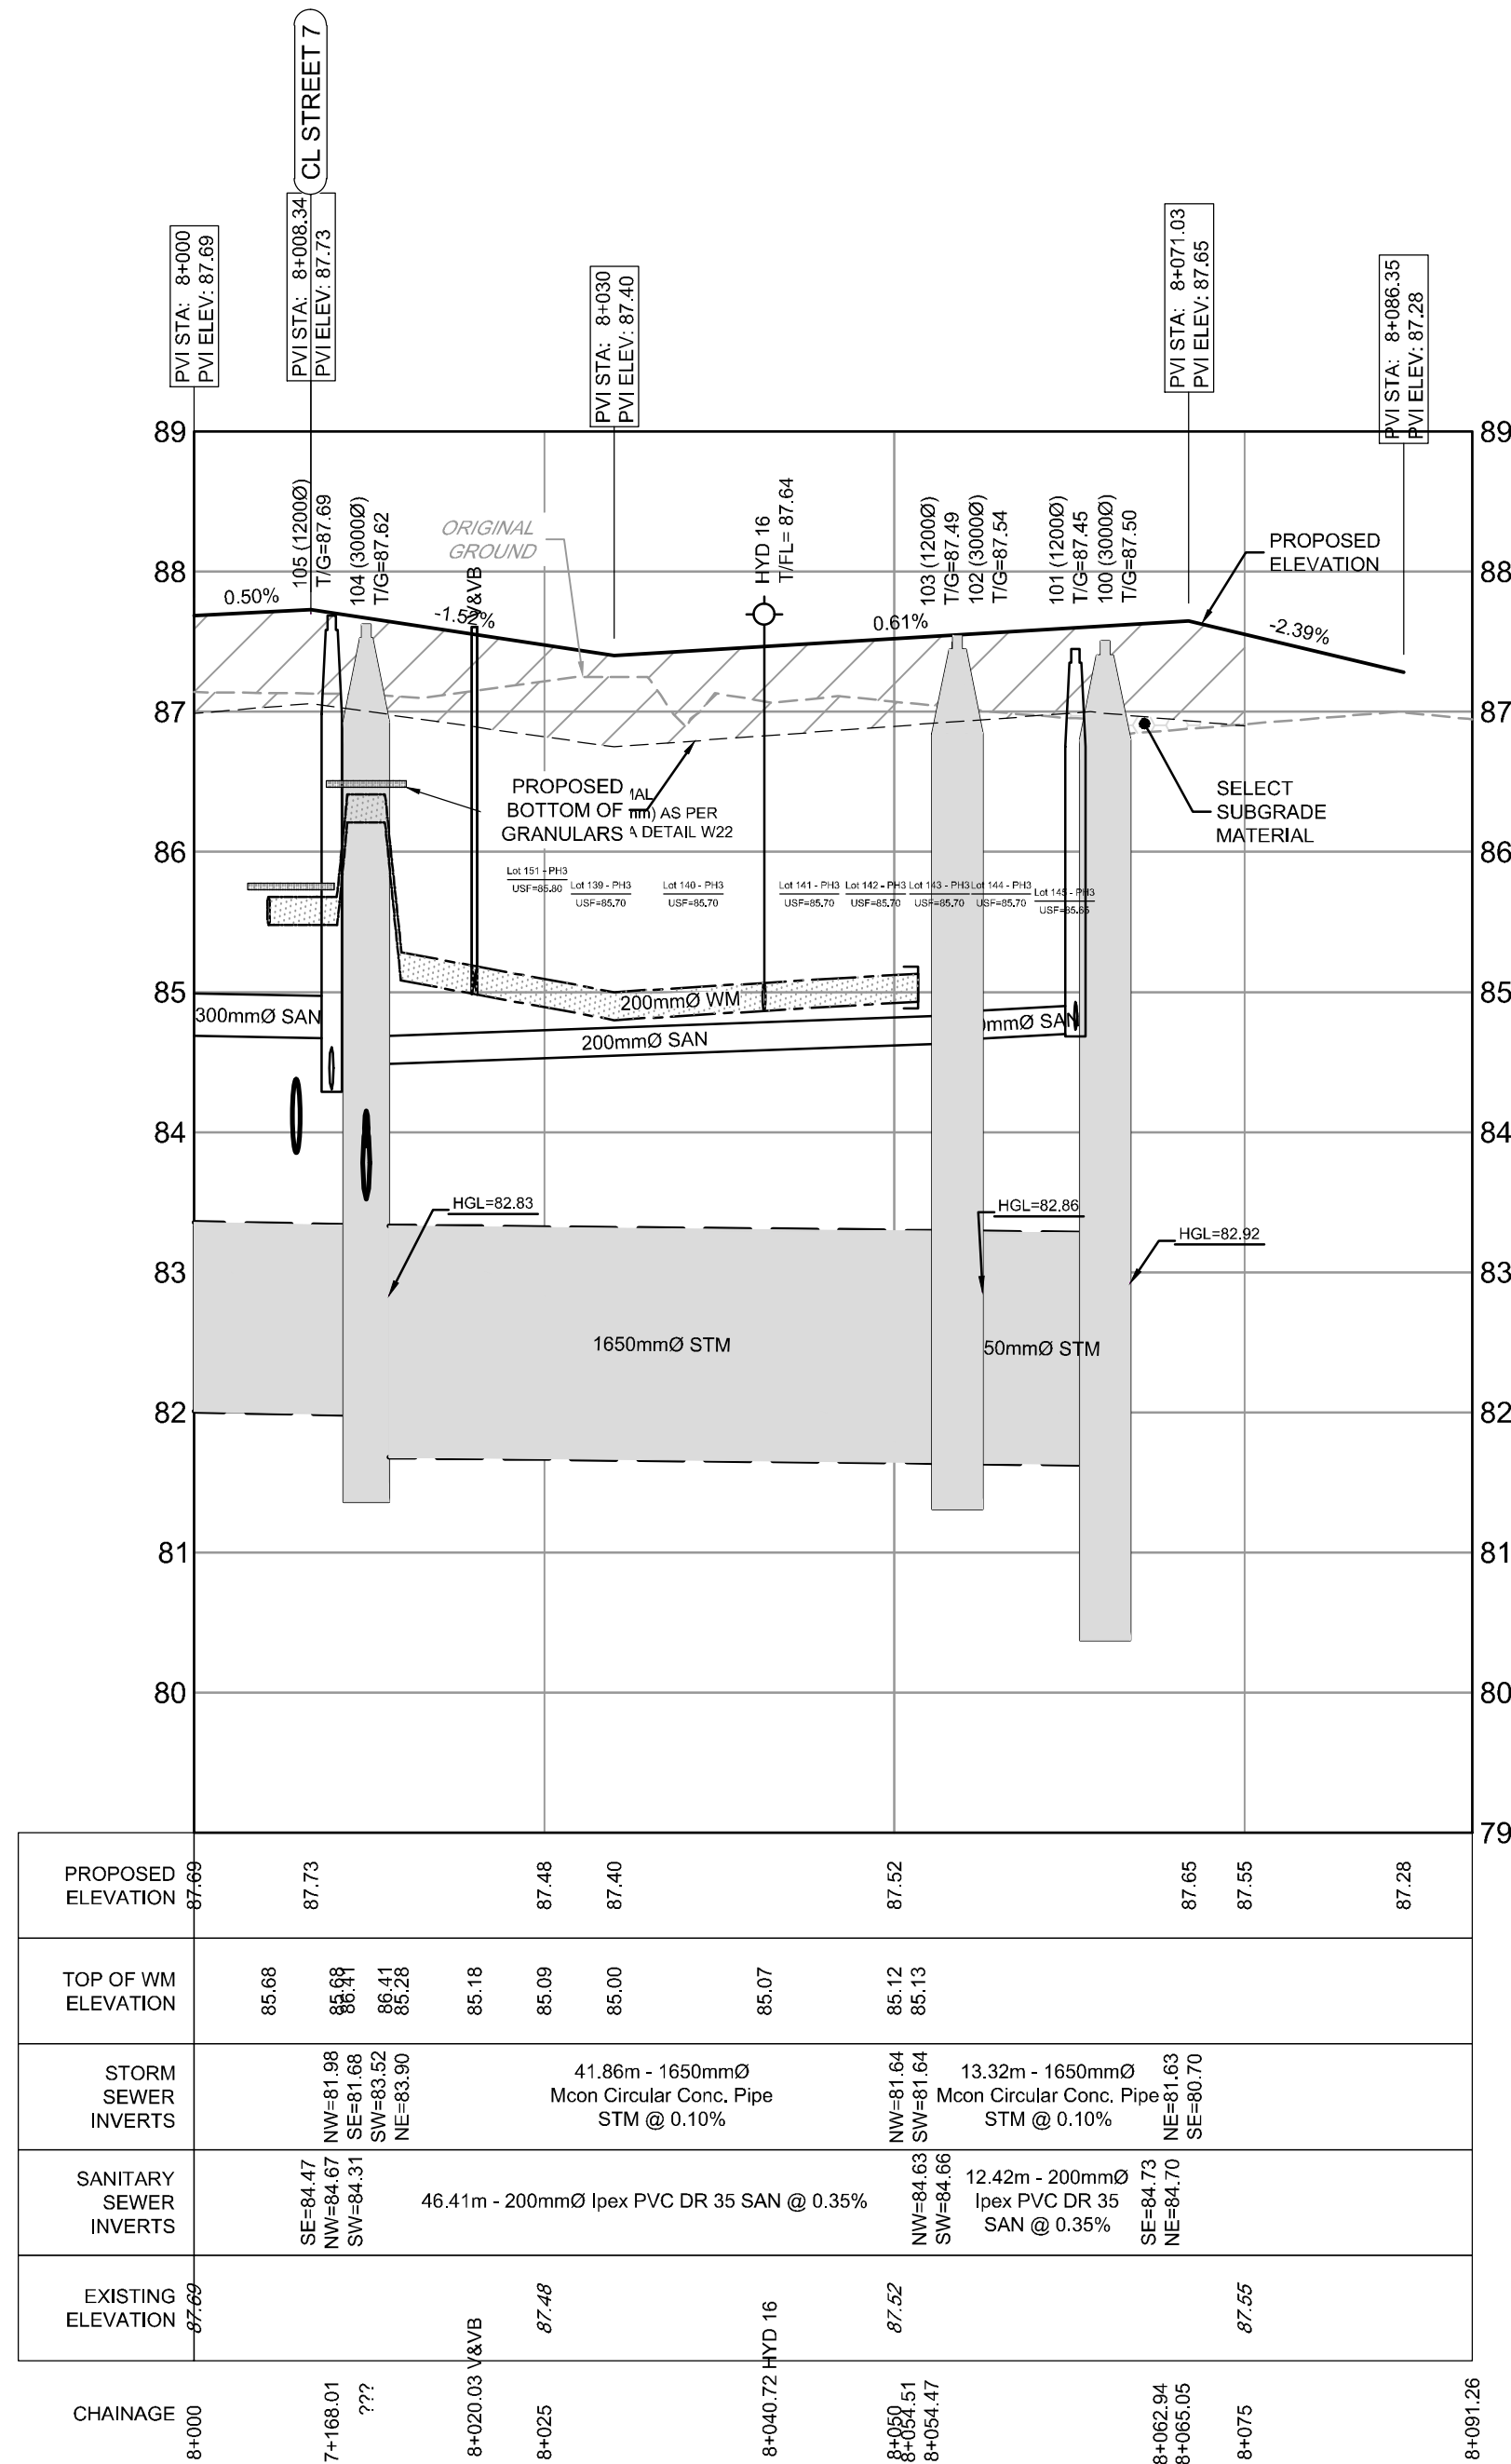

 
LEGEND

- TP 19-17 97.13 TEST PIT LOCATION
- TOP SOIL
- SAND
- SILTY SAND
- SILTY CLAY
- GLACIAL TILL
- WEATHERED BEDROCK

PRELIMINARY

SCALE

1 : 500



DESIGN

DJC

CHECKED

BCS

DRAWN

DJC

CHECKED

BCS

APPROVED

BHB

FOR REVIEW ONLY



NOVATECH

Engineers, Planners & Landscape Architects
Suite 200, 240 Michael Cowpland Drive
Ottawa, Ontario, Canada K2M 1P6

Telephone (613) 254-9643
Facsimile (613) 254-5867
Website www.novatech-eng.com

LOCATION
CITY OF OTTAWA
THE COMMONS

DRAWING NAME
PLAN AND PROFILE
STREET 8
STATION 8+000 TO 8+091

PROJECT No.

118224-00

REV

REV # 2

DRAWING No.

118224-PR12