

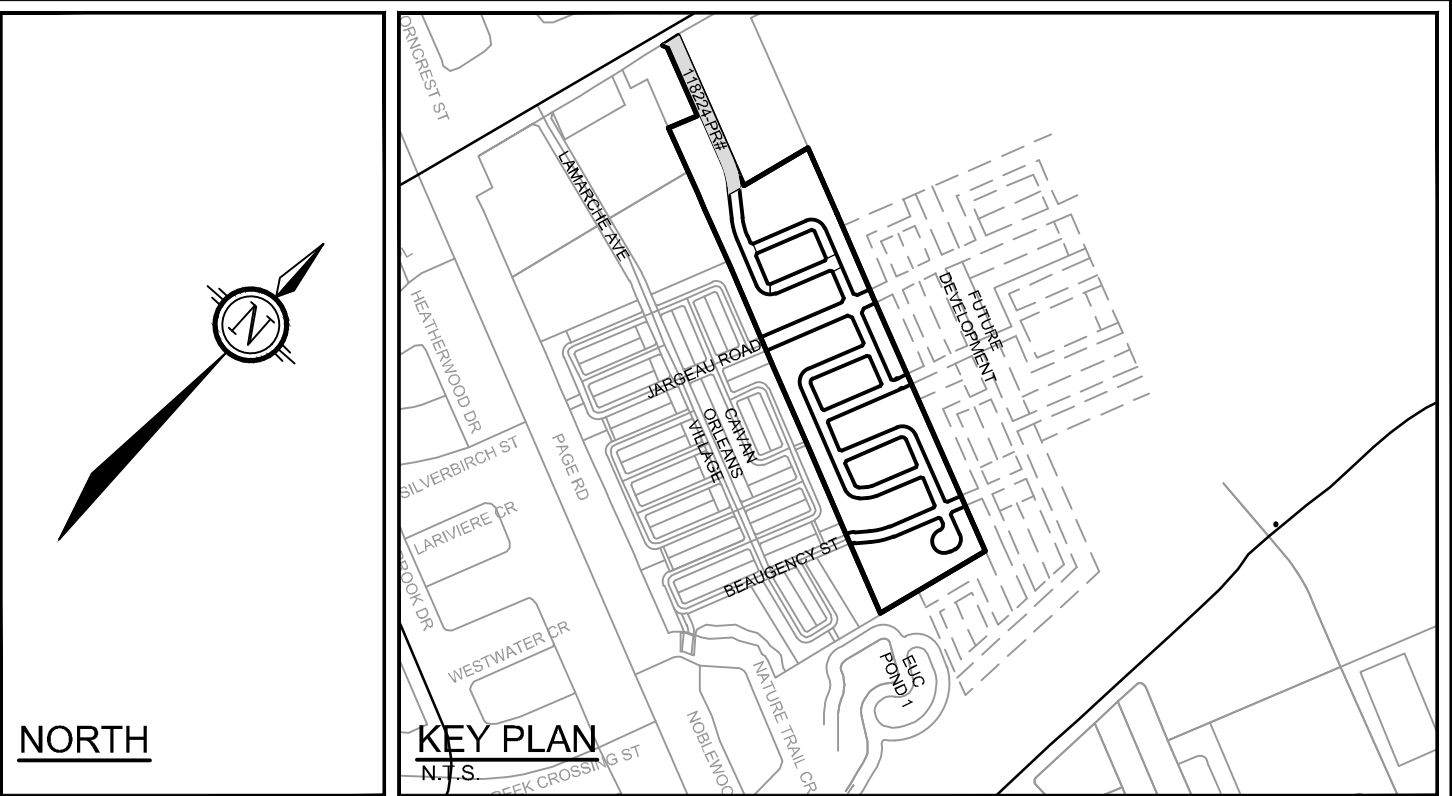
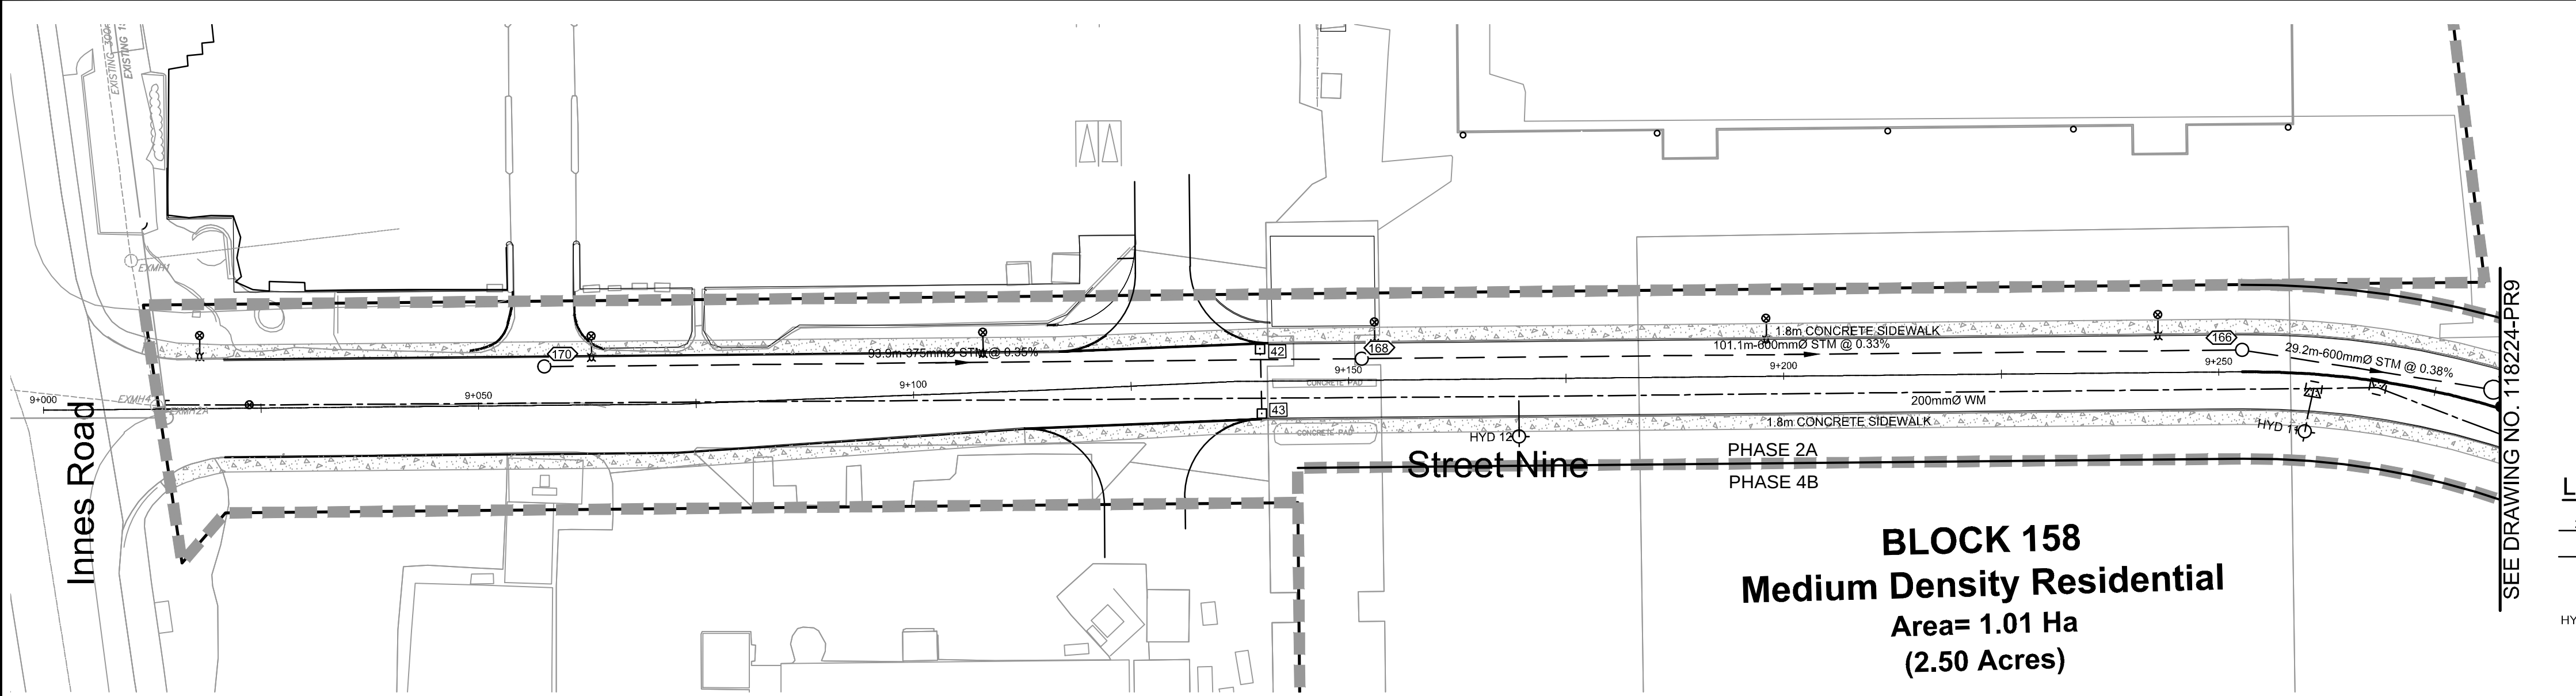


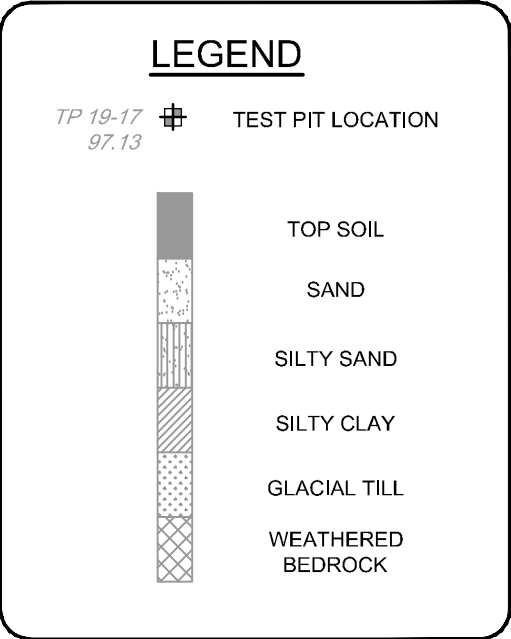

- LEGEND**
- 200mmØ WM: PROPOSED WATERMAIN
 - V&VB: PROPOSED VALVE LOCATION
 - HYD: PROPOSED HYDRANT CW VALVE & LEAD
 - T/F=98.45: PROPOSED TOP OF BOTTOM FLANGE
 - BEND: PROPOSED BEND AND THRUSTBLOCK
 - SERVICE CONNECTION STUB (SINGLE): 100mm STORM @ 1.0%, 19mm WATER, 125mm SANITARY @ 1.0%
 - PROPOSED SANITARY MH & SEWER
 - PROPOSED STORM MH & SEWER
 - LYCB: PROPOSED LANDSCAPE TEE CATCHBASIN & PERFORATED SUBDRAIN PER S29, S30, S31
 - RYCBMH: PROPOSED REAR YARD CATCHBASIN MANHOLE & LEAD
 - RYCB: PROPOSED REAR YARD CATCHBASIN & LEAD
 - CB: PROPOSED ROAD CATCHBASIN
 - EXISTING 1.8m CONCRETE SIDEWALK
 - DRAINAGE EASEMENT
 - EXISTING FENCE - CHAINLINK
 - SIDEWALK REINSTATEMENT FOR DEPRESSED CURBS
 - UTILITY EASEMENT
 - PROPOSED OVERLAY

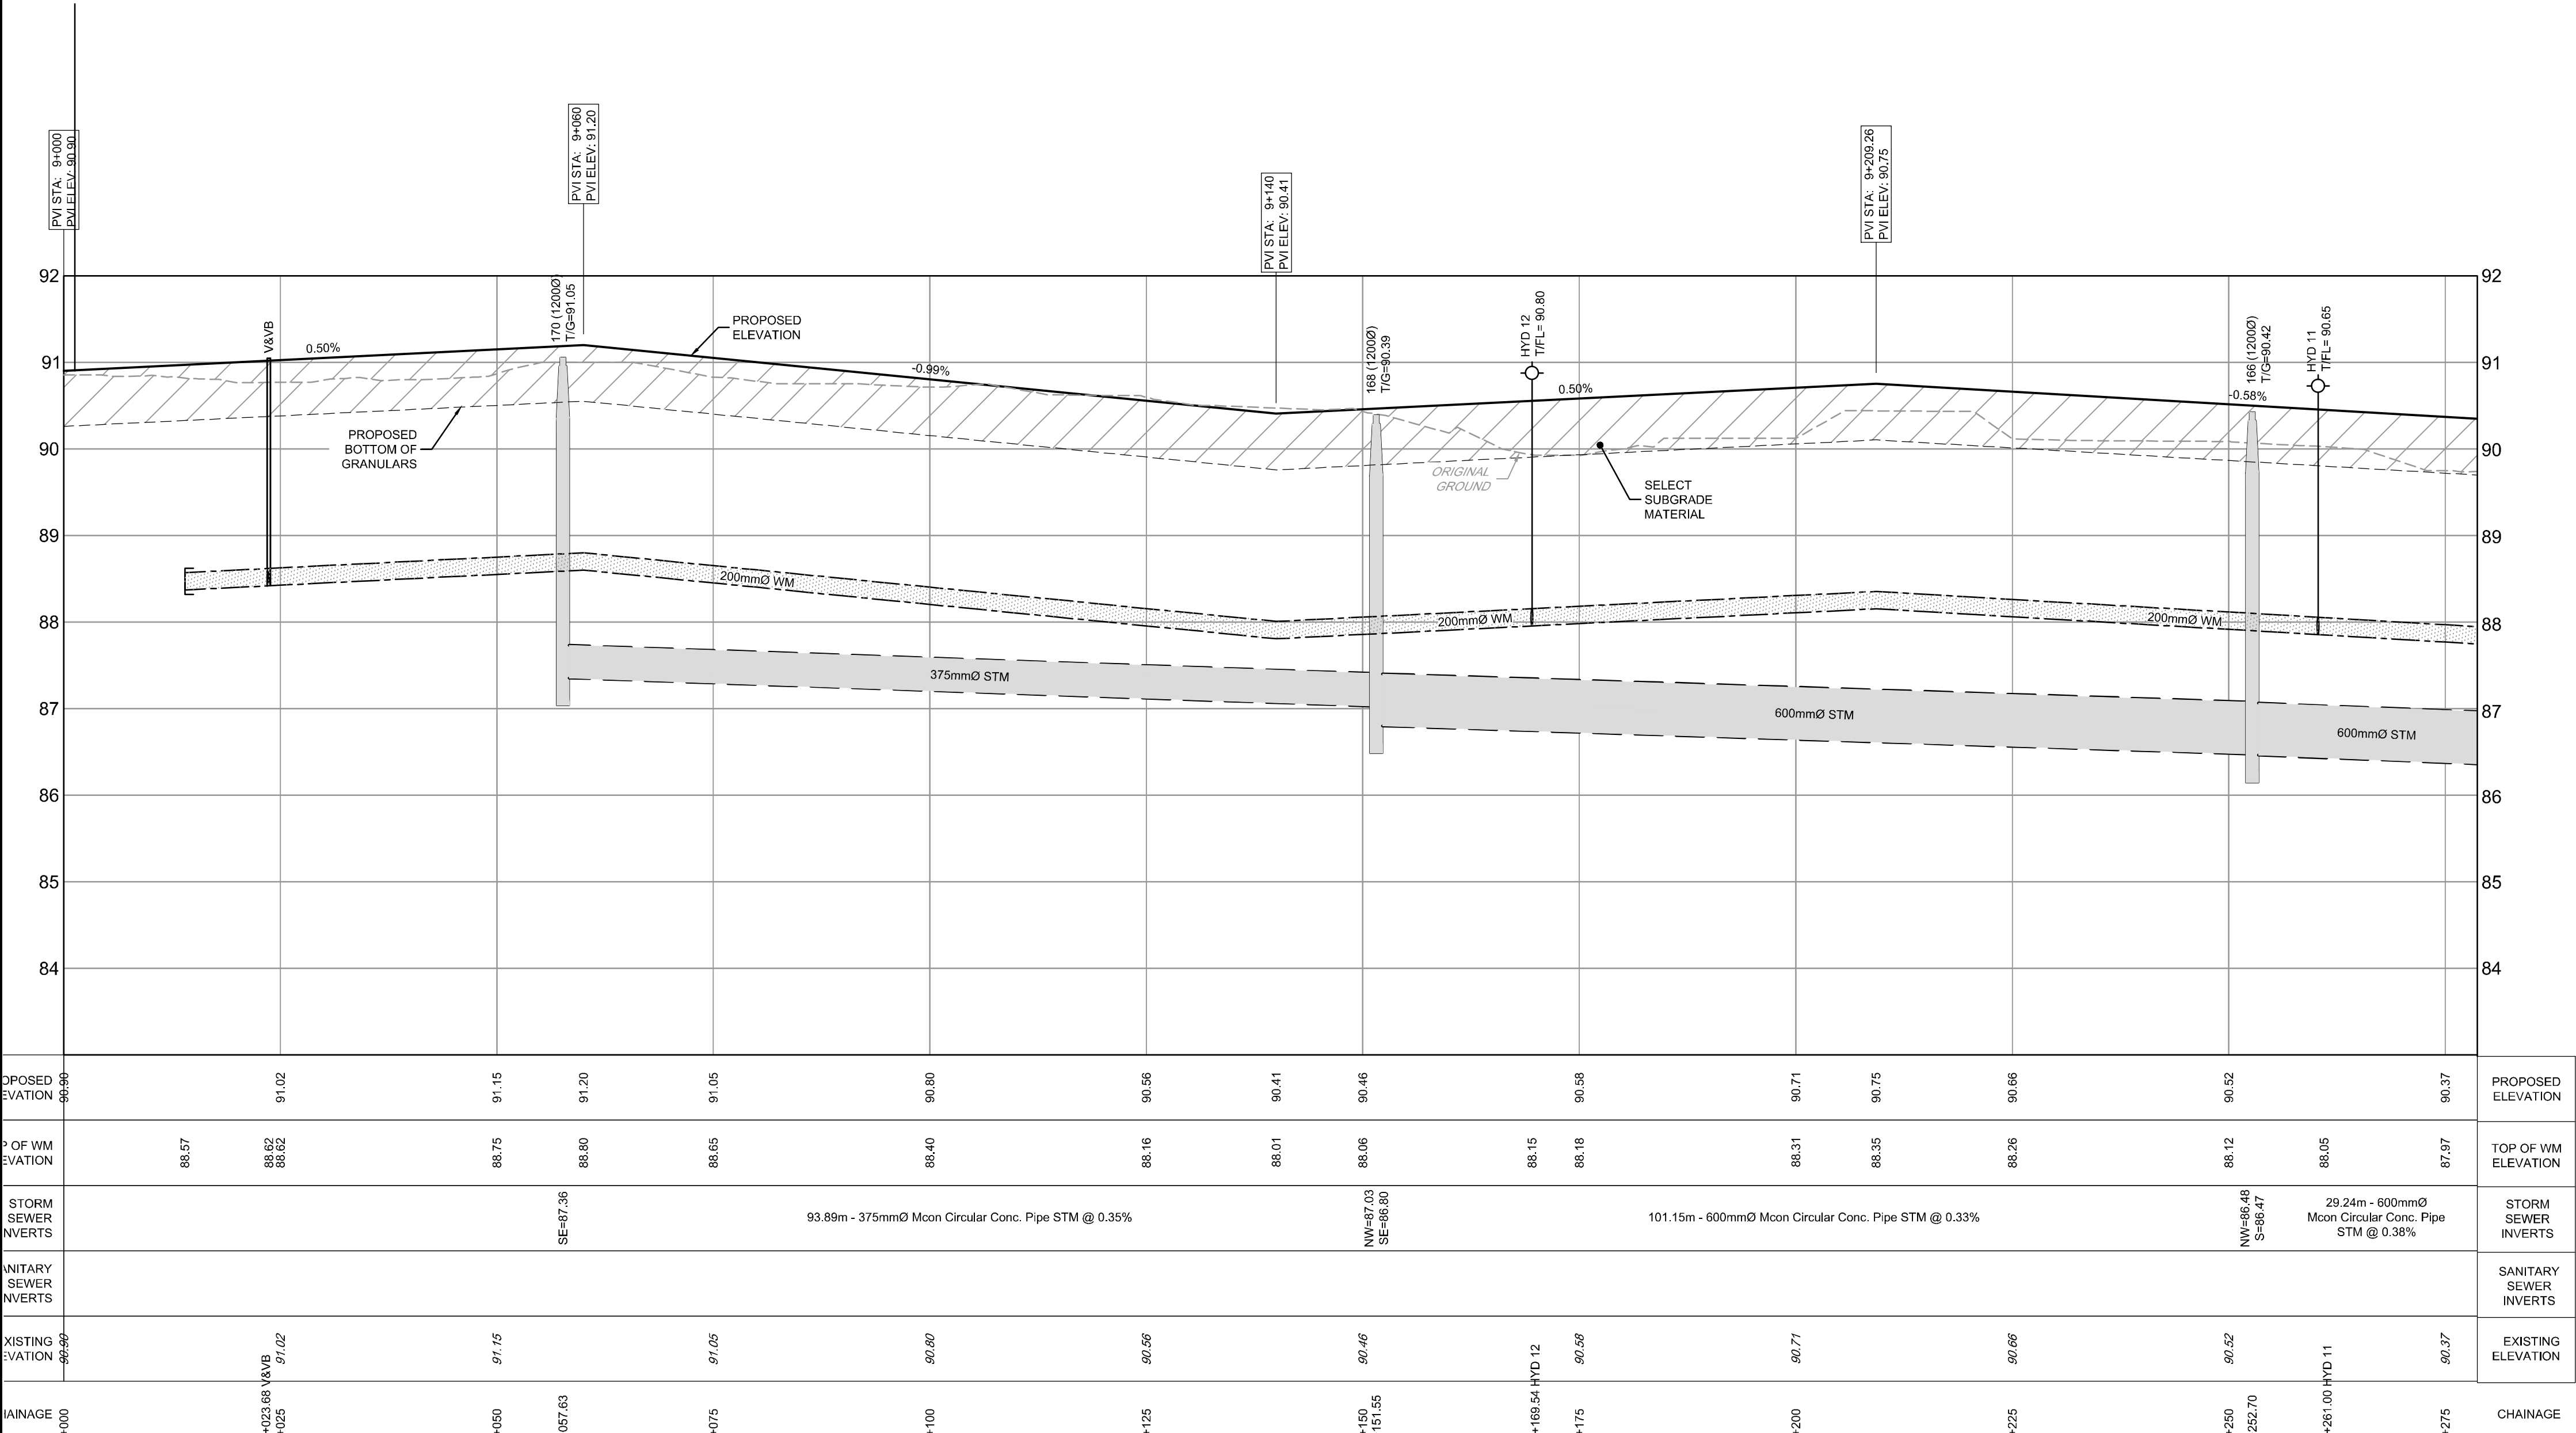


NOTE:
THE POSITION OF ALL POLE LINES, CONDUITS, WATERMAINS, SEWERS AND OTHER UNDERGROUND AND OVERGROUND UTILITIES AND STRUCTURES IS NOT NECESSARILY SHOWN ON THE CONTRACT DRAWINGS, AND WHERE SHOWN, THE ACCURACY OF THE POSITION OF SUCH UTILITIES AND STRUCTURES IS NOT GUARANTEED. BEFORE STARTING WORK, DETERMINE THE EXACT LOCATION OF ALL SUCH UTILITIES AND STRUCTURES AND ASSUME ALL LIABILITY FOR DAMAGE TO THEM.

PRELIMINARY

No.	REVISION	DATE	BY
2.	ISSUED FOR REVIEW	JUN 18/21	BHB
1.	ISSUED FOR DISCUSSION	MAR 5/21	BHB

SCALE

 1 : 500



DESIGN	FOR REVIEW ONLY
DJC	
BCS	
DJC	
BCS	
BHB	



NOVATECH
Engineers, Planners & Landscape Architects
Suite 200, 240 Michael Cowpland Drive
Ottawa, Ontario, Canada K2M 1P6
Telephone: (613) 254-9643
Facsimile: (613) 254-5867
Website: www.novatech-eng.com

LOCATION
CITY OF OTTAWA
THE COMMONS
DRAWING NAME
PLAN AND PROFILE
STREET 9
STATION 9+000 TO 9+275

PROJECT No.	118224-00
REV	REV # 2
DRAWING No.	118224-PR10