

LEGEND:

PROPERTY LINE	UTILITY POLE	(H)	HYDRO METER BOX LOCATION	(●)	PROPOSED DECIDUOUS TREE
JOINT UTILITY TRENCH	ROGERS PEDESTAL	(H ₃)	HYDRO GANG METER LOCATION	(○)	PROPOSED SIDEWALK REINSTATEMENT
COMMUNICATIONS TRENCH	ROGERS GRADE LEVEL BOX	(G)	GAS METER BOX LOCATION	(□)	DRAINAGE EASEMENT
HYDRO SECONDARY	BELL PEDESTAL	(◇)	PROPOSED HYDRANT LOCATION	(□)	UTILITY EASEMENT
GAS MAIN	BELL CENTRAL SPLIT POINT	(◇)	PROPOSED ROAD CATCHBASIN	(○)	EXISTING TREE TO REMAIN IF POSSIBLE
STREETLIGHT CABLE AND DUCT	BELL GRADE LEVEL BOX	(◇)	PROPOSED REARYARD CATCHBASIN	(○)	PROPOSED OVERLAY
1 PHASE PADMOUNT HYDRO TRANSFORMER	PROPOSED ROAD CROSSING	(●)	PROPOSED SANITARY MANHOLE	(○)	
HYDRO PRIMARY PEDESTAL	2 STREET LIGHT	(○)	PROPOSED STORM MANHOLE	(○)	
6x12 PRECAST MANHOLE	1 HYDRO	(○)	SERVICE LOCATION	(○)	
STREETLIGHT	1 ROGERS	(○)			
STREETLIGHT DISCONNECT	1 BELL	(○)			
PROPOSED STREETLIGHT GROUNDING ROD	1 GAS	(○)			
	CONCRETE ENCASED	(○)			
	DIRECT BURIED	(○)			
	DEPRESSED CURB	(○)			
	COMMUNITY MAILBOX	(○)			


COMPOSITE UTILITY PLAN TO BE READ IN CONJUNCTION WITH:
-HYDRO OTTAWA PLANS, REF NO. XXX
-BELL PLANS, REF NO. XXX
-ROGERS PLANS, REF NO. XXX
-ENBRIDGE PLANS, REF NO. XXX
-STREETLIGHTING PLAN, 118224-SL
-LANDSCAPE PLANS,

ALL FOOTPRINTS SHOWN ARE CONCEPTUAL. REFER TO INDIVIDUAL SITING PLANS FOR FINAL MODEL FOOTPRINT

NORTH

KEY PLAN
N.T.S.

SITE BENCHMARK
REFERENCED TO LOCAL
GEODETIC DATUM

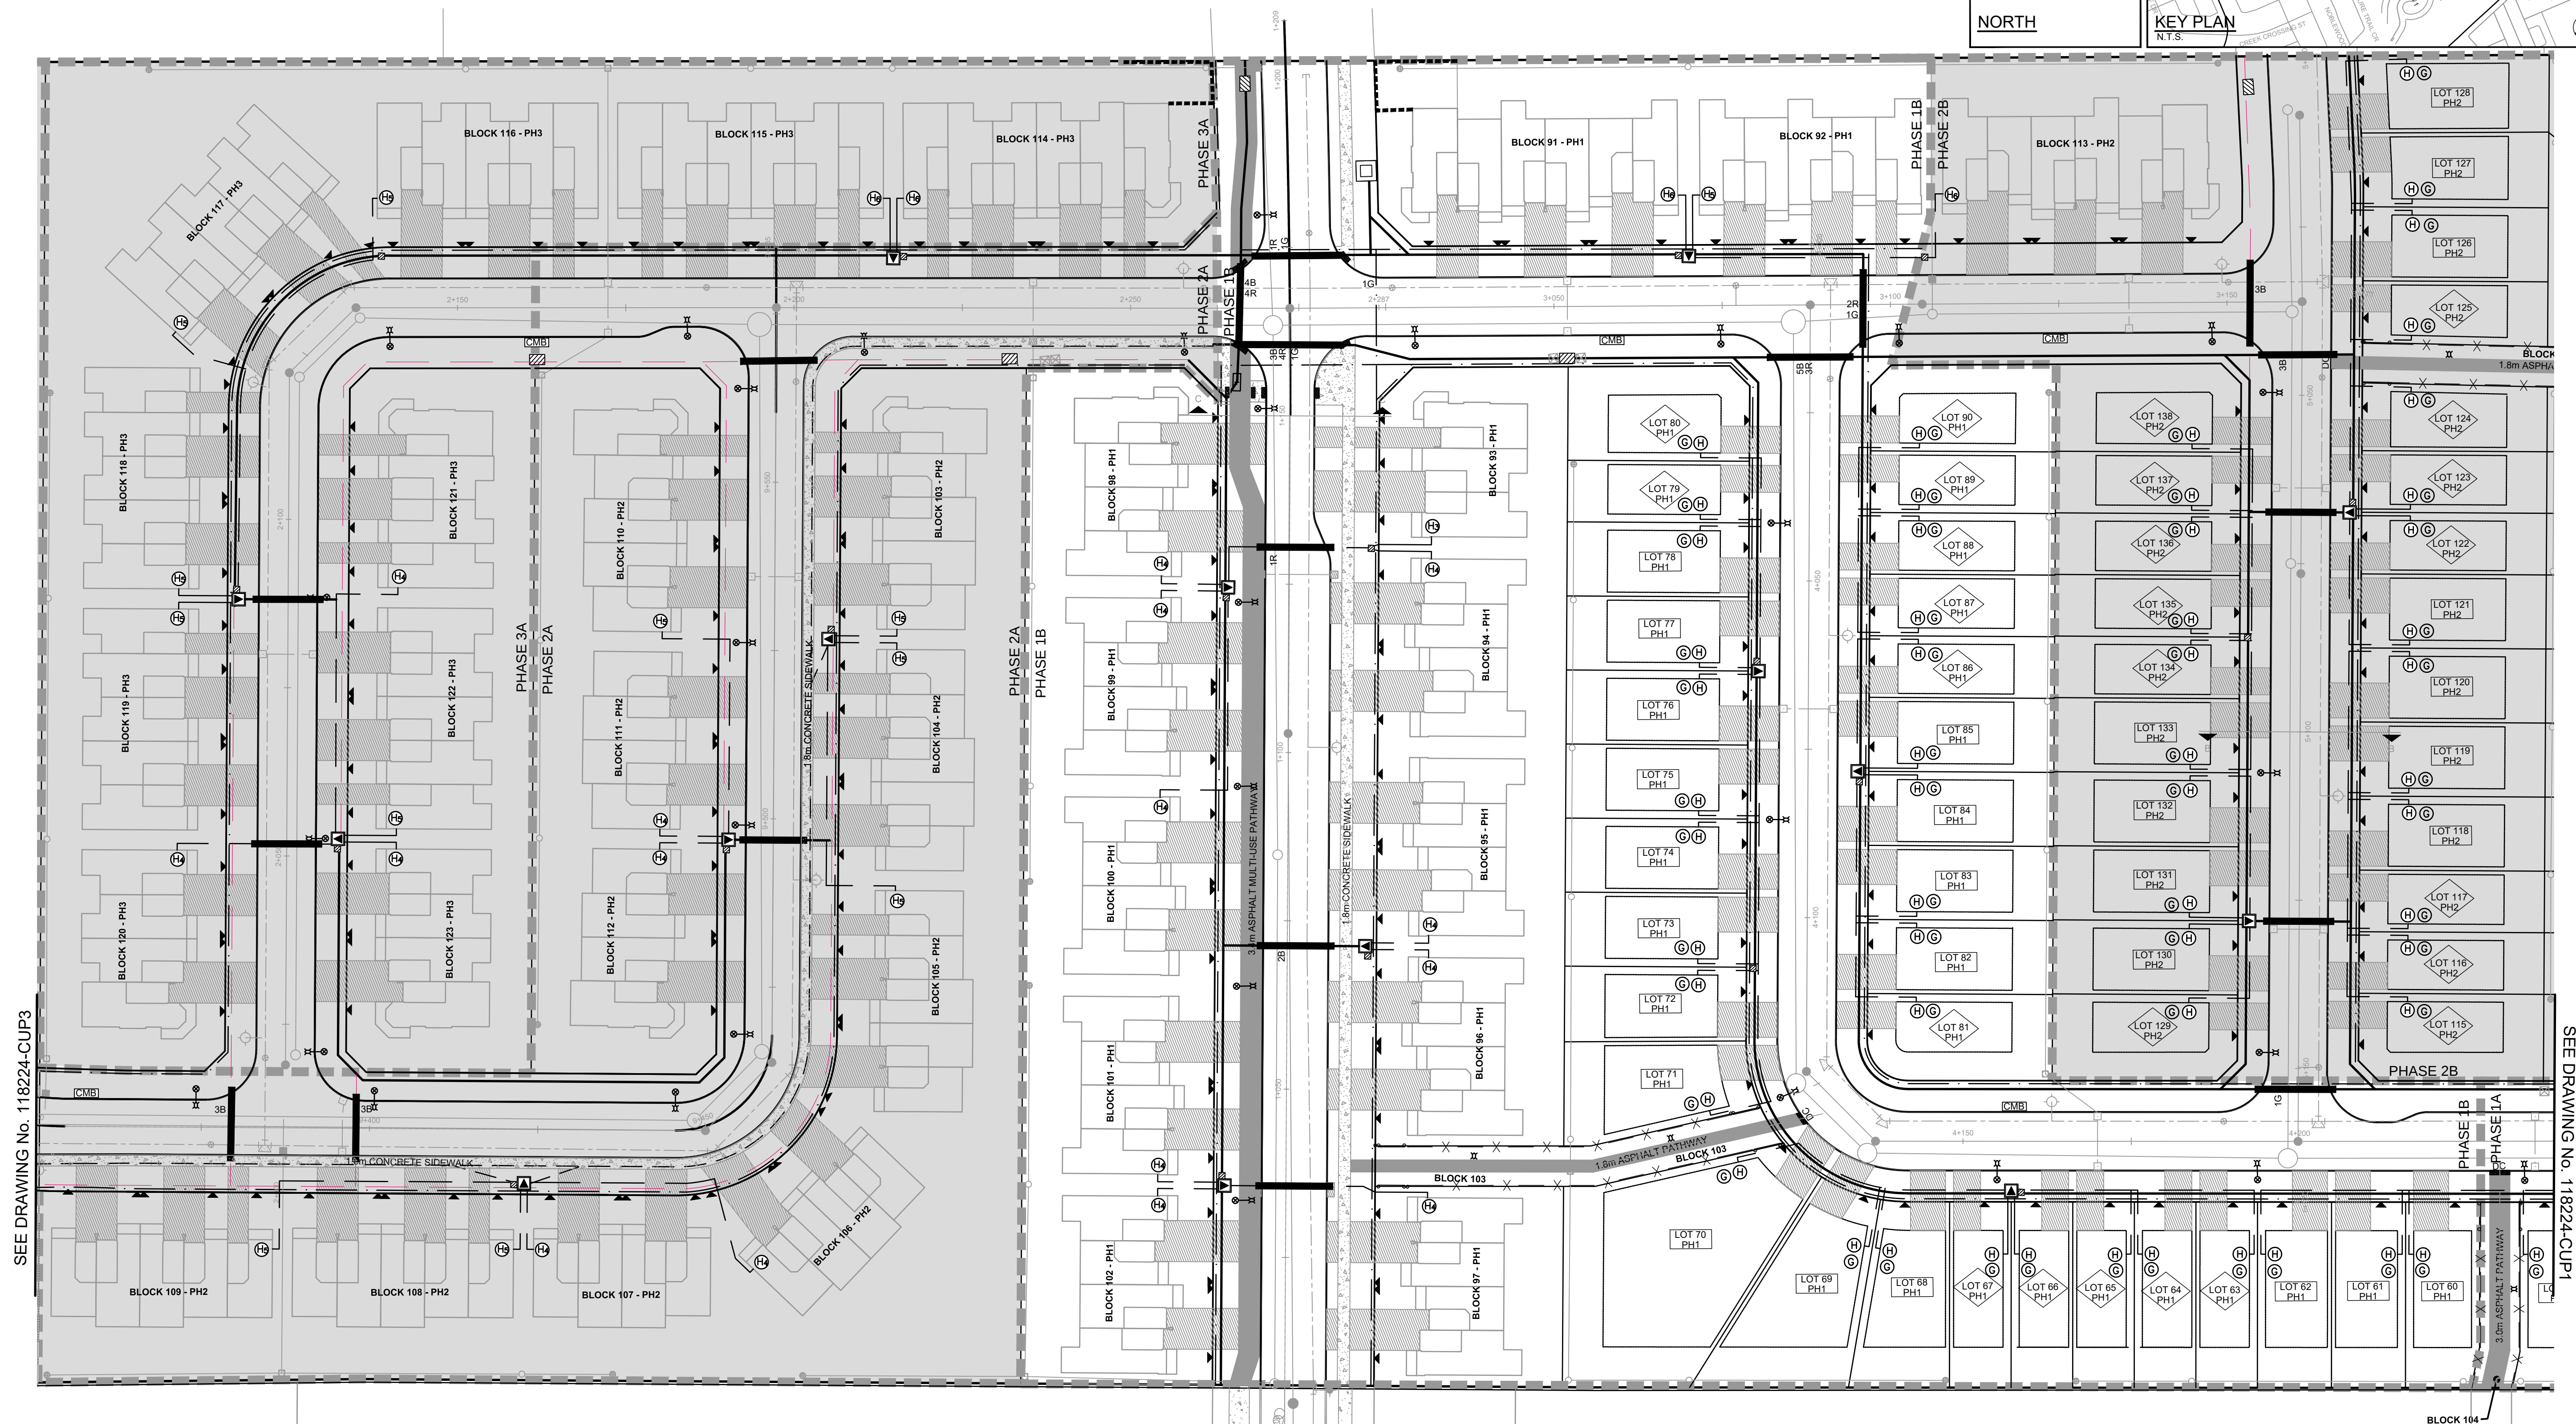

C:\temp\p\publish_120881_18224-CUP2.dwg, 118224-CUP2, Jun 21, 2021, 1:38pm, breed

NOTE:
THE POSITION OF ALL POLE LINES, CONDUITS, WATERMANS, SEWERS AND OTHER UNDERGROUND AND OVERGROUND UTILITIES AND STRUCTURES IS NOT NECESSARILY SHOWN ON THE CONTRACT DRAWINGS, AND WHERE SHOWN, THE ACCURACY OF THE POSITION OF SUCH UTILITIES AND STRUCTURES IS NOT GUARANTEED. BEFORE STARTING WORK, DETERMINE THE EXACT LOCATION OF ALL SUCH UTILITIES AND STRUCTURES AND ASSUME ALL LIABILITY FOR DAMAGE TO THEM.

PRELIMINARY

REFER TO 118224-XS1 AND 118224-XS2 FOR TYPICAL ROAD CROSS SECTIONS

REFER TO 118224-ND FOR ADDITIONAL NOTES & DETAILS

No.	REVISION	DATE	BY
1.	ISSUED FOR REVIEW	JUNE 18/21	BHB

SCALE

1:500

0 5 10 15 20

DESIGN	BR
CHECKED	BCS
DRAWN	BR
CHECKED	BCS
APPROVED	BHB

FOR REVIEW ONLY



NOVATECH
Engineers, Planners & Landscape Architects
Suite 200, 240 Michael Cowpland Drive
Ottawa, Ontario, Canada K2M 1P6
Telephone (613) 254-9643
Facsimile (613) 254-5867
Website www.novatech-eng.com

LOCATION
CITY OF OTTAWA
THE COMMONS

DRAWING NAME

COMPOSITE UTILITY PLAN

SEE DRAWING No. 118224-CUP1

PROJECT No.	118224-00
REV	REV # 1
DRAWING No.	118224-CUP2