

M:\2018\118224\CADD\Design\118224-PR.dwg, PR15, Nov 24, 2021 - 9:20pm, bresad

 
NOTE:
THE POSITION OF ALL POLE LINES, CONDUITS,
WATERMAINS, SEWERS AND OTHER
UNDERGROUND AND OVERGROUND UTILITIES AND
STRUCTURES IS NOT NECESSARILY SHOWN ON
THE CONTRACT DRAWINGS, AND WHERE SHOWN,
THE ACCURACY OF THE POSITION OF SUCH
UTILITIES AND STRUCTURES IS NOT GUARANTEED.
BEFORE STARTING WORK, DETERMINE THE EXACT
LOCATION OF ALL SUCH UTILITIES AND
STRUCTURES AND ASSUME ALL LIABILITY FOR
DAMAGE TO THEM.

PRELIMINARY

No.	REVISION	DATE	BY
2.	REVISED AND REISSUED FOR REVIEW	NOV 26/21	BHB
1.	ISSUED FOR REVIEW	JUN 18/21	BHB

SCALE

1 : 500



DESIGN	DJC
CHECKED	BCS
DRAWN	DJC
CHECKED	BCS
APPROVED	BHB

FOR REVIEW ONLY



NOVATECH

Engineers, Planners & Landscape Architects
Suite 200, 240 Michael Cowpland Drive
Ottawa, Ontario, Canada K2M 1P6


Telephone (613) 254-9643
Facsimile (613) 254-5867
Website www.novatech-eng.com

LOCATION
CITY OF OTTAWA
THE COMMONS


DRAWING NAME

PLAN AND PROFILE
ULTIMATE POND OUTLET
STATION 10+263.57 TO 10+470.67

PROJECT No.	118224-00
REV	REV # 2
DRAWING No.	118224-PR15

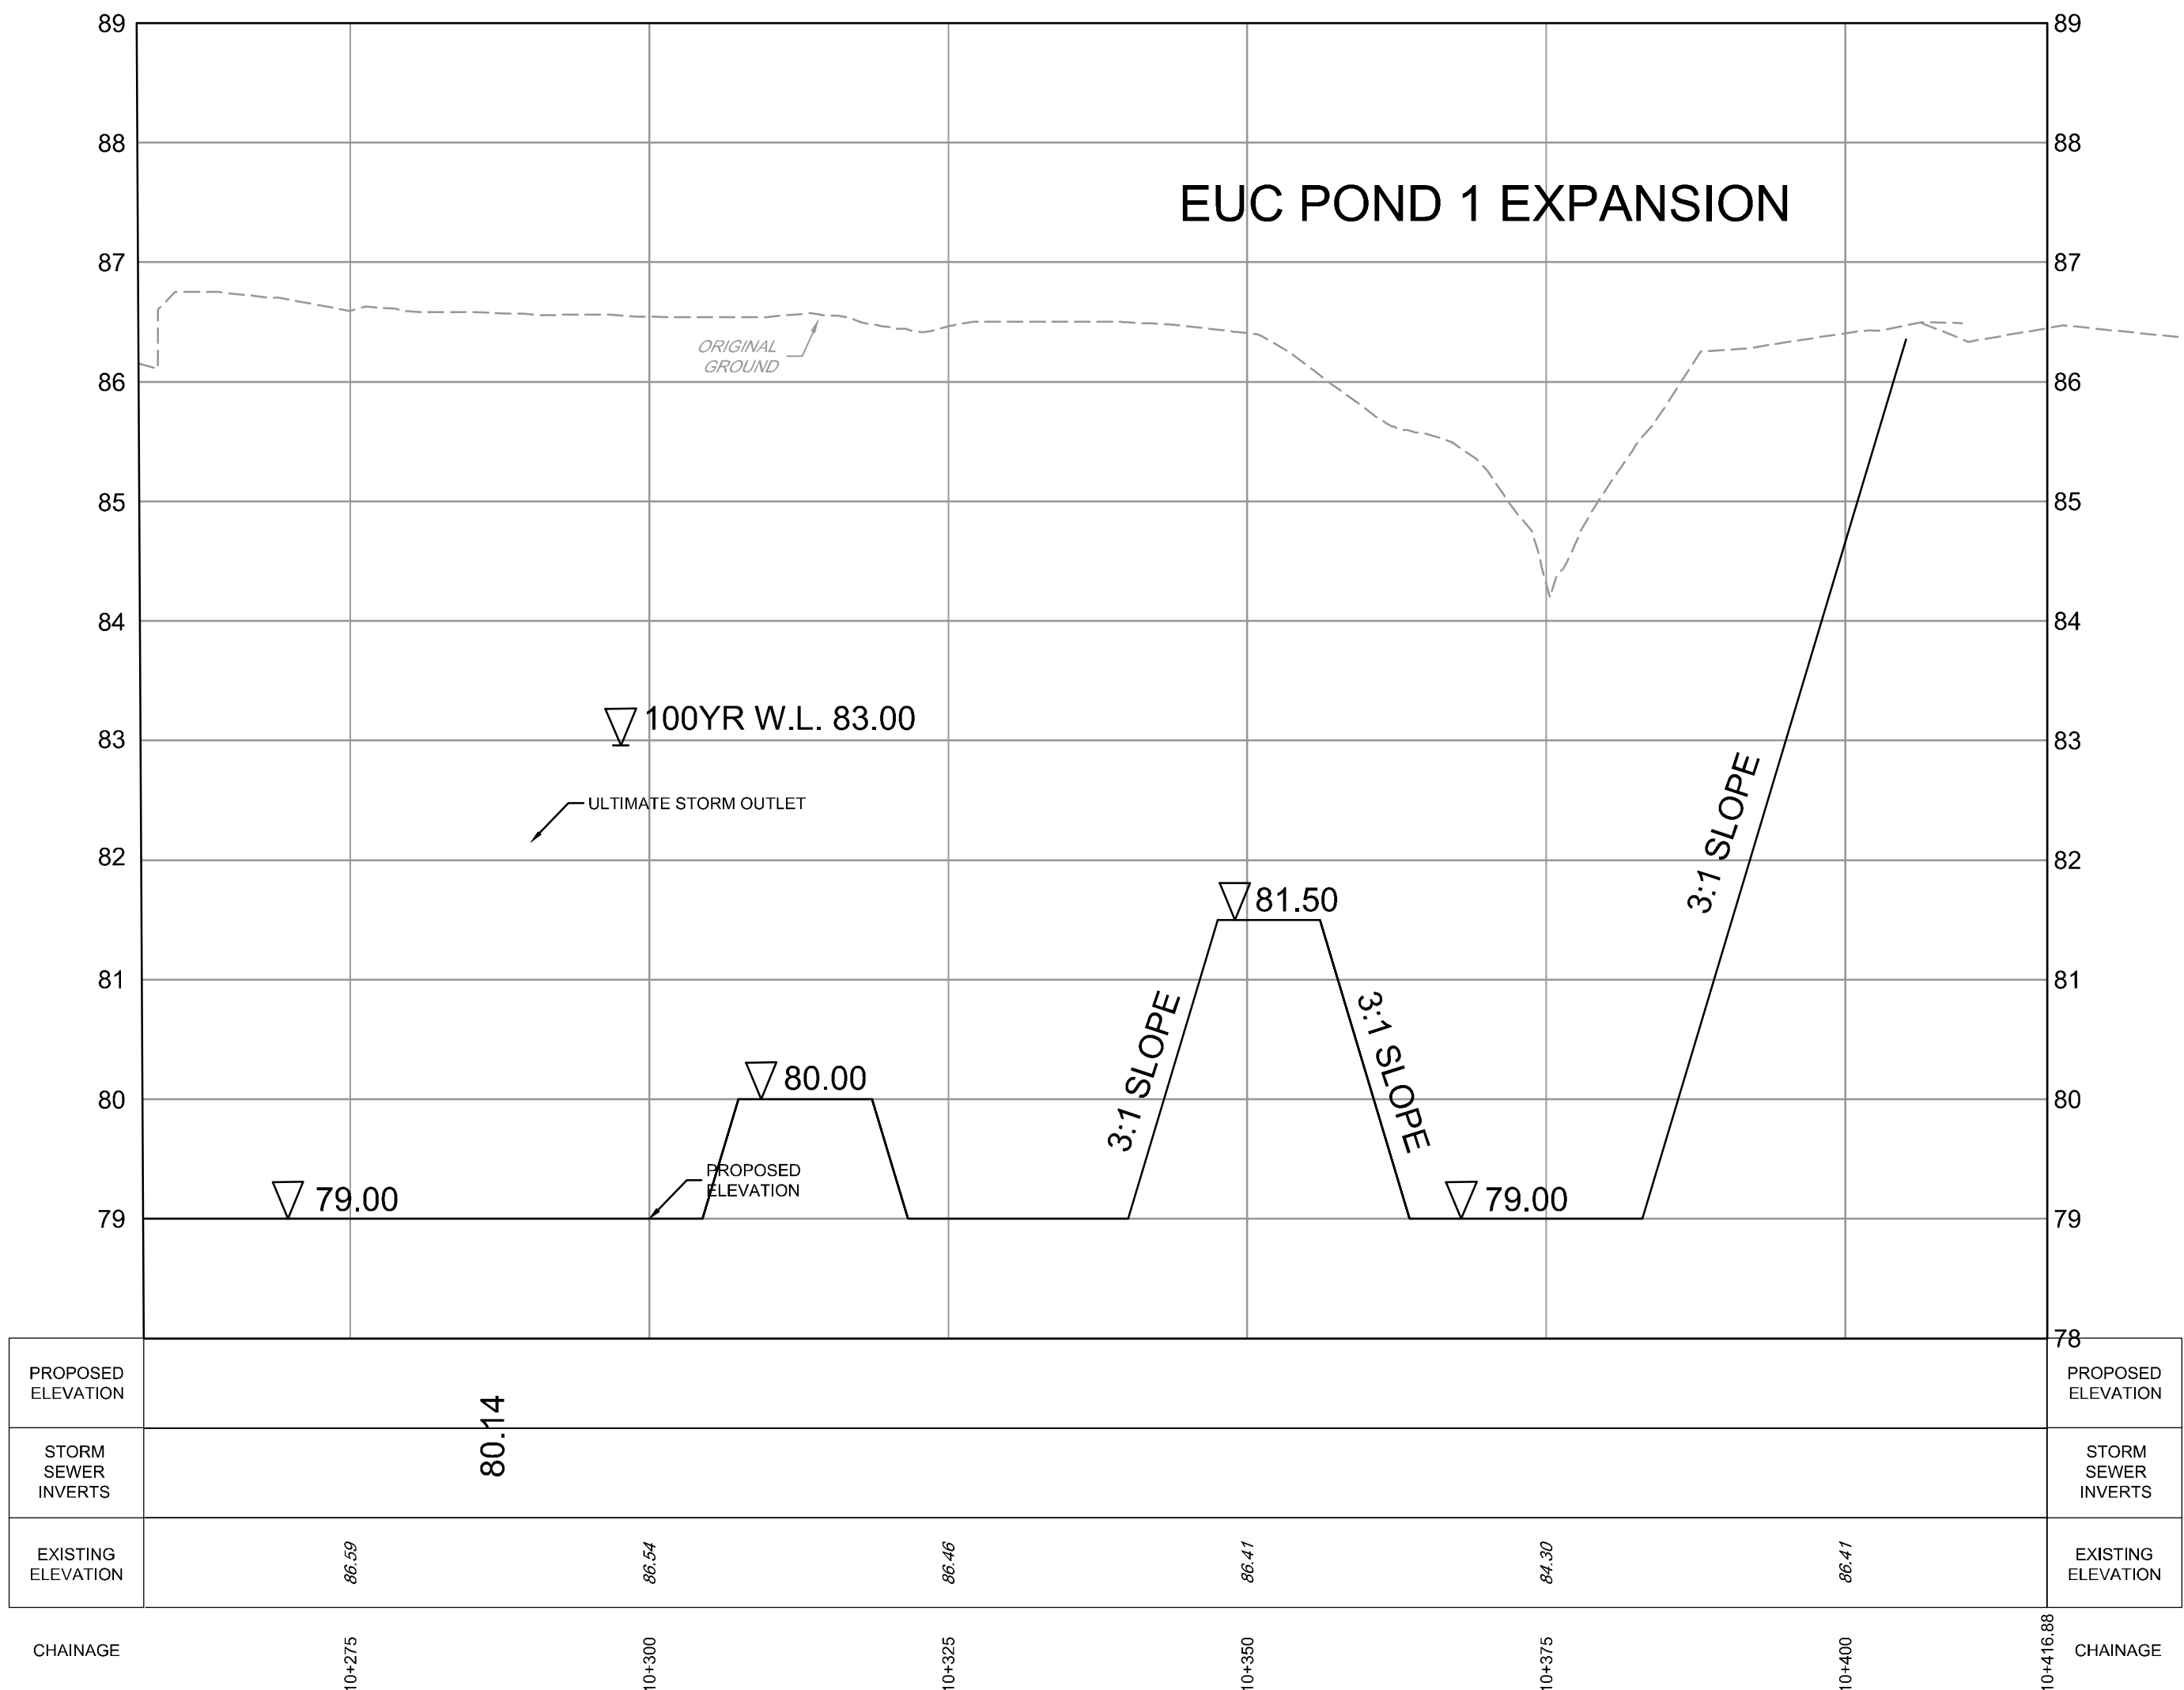

PROPOSED ELEVATION	80.14	78
STORM SEWER INVERTS		
EXISTING ELEVATION	86.59, 86.54, 86.46, 86.41, 84.30, 86.41	EXISTING ELEVATION

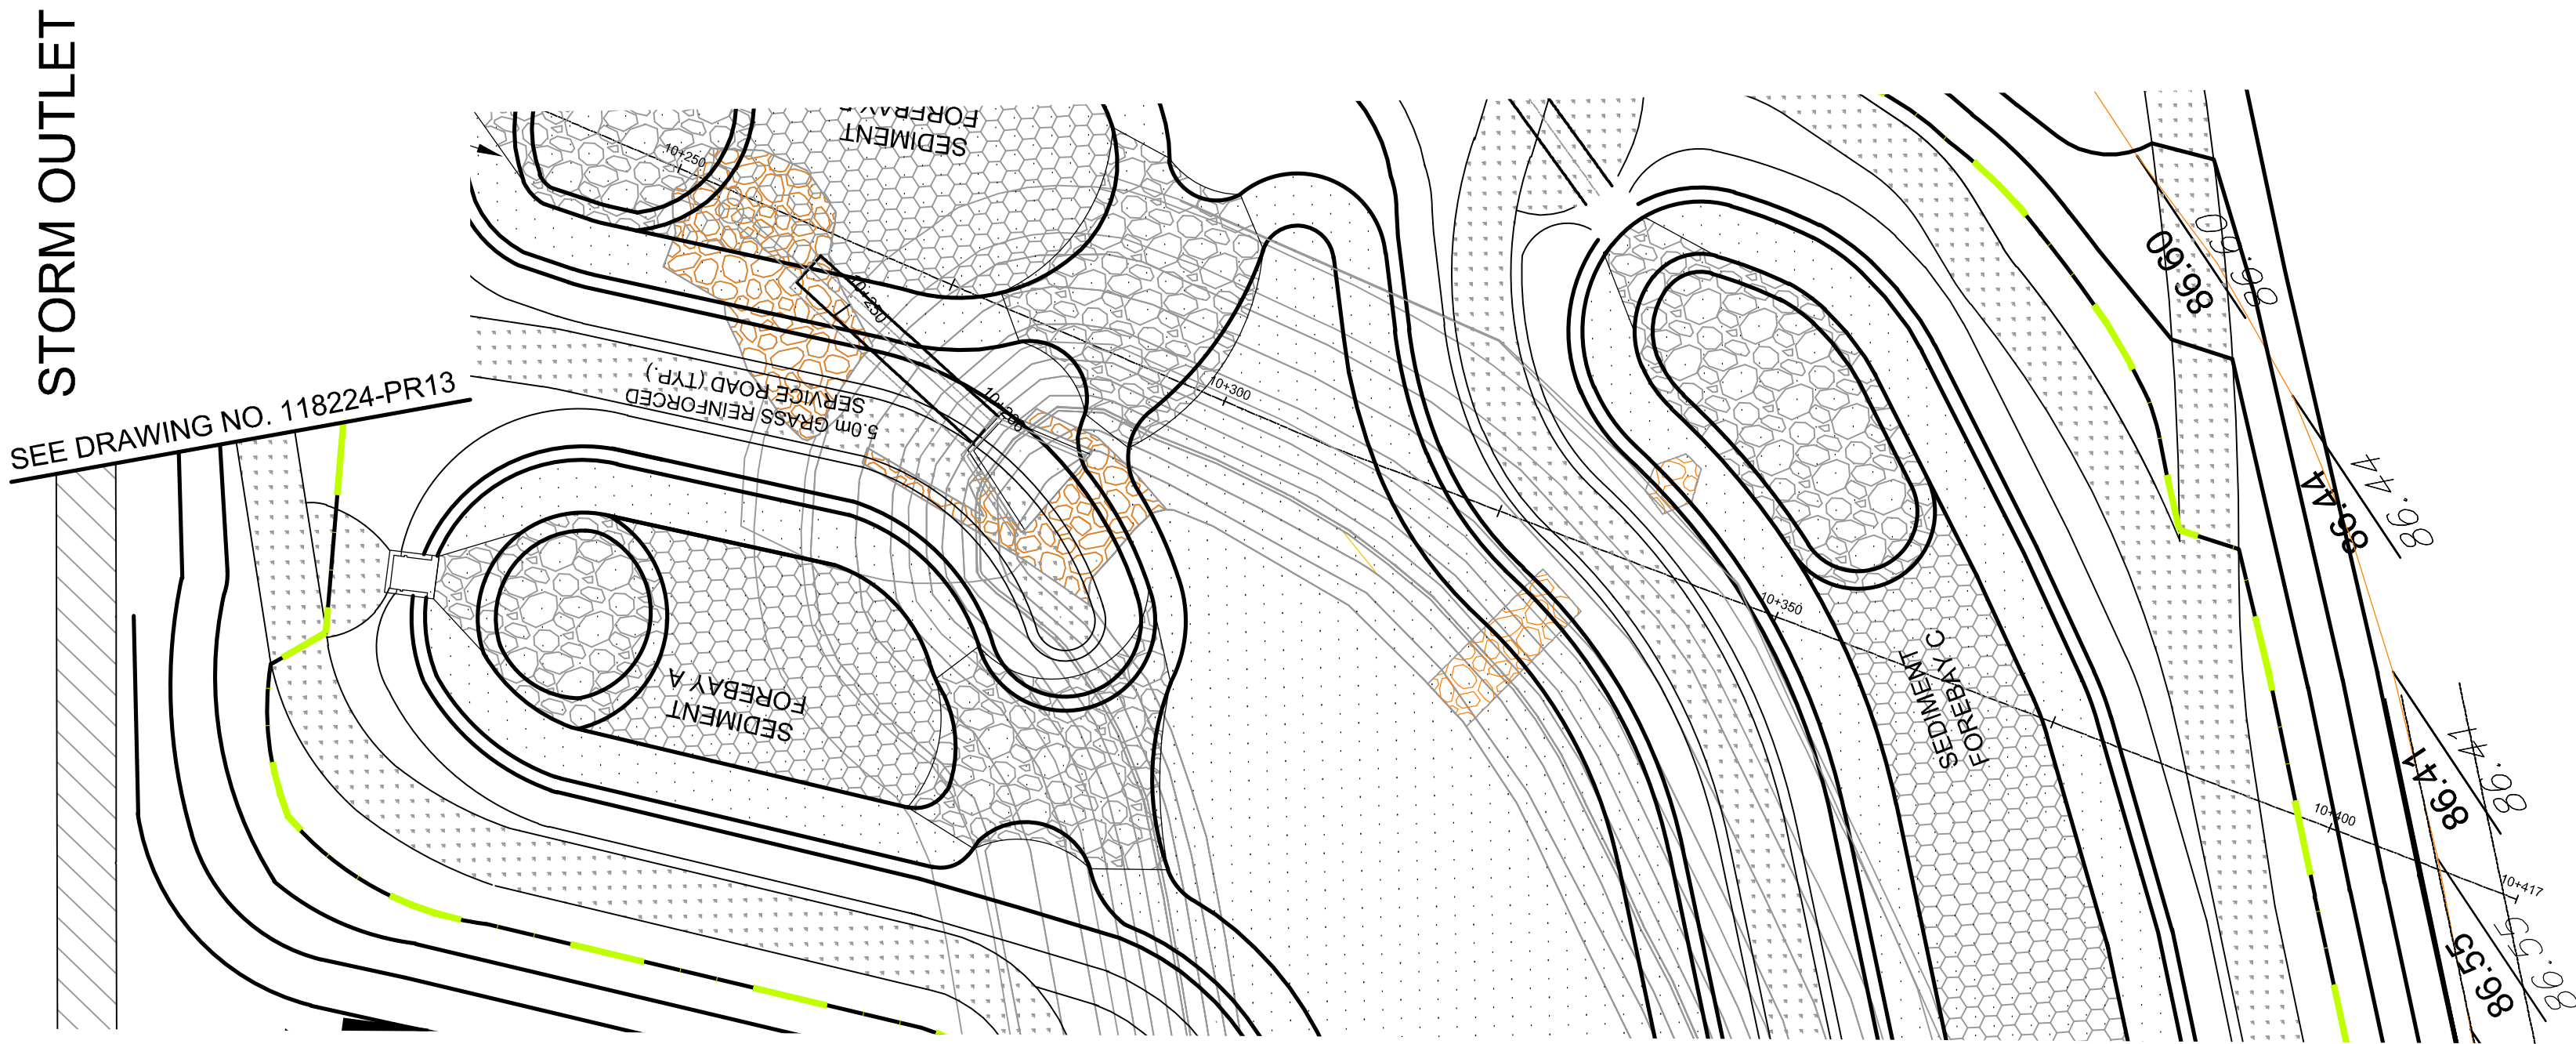

LEGEND

- 200mm Ø WM
- V&VB
- HYD
- T/F=98.45
- BEND
- PROPOSED WATERMAIN
- PROPOSED VALVE LOCATION
- VALVE & VALVE BOX
- PROPOSED HYDRANT C/W VALVE & LEAD
- PROPOSED TOP OF BOTTOM FLANGE
- PROPOSED BEND AND THRUSTBLOCK
- 11.25°, 22.5°, 45° or TEE (SEE PLAN AND PROFILES)
- SERVICE CONNECTION STUB (SINGLE)
- 100mm STORM @1.0%
- 19mm WATER
- 125mm SANITARY @1.0%
- PROPOSED SANITARY MH & SEWER
- PROPOSED STORM MH & SEWER
- LYCB
- LYCB
- RYCBMH
- RYCB
- CB
- DIRECTION OF FLOW
- EXISTING 1.8m CONCRETE SIDEWALK
- DRAINAGE EASEMENT
- EXISTING FENCE - CHAINLINK
- SIDEWALK REINSTATEMENT FOR DEPRESSED CURBS
- UTILITY EASEMENT
- PROPOSED OVERLAY

LEGEND

- BH 19.17, 91.92
- BOREHOLE LOCATION
- FILL
- TOP SOIL
- SAND
- CLAYEY SILT
- SILTY CLAY
- GLACIAL TILL
- WEATHERED BEDROCK

D07-16-19-0027 #185335