

LEGEND

- 200mmØ WM

PROPOSED WATERMAIN

V&VB

VALVE & VALVE BOX

V&VC

VALVE & VALVE CHAMBER

HYD

PROPOSED HYDRANT C/W VALVE & LEAD

T/F=98.45

PROPOSED TOP OF BOTTOM FLANGE

BEND

PROPOSED BEND AND THRUSTBLOCK
11.25', 22.5', 45' or TEE
(SEE PLAN AND PROFILES)

S

PROPOSED SANITARY MH & SEWER

S

PROPOSED STORM MH & SEWER

PROPOSED LANDSCAPE TEE CATCHBASIN & PERFORATED SUBDRAIN

PROPOSED LANDSCAPE ELBOW CATCHBASIN & PERFORATED SUBDRAIN

PROPOSED REAR YARD CATCHBASIN
MANHOLE & LEAD

PROPOSED REAR YARD CATCHBASIN & LEAD

FENCE - PRIVACY

FENCE - CHAINLINK

FENCE - POST AND RAIL

CRITICAL PIPE CROSSING LOCATION.
SEE TABLE FOR DATA

SERVICE CONNECTION STUB

100mm STORM @ 1.0%

19mm WATER

125mm SANITARY @ 1.0%

PROPOSED ROAD CATCHBASIN


PROPOSED CURB INLET CATCHBASIN

DIRECTION OF FLOW

NORTH

KEY PLAN
N.T.S.

SITE BENCHMARK
REFERENCED TO LOCAL
GEODETIC DATUM

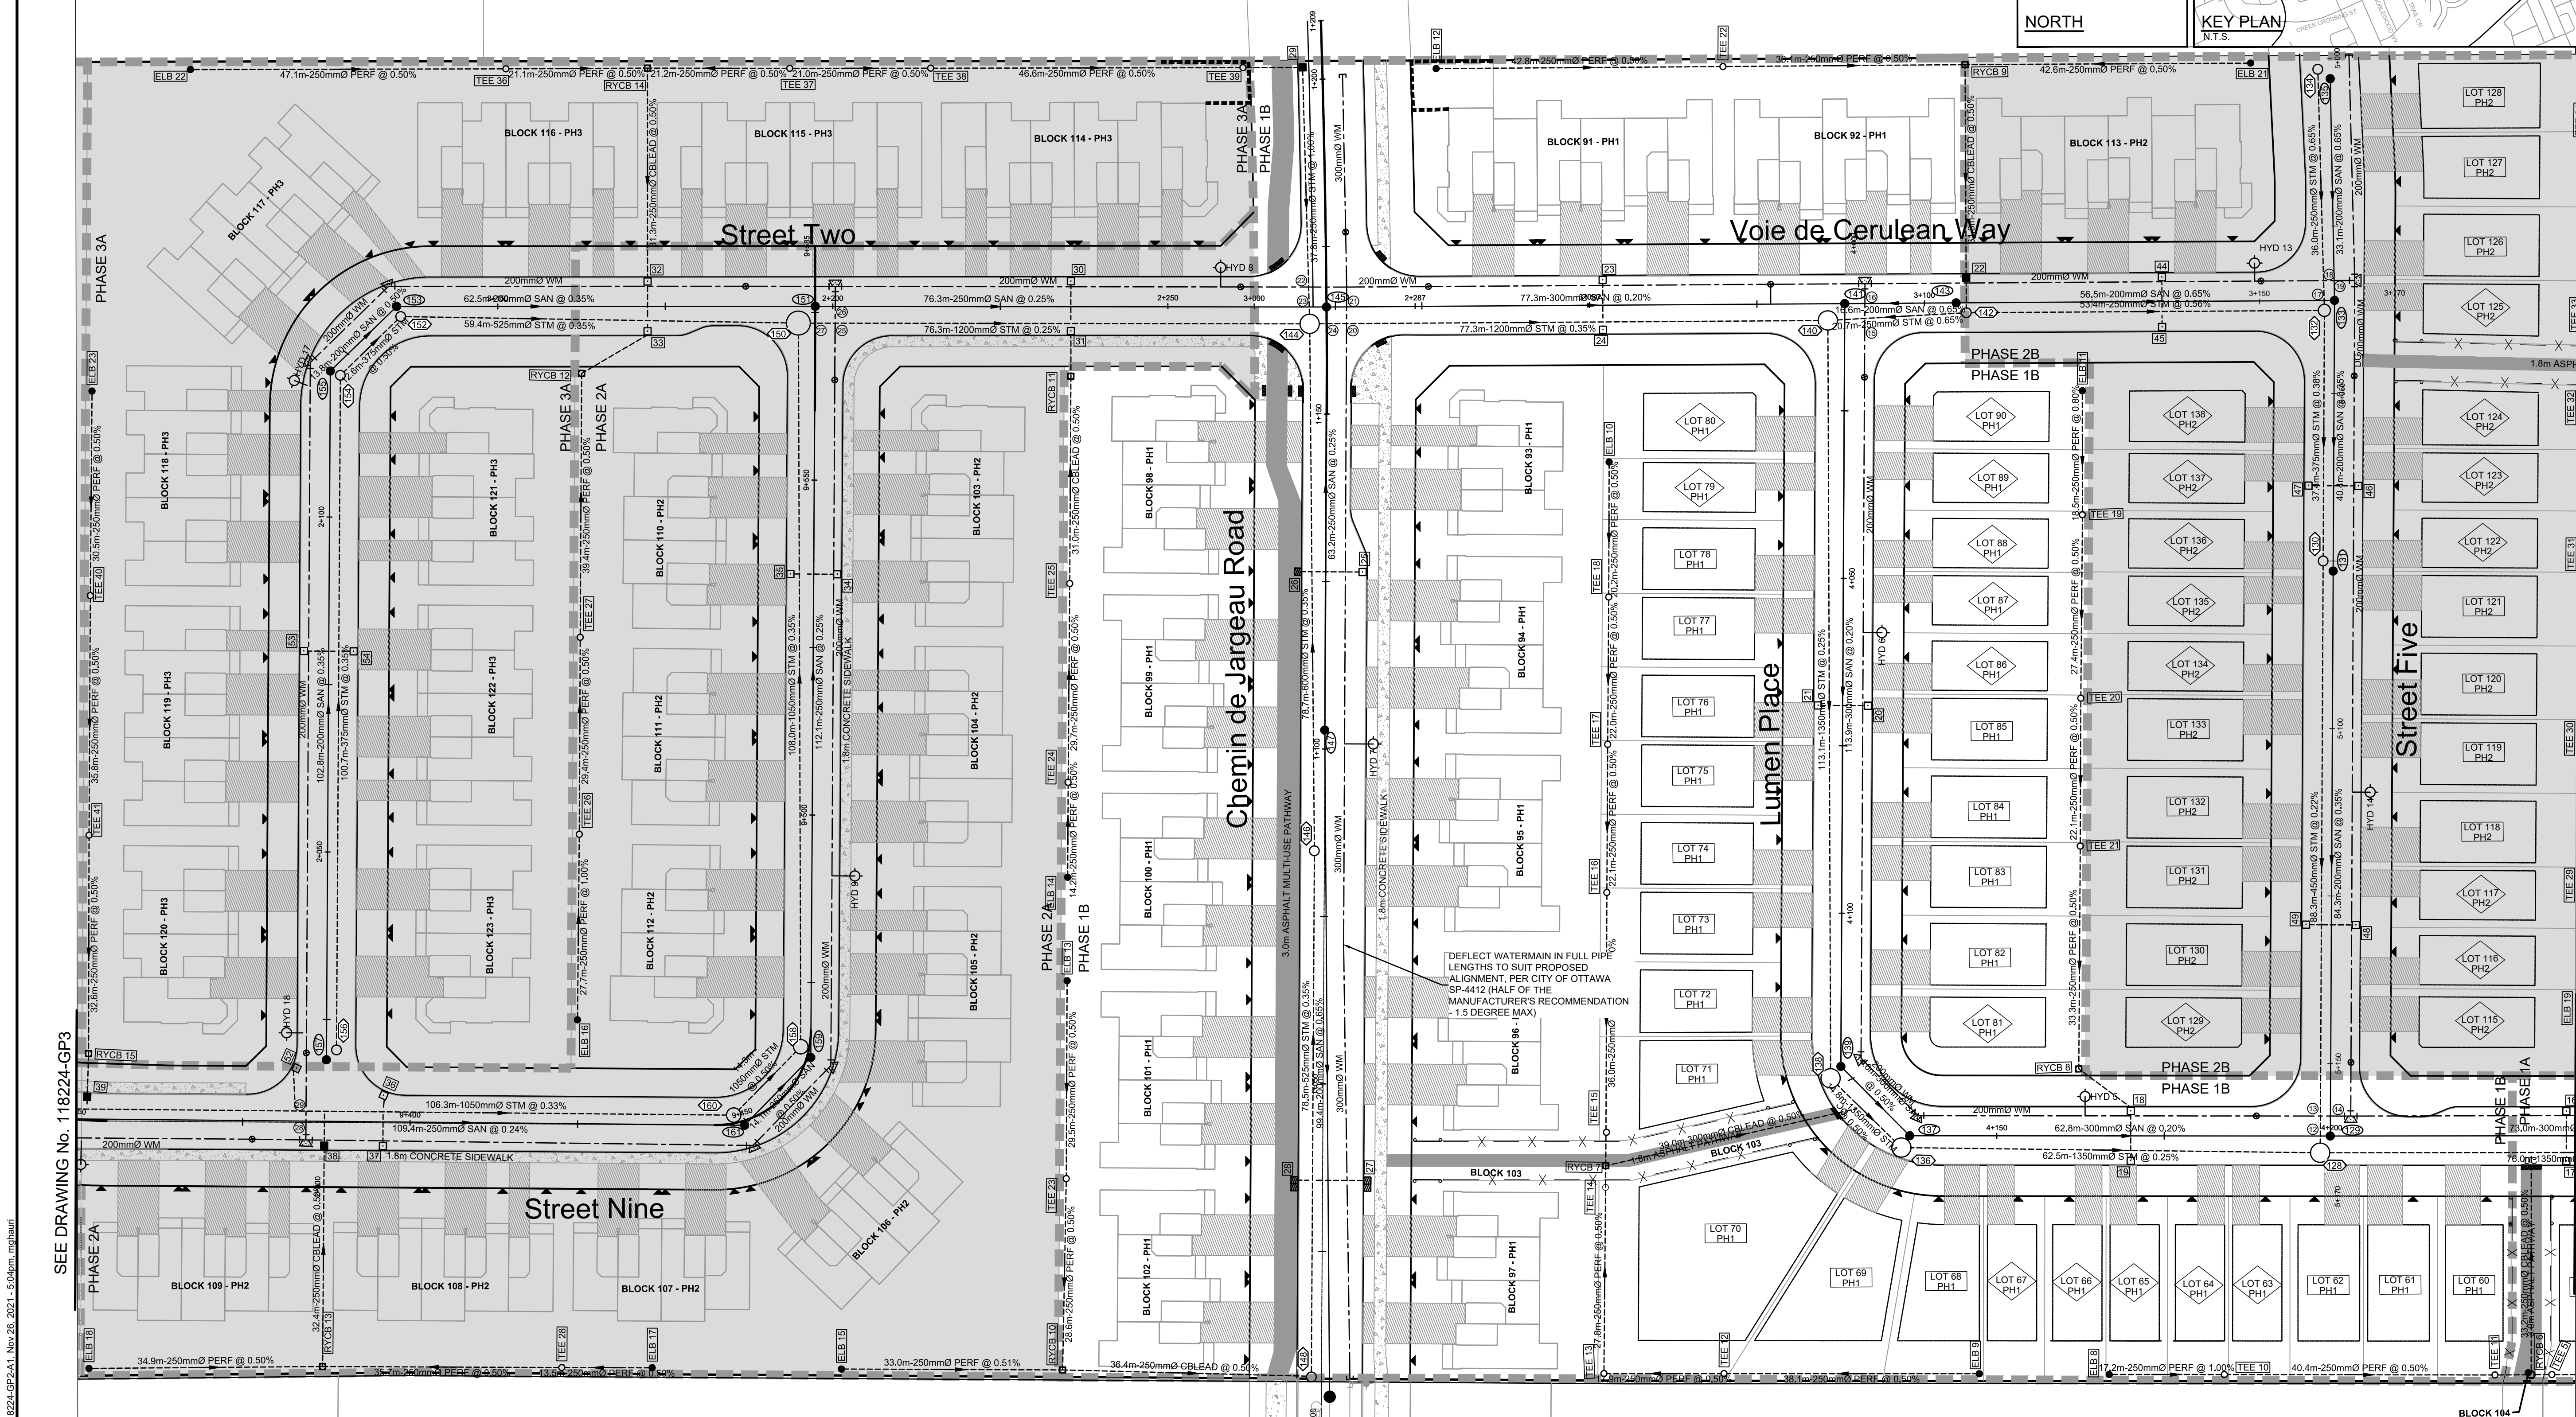


NOTE:
THE POSITION OF ALL POLE LINES, CONDUITS,
WATERMAINS, SEWERS AND OTHER
UNDERGROUND AND OVERGROUND UTILITIES AND
STRUCTURES IS NOT NECESSARILY SHOWN ON
THE CONTRACT DRAWINGS, AND WHERE SHOWN,
THE ACCURACY OF THE POSITION OF SUCH
UTILITIES AND STRUCTURES IS NOT GUARANTEED.
BEFORE STARTING WORK, DETERMINE THE EXACT
LOCATION OF ALL SUCH UTILITIES AND
STRUCTURES AND ASSUME ALL LIABILITY FOR
DAMAGE TO THEM.

PRELIMINARY

No.	REVISION	DATE	BY
6.	REVISED AND REISSUED FOR REVIEW	NOV 26/21	BHB
5.	ISSUED FOR REVIEW	JUN 18/21	BHB
4.	ISSUED FOR DISCUSSION	MAR 5/21	BHB
3.	REVISED AND REISSUED FOR DRAFT PLAN APPROVAL	NOV 27/20	BHB
2.	REVISED AND REISSUED FOR DRAFT PLAN APPROVAL	APR 3/20	BHB
1.	DRAFT PLAN	OCT 4/19	BHB


SCALE

 1:500



DESIGN	DJC
CHECKED	BCS
DRAWN	MFD
CHECKED	BCS
APPROVED	BHB

FOR REVIEW ONLY

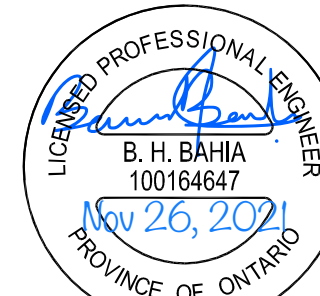

NOVATECH
Engineers, Planners & Landscape Architects
Suite 200, 240 Michael Cowpland Drive
Ottawa, Ontario, Canada K2M 1P6

Telephone (613) 254-9643
Facsimile (613) 254-5867
Website www.novatech-eng.com

LOCATION
CITY OF OTTAWA
THE COMMONS

DRAWING NAME

GENERAL PLAN OF SERVICES

SEE DRAWING No. 118224-GP1

PROJECT No.	118224-00
REV	REV # 6
DRAWING No.	118224-GP2