


KEY PLAN

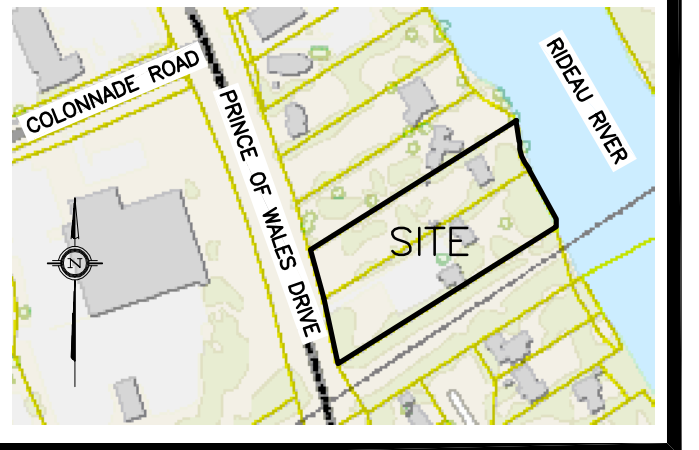

No.	DATE	REVISION
1	JUN 29-23	ISSUED FOR APPROVAL

**D. B. GRAY ENGINEERING INC.**  
 Stormwater Management - Grading & Drainage - Storm & Sanitary Sewers - Watermain  
 700 Long Point Circle 613-425-8044  
 Ottawa, Ontario d.gray@dbgrayengineering.com

Project  
**PROPOSED 7 LOT DEVELOPMENT**  
**2009-2013 PRINCE OF WALES DR**  
 OTTAWA, ONTARIO

Drawing Title  
**PRE-DEVELOPMENT DRAINAGE PLANS**

Engineer's Seal  
  
 NOT VALID UNLESS SIGNED & DATED

Drawn D.B.G.  
 H. Scale 1:300  
 V. Scale  
 Date JUN 29-23  
 Job No. 22055  
 Drawing No.  
**C-9**  
 of 10