




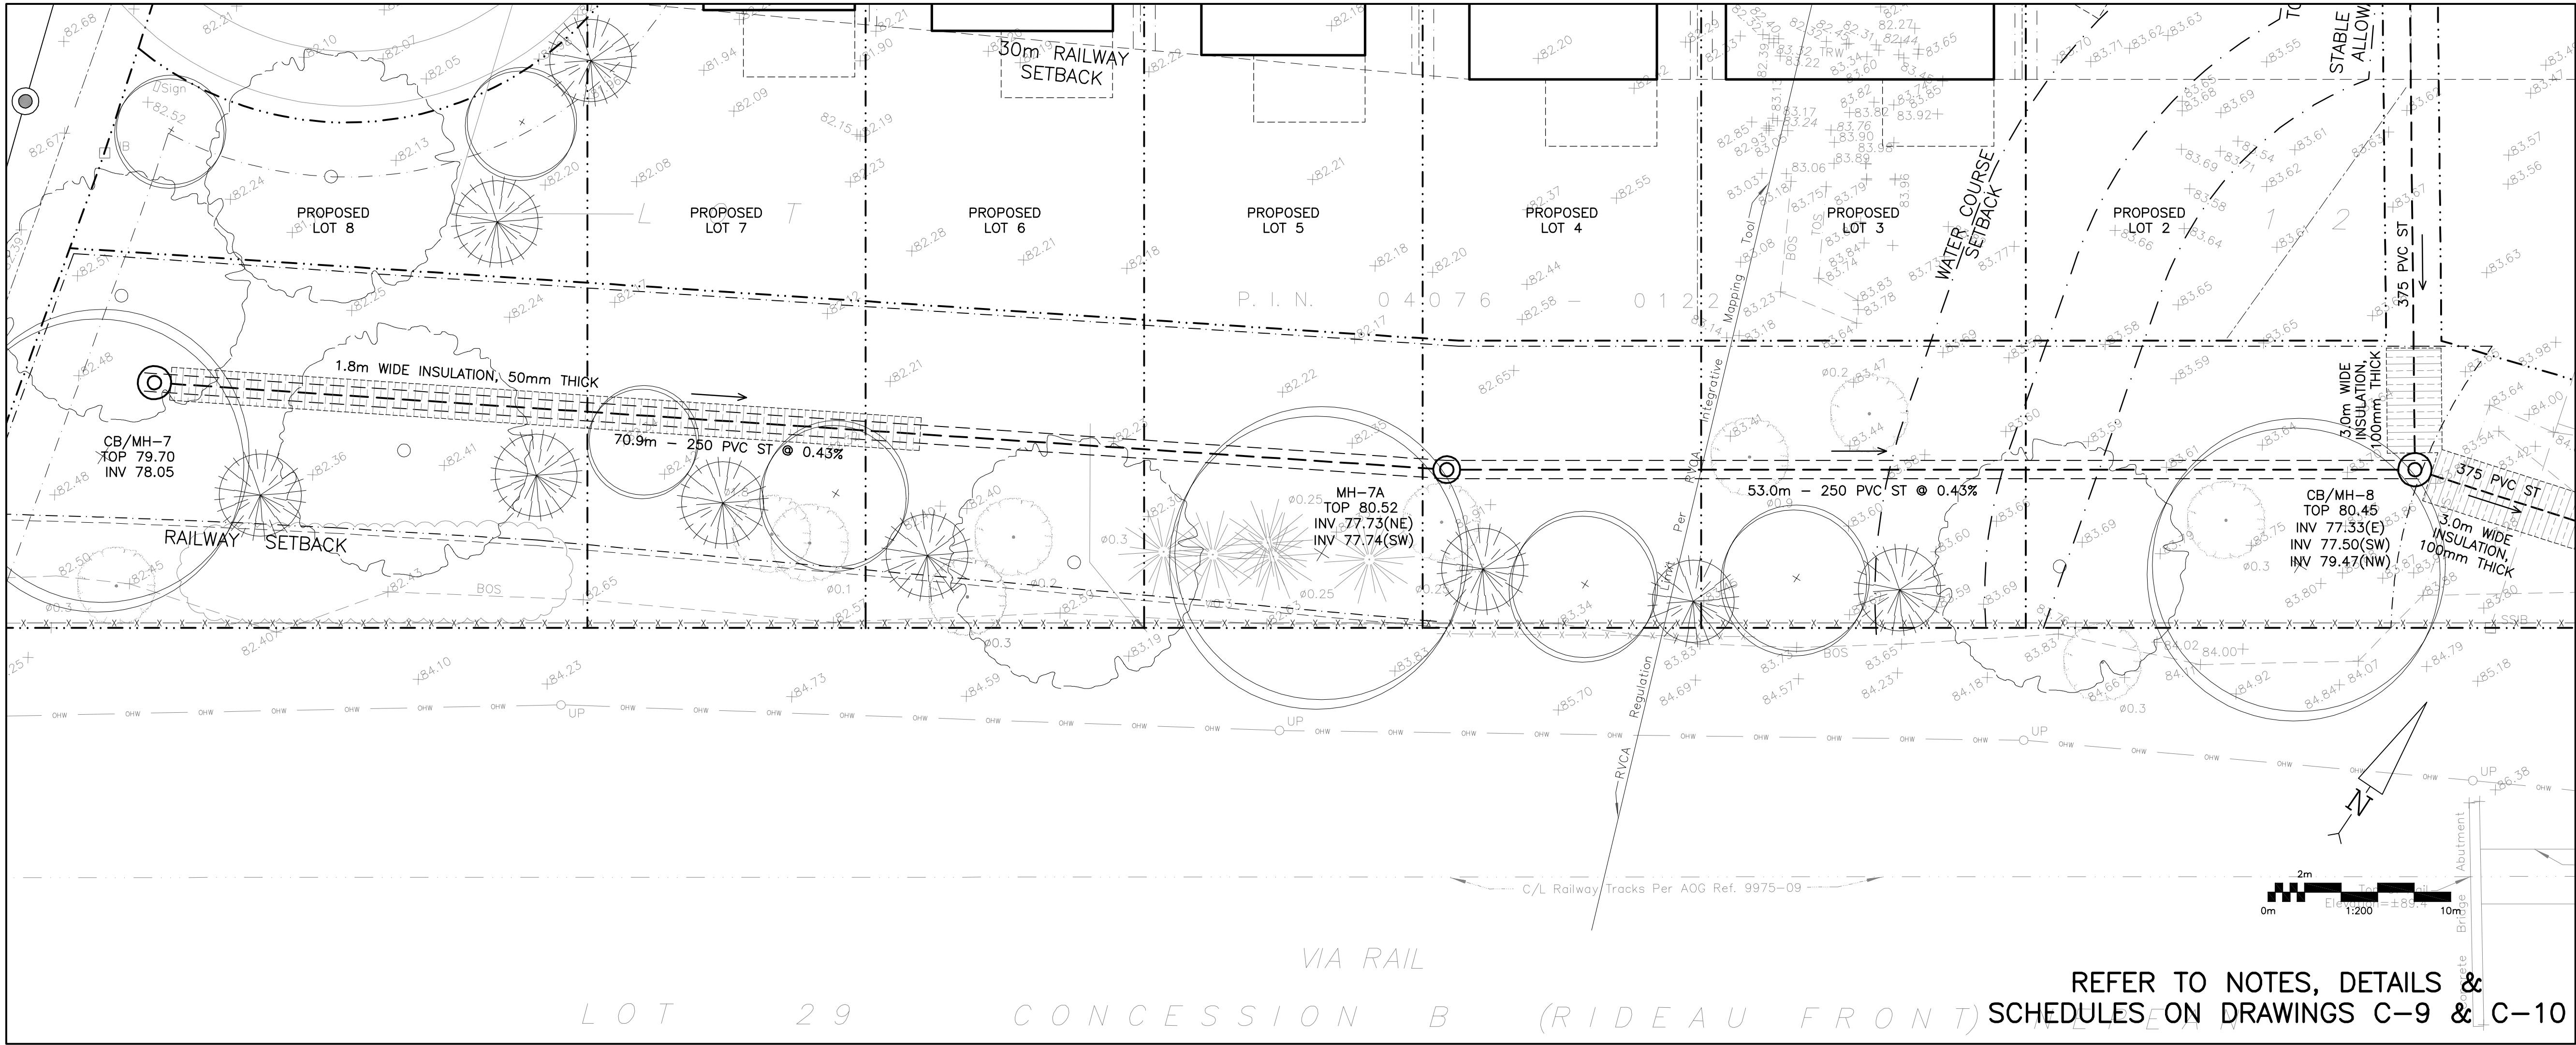

LEGEND	
FFL	FINISHED FLOOR ELEVATION
TOF	TOP OF FOUNDATION
BFL	BASEMENT FLOOR ELEVATION
USF	UNDERSIDE OF FOOTING
---	PROPERTY LINE
C.R.Z.	CRITICAL ROOT ZONE
CB	CATCH-BASIN
MH	STORM MANHOLE
CB/MH	CATCH-BASIN/MANHOLE
MH	SANITARY MANHOLE
VC	VALVE CHAMBER
FH	FIRE HYDRANT
VB	VALVE & VALVE BOX
SAN	SANITARY SEWER
ST	STORM SEWER
WS/WM	WATER SERVICE/WATERMAIN
SPL	SPRINGLINE OF PIPE
INV	INVERT OF PIPE
T.O.S	TOP OF SLOPE
B.O.S	BOTTOM OF SLOPE
---	CENTERLINE OF SWALE
---	150mm BARRIER CURB
D.C	DEPRESSED CURB
=====	ROAD CUT REINSTATEMENT

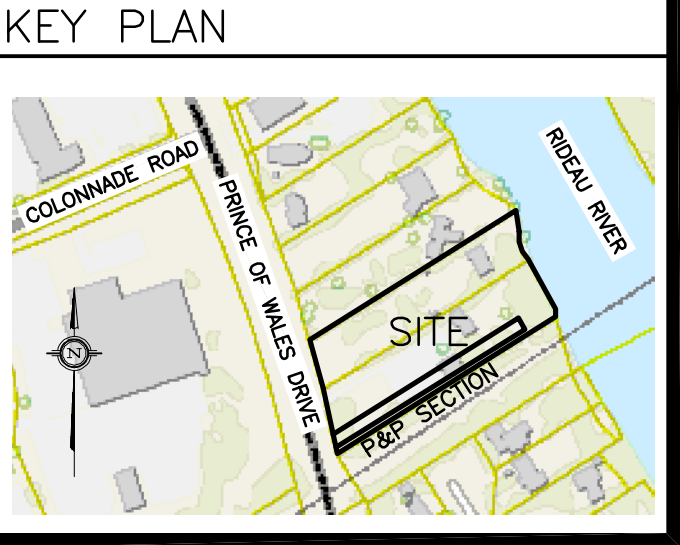

REFER TO NOTES, DETAILS & SCHEDULES ON DRAWINGS C-9 & C-10

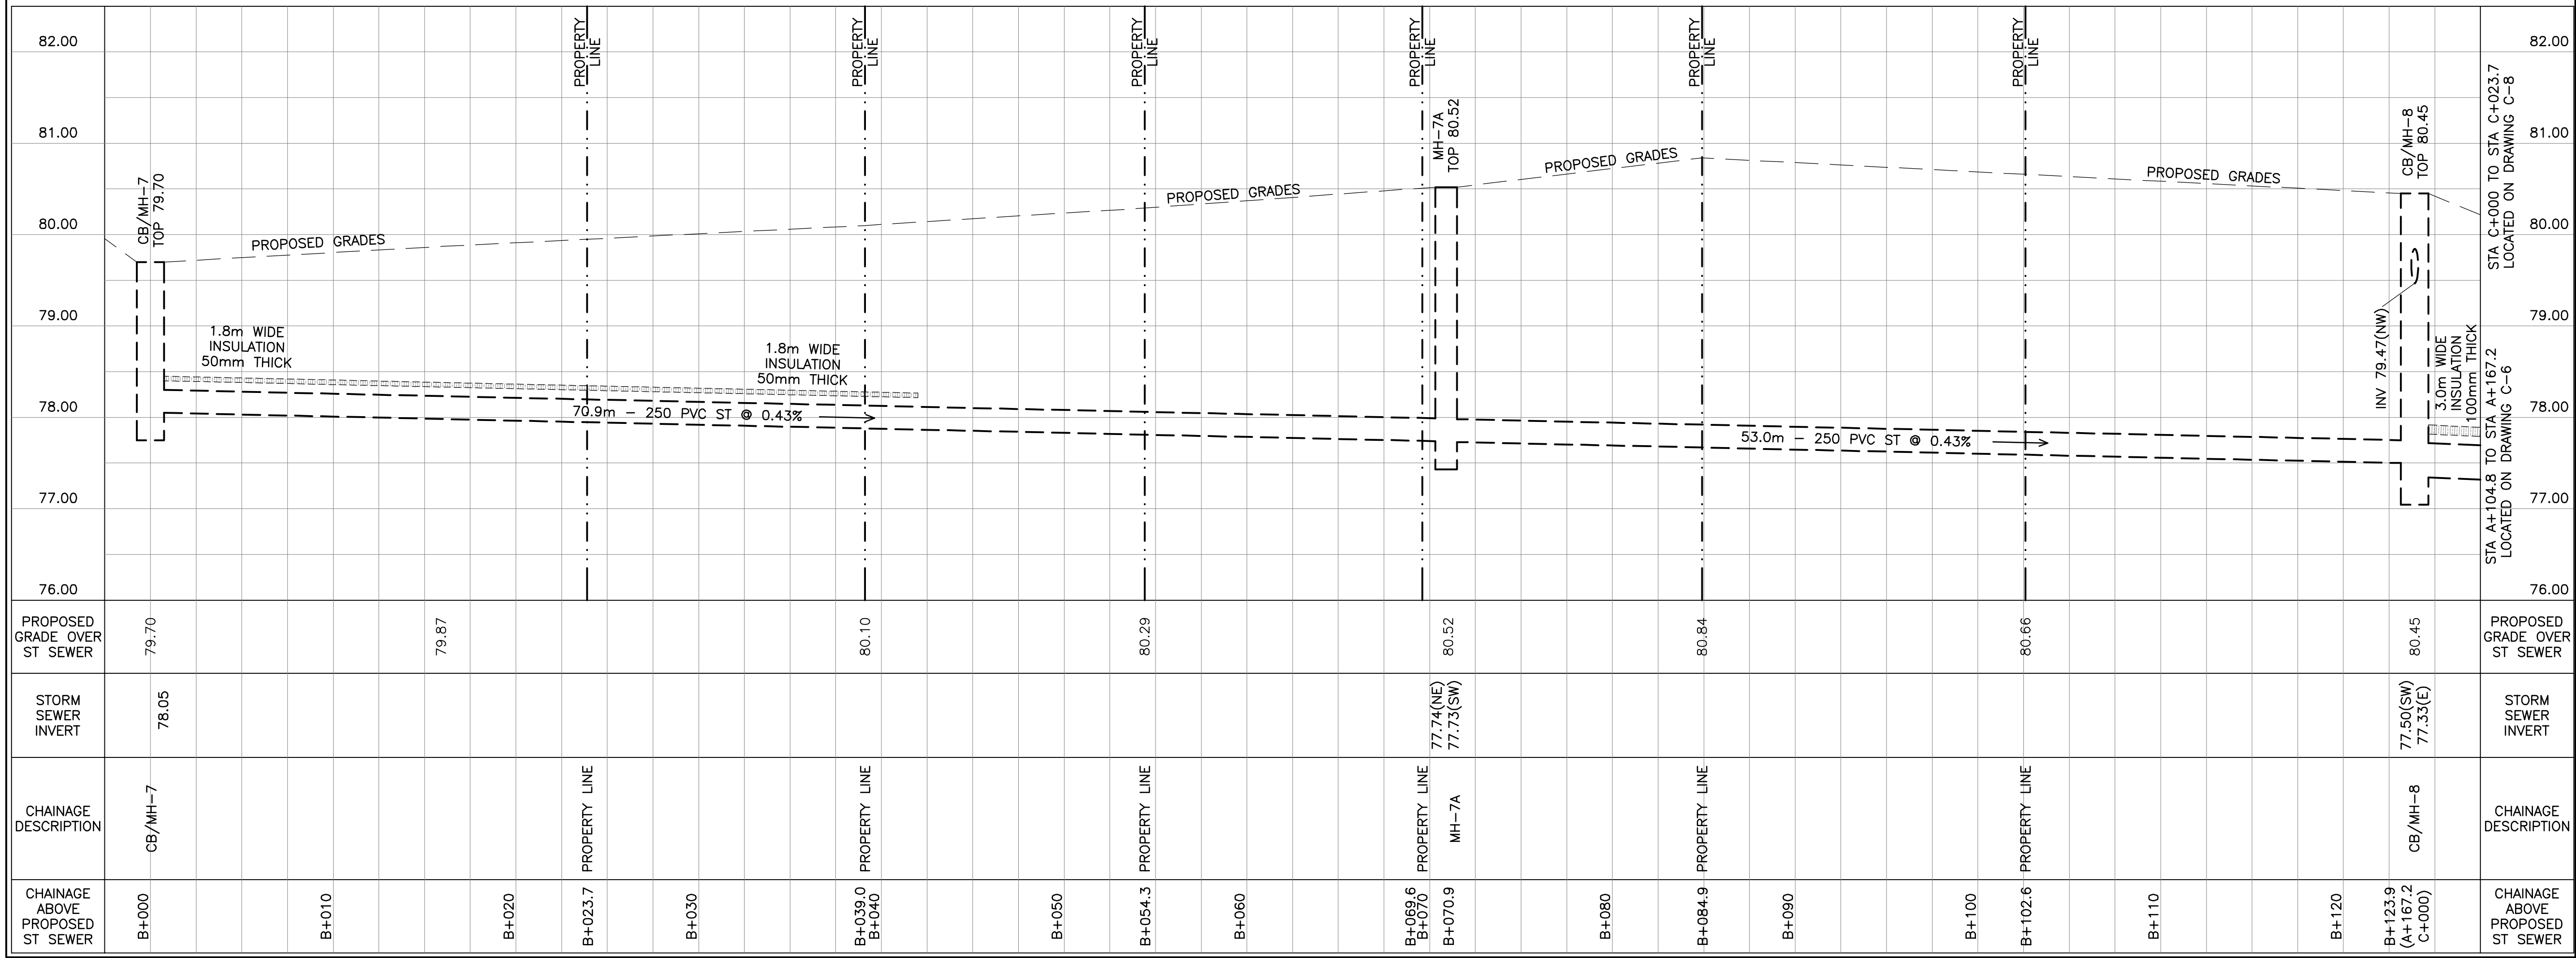

2	APR 14-25	RE-ISSUED FOR APPROVAL
1	JAN 28-25	RE-ISSUED FOR APPROVAL
No.	DATE	REVISION

D. B. GRAY ENGINEERING INC.
Stormwater Management - Grading & Drainage - Storm & Sanitary Sewers - Watermain
700 Long Point Circle
Ottawa, Ontario
613-425-8044
d.gray@dbgrayengineering.com

Project
PROPOSED 7 LOT DEVELOPMENT
2009-2013 PRINCE OF WALES DR
OTTAWA, ONTARIO

Drawing Title
PLAN AND PROFILE
STA B+000.0 TO B+123.9

Engineer's Seal
D.B. GRAY
17016502
APR 14-25
PROVINCE OF ONTARIO
NOT VALID UNLESS SIGNED & DATED

Drawn D.B.G.
H. Scale 1:200
V. Scale 1:40
Date JUN 29-23
Job No. 22055

Drawing No.
C-7
of 10